
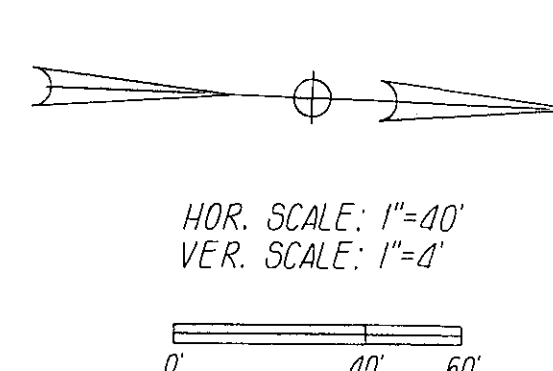


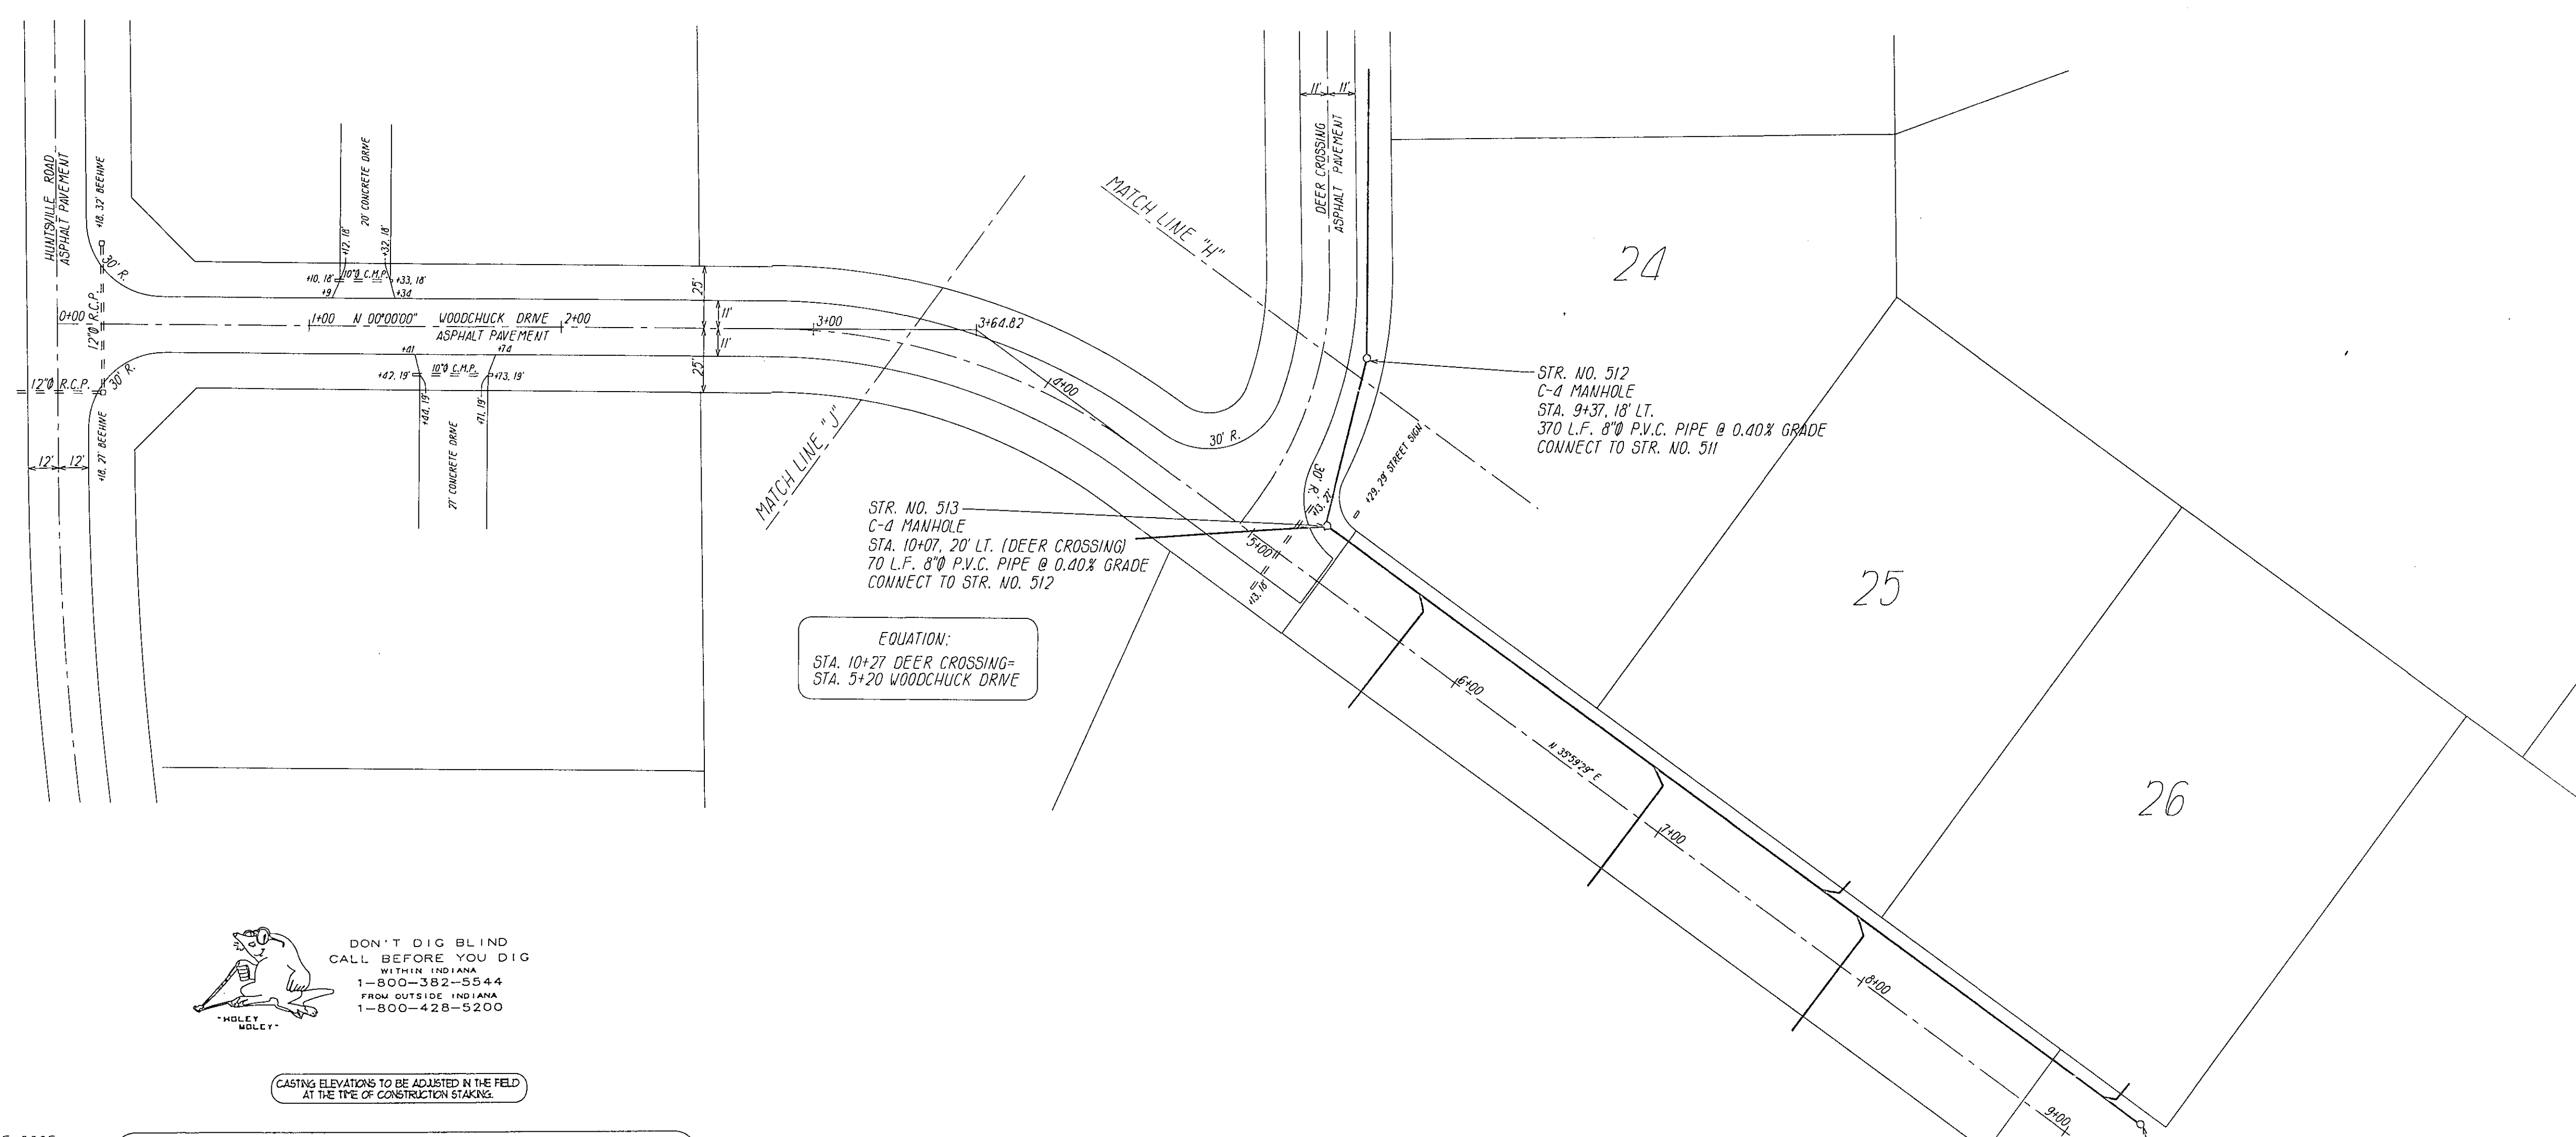


DON'T DIG BLIND
CALL BEFORE YOU DIG
WITHIN INDIANA
1-800-382-5544
FROM OUTSIDE INDIANA
1-800-428-5200

CASTING ELEVATIONS TO BE ADJUSTED IN THE FIELD
AT THE TIME OF CONSTRUCTION STAKING.

CONTRACTOR TO VERIFY THE LOCATION OF ALL EXISTING
UTILITIES PRIOR TO COMMENCEMENT OF CONSTRUCTION.

T.B.M. #9 SPIKE NAIL: N. SIDE POWER POLE #5105-0805
STATION 0+22 RIGHT 7' ELEV. = 880.94

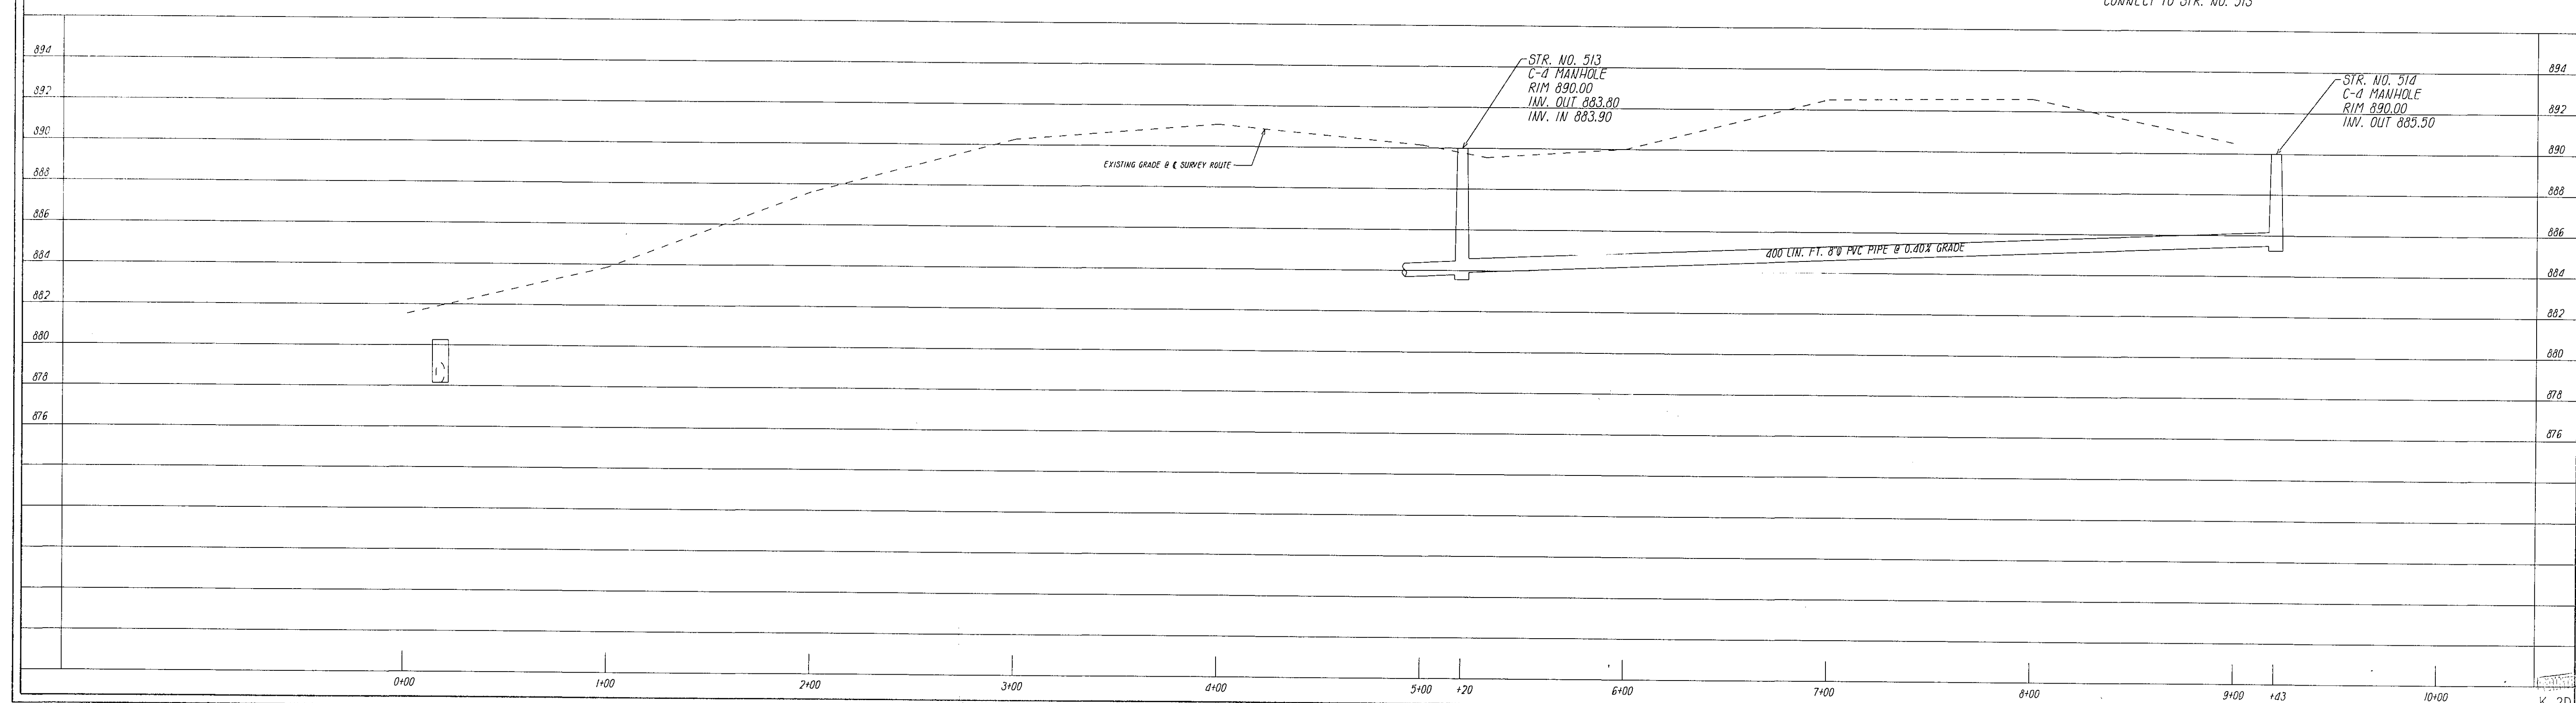

BRADLEY A. RAYL
SURVEYING & ENGINEERING
2036 MELODY LANE
ANDERSON, IN. 46012
(317) 643-5614

SANITARY SEWER PLAN AND PROFILES
REVISED:

HICKORY HILLS EAST
FALL CREEK TOWNSHIP
MADISON COUNTY, INDIANA
DRAWN BY: Perry A. Naum
DATE: MAY 17, 1993

BY: *Bradley*
DATE: 6-6-93
SHEET
12/1993
K. 20