



Revised Page 0 78


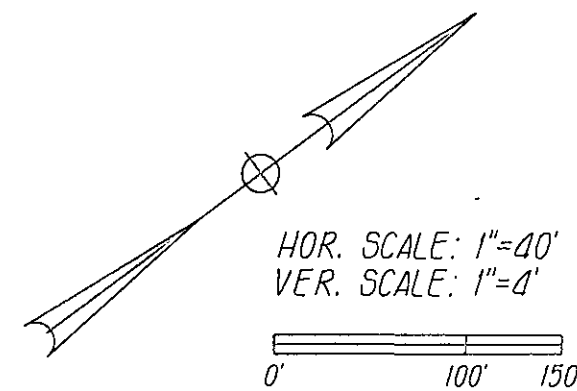


B. M. CHISEL "□" IN TOP OF HEADWALL ON CULVERT
NORTH SIDE HUNTSVILLE ROAD 200± W. OF 0+00 ELEV. = 865.74

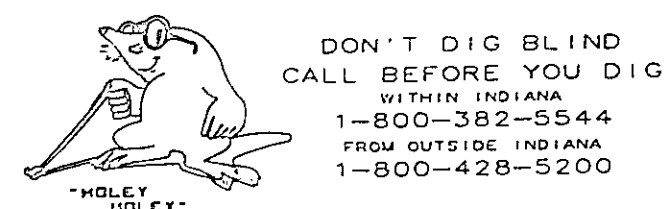

CASTING ELEVATIONS TO BE ADJUSTED IN THE FIELD
AT THE TIME OF CONSTRUCTION STAKING.

CONTRACTOR TO VERIFY THE LOCATION OF ALL EXISTING
UTILITIES PRIOR TO COMMENCEMENT OF CONSTRUCTION.

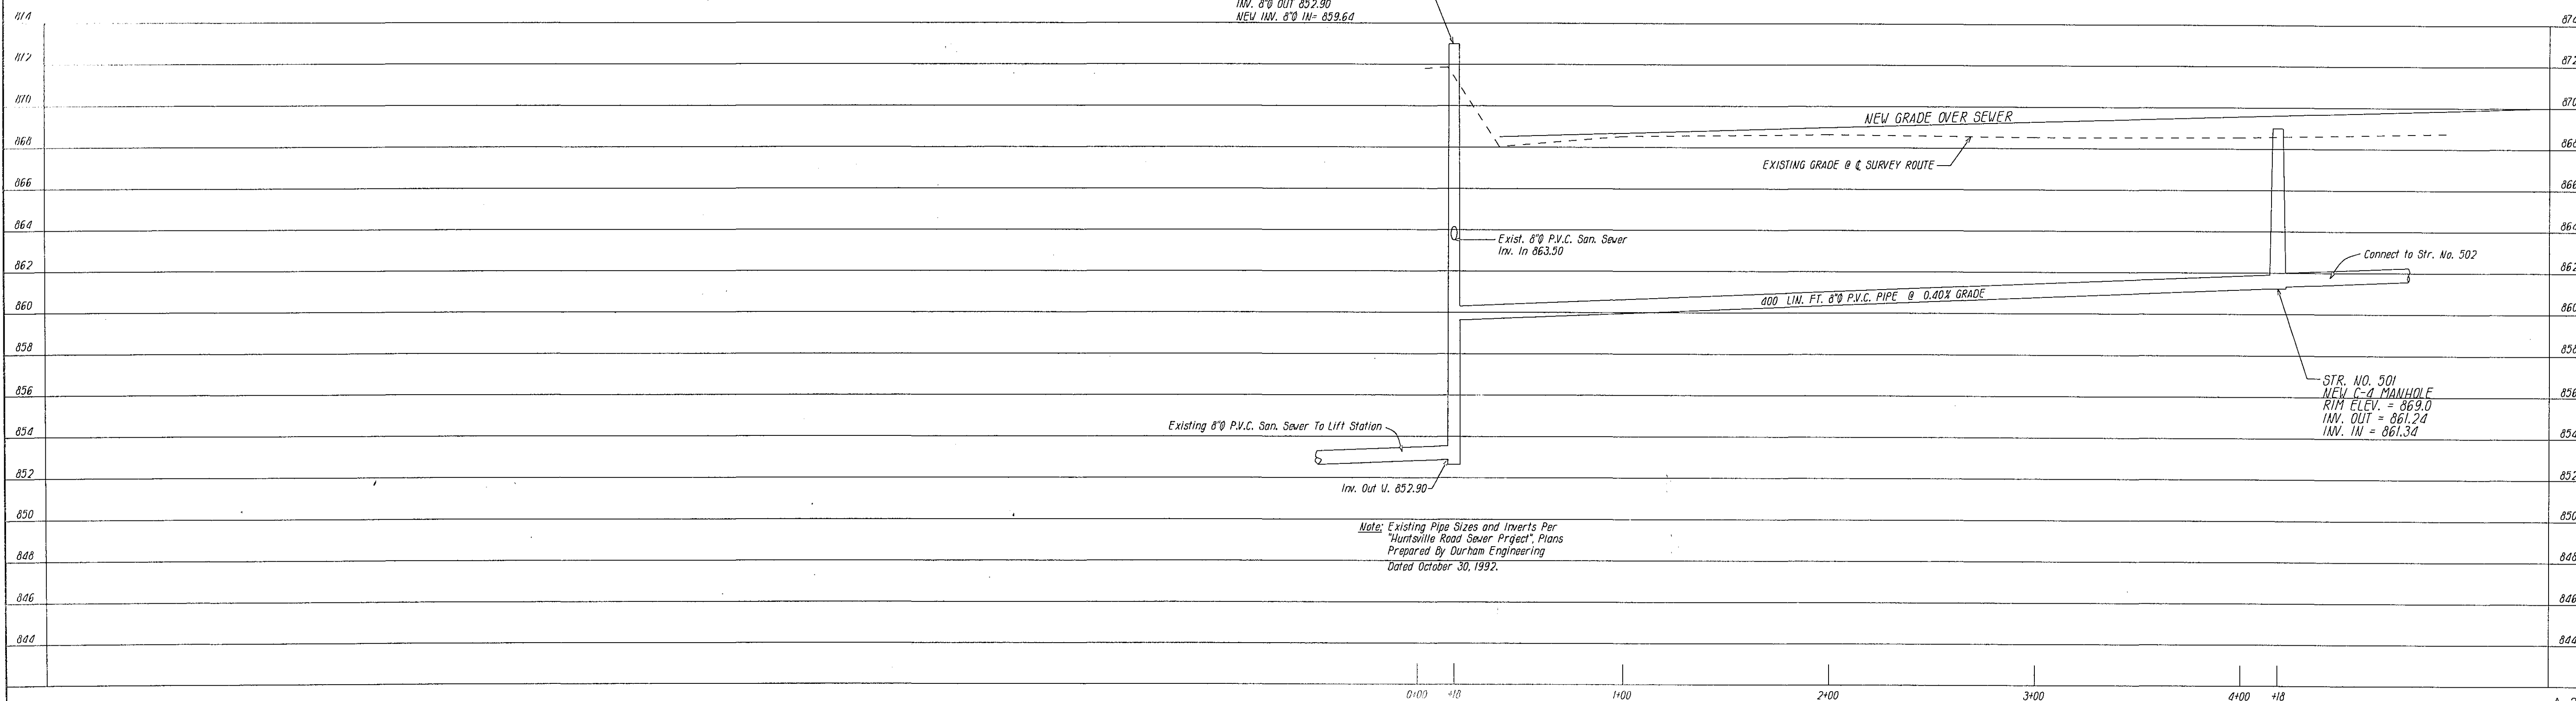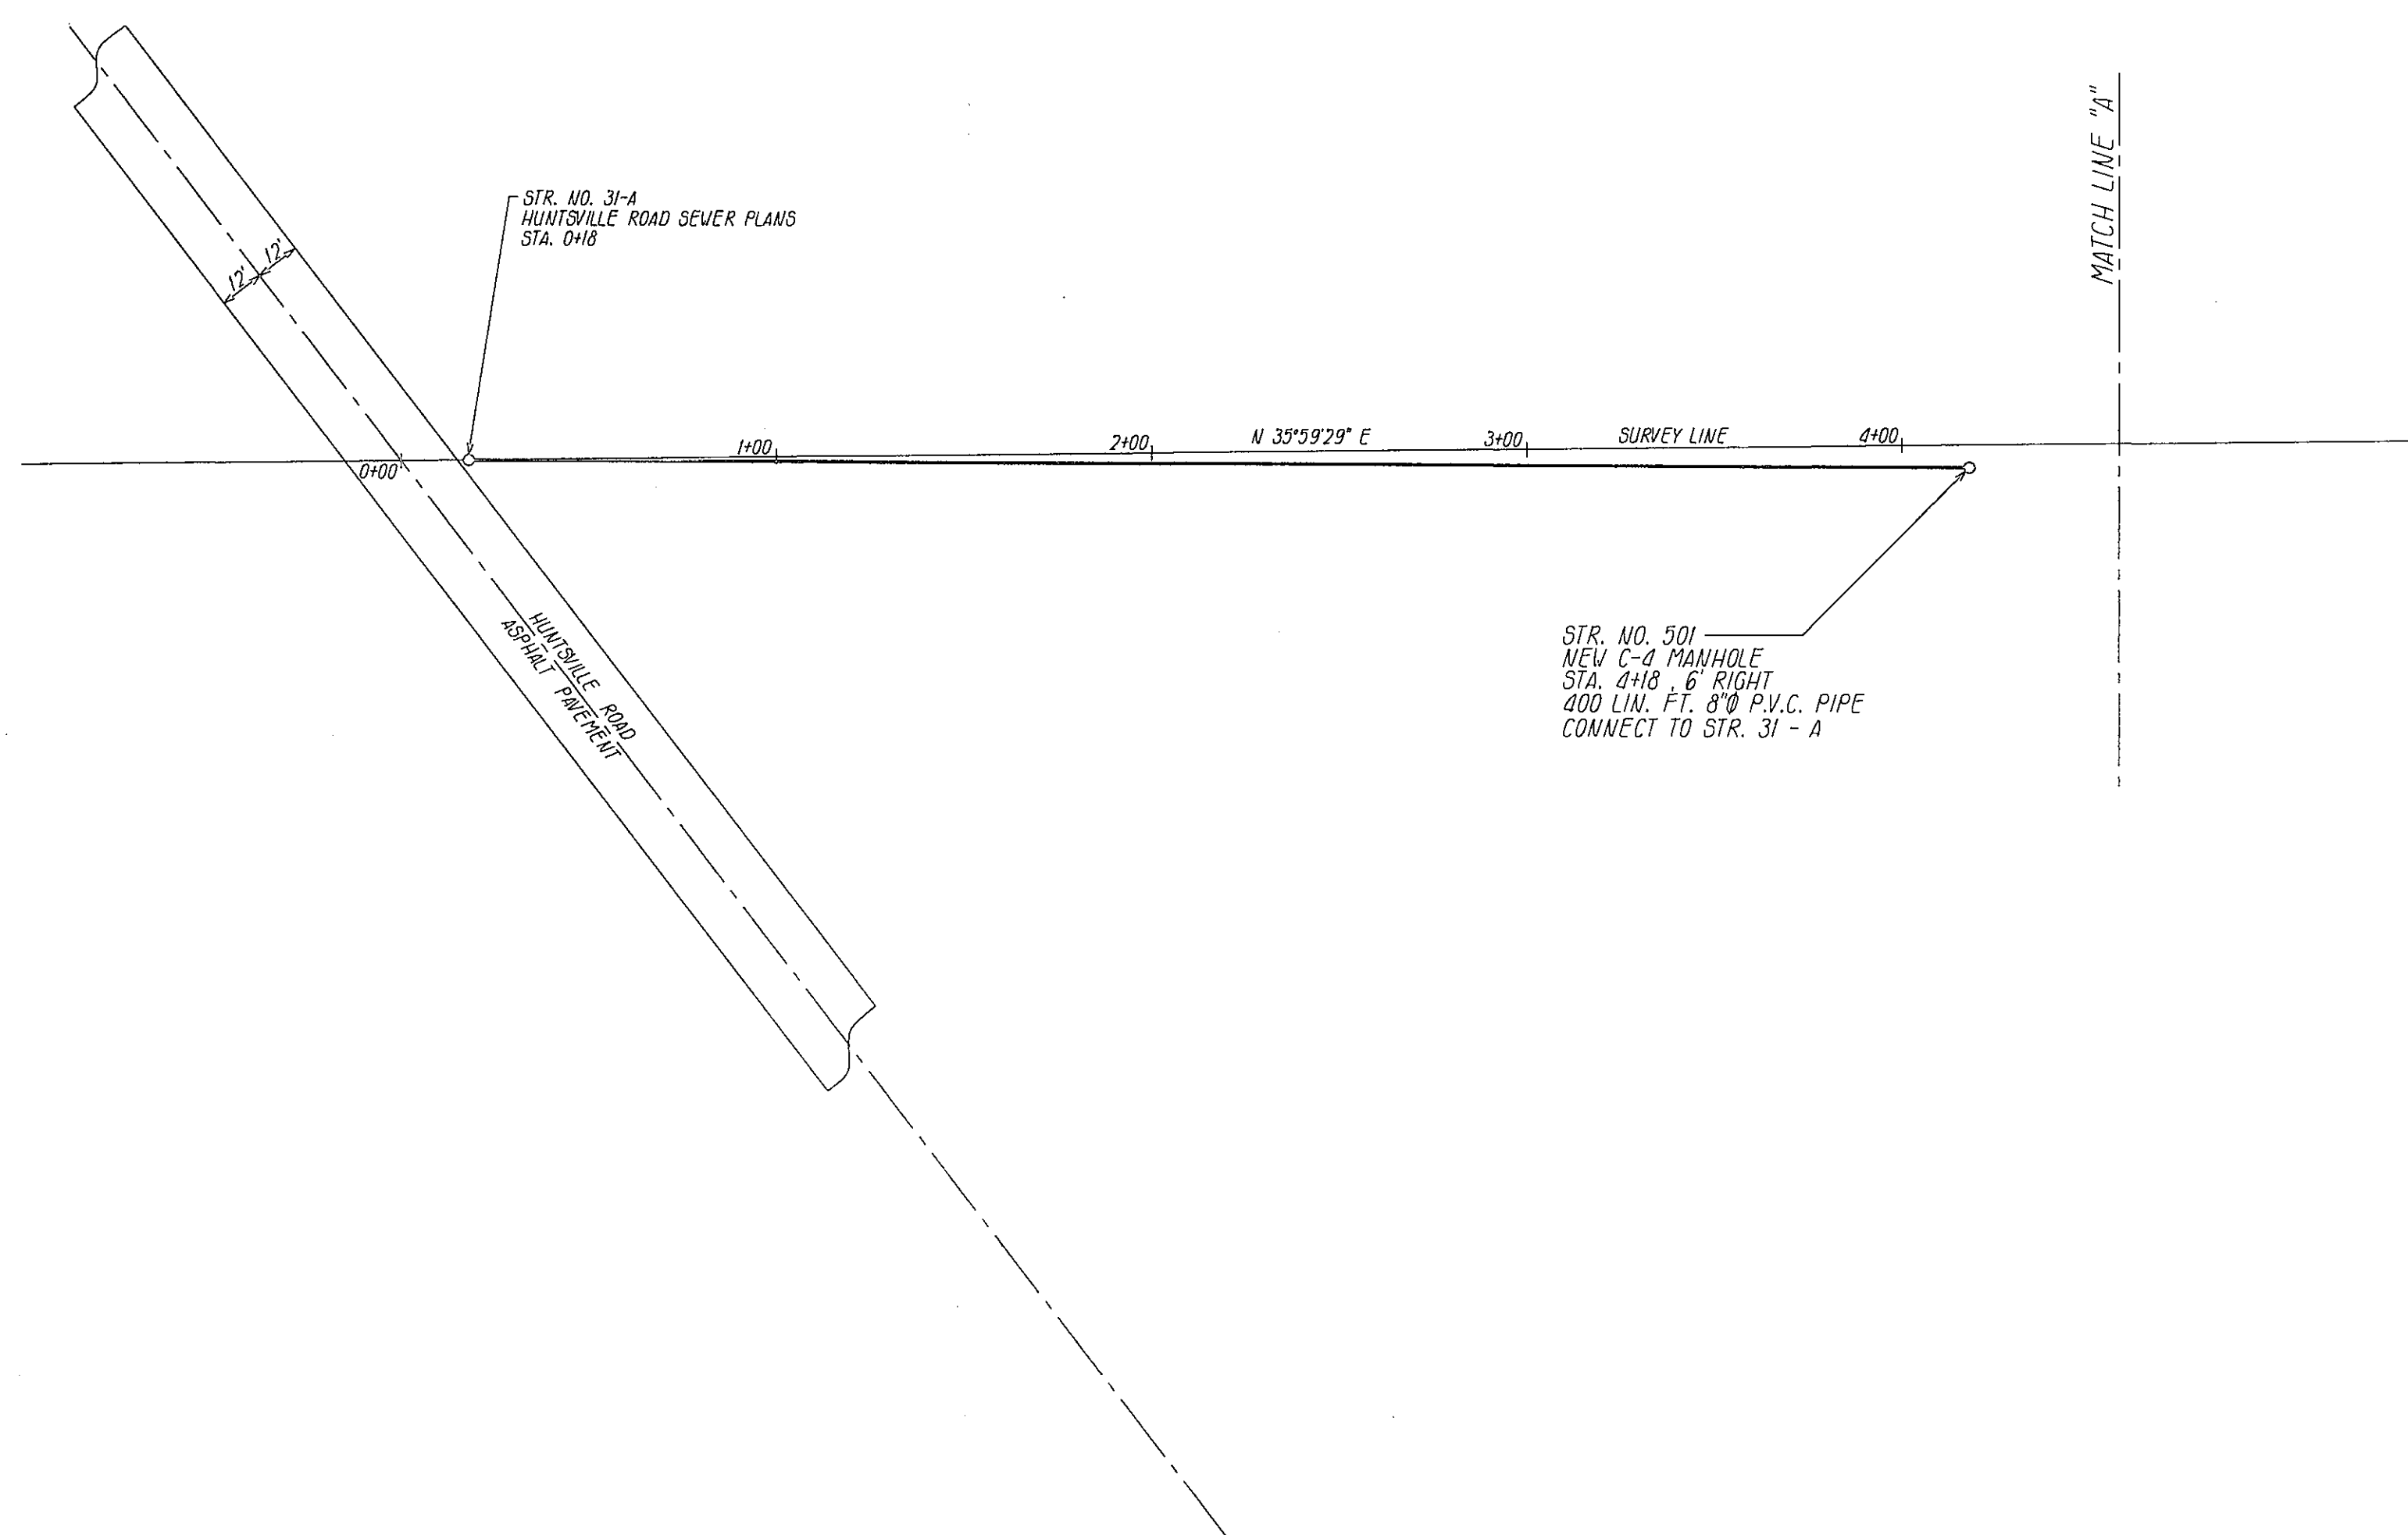

EXISTING STR. NO. 31-A
TYPE C-4 DROP MANHOLE
PER HUNTSVILLE ROAD SEWER PLANS
PLANS BY DURHAM ENGINEERING
RIM ELEV. = 873.0
INV. IN = 863.90
INV. 8" OUT 852.90
NEW INV. 8" IN = 859.64

Existing 8" P.V.C. San. Sewer To Lift Station
Inv. Out V. 852.90

Note: Existing Pipe Sizes and Inverts Per
"Huntsville Road Sewer Project" Plans
Prepared By Durham Engineering
Dated October 30, 1992.

STR. NO. 501
NEW C-4 MANHOLE
RIM ELEV. = 863.0
INV. OUT = 861.24
INV. IN = 861.34


BRADLEY A. RAYL
SURVEYING & ENGINEERING
2036 MELODY LANE
ANDERSON, IN. 46012
(317) 643-5614

SANITARY SEWER PLAN AND PROFILES

REVISIONS: July 23, 1993 P&I/102 & Add Exst. Data For Str. No.
31-A (P.A.N.)

HICKORY HILLS EAST
FALL CREEK TOWNSHIP
MADISON COUNTY, INDIANA

DRAWN BY BRIAN RAYL DATE MAY 14, 1993

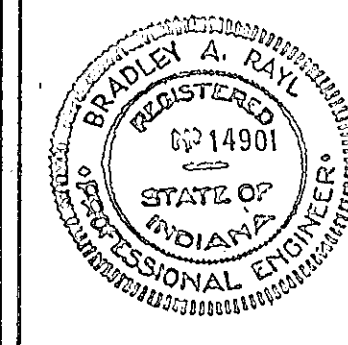

BY: *Bradley A. Rayl*
DATE: 6-4-93

SHEET

31

A 2D