
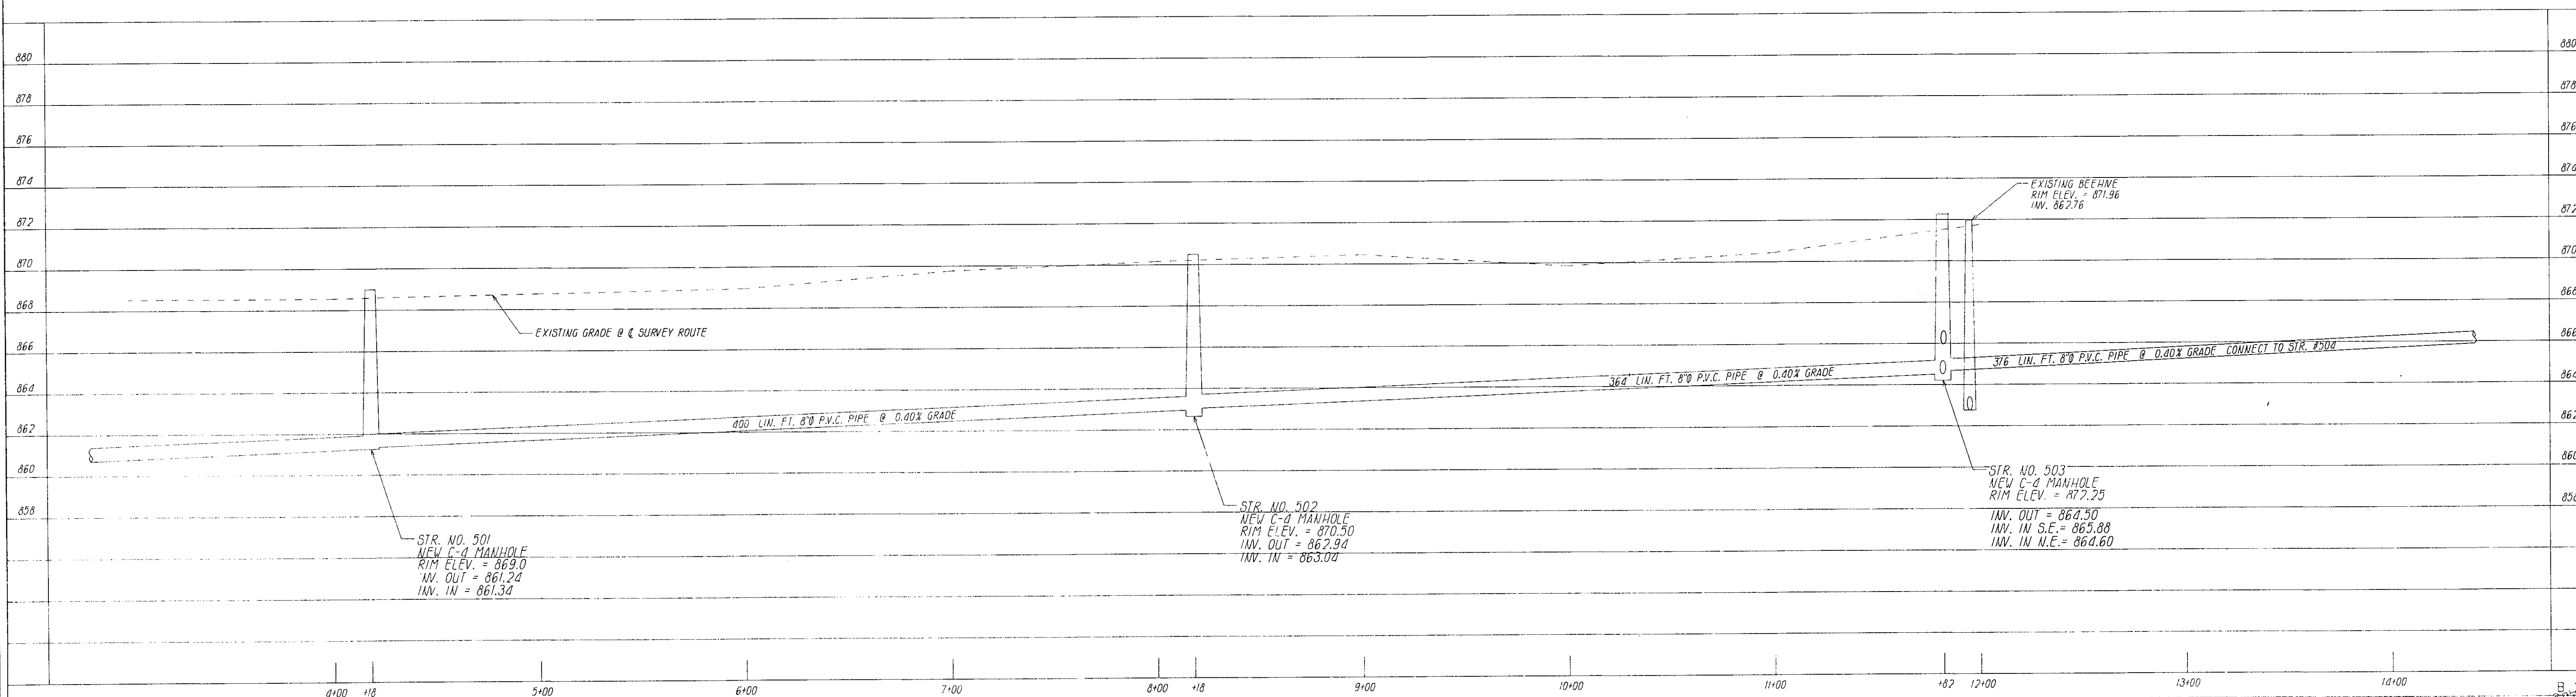


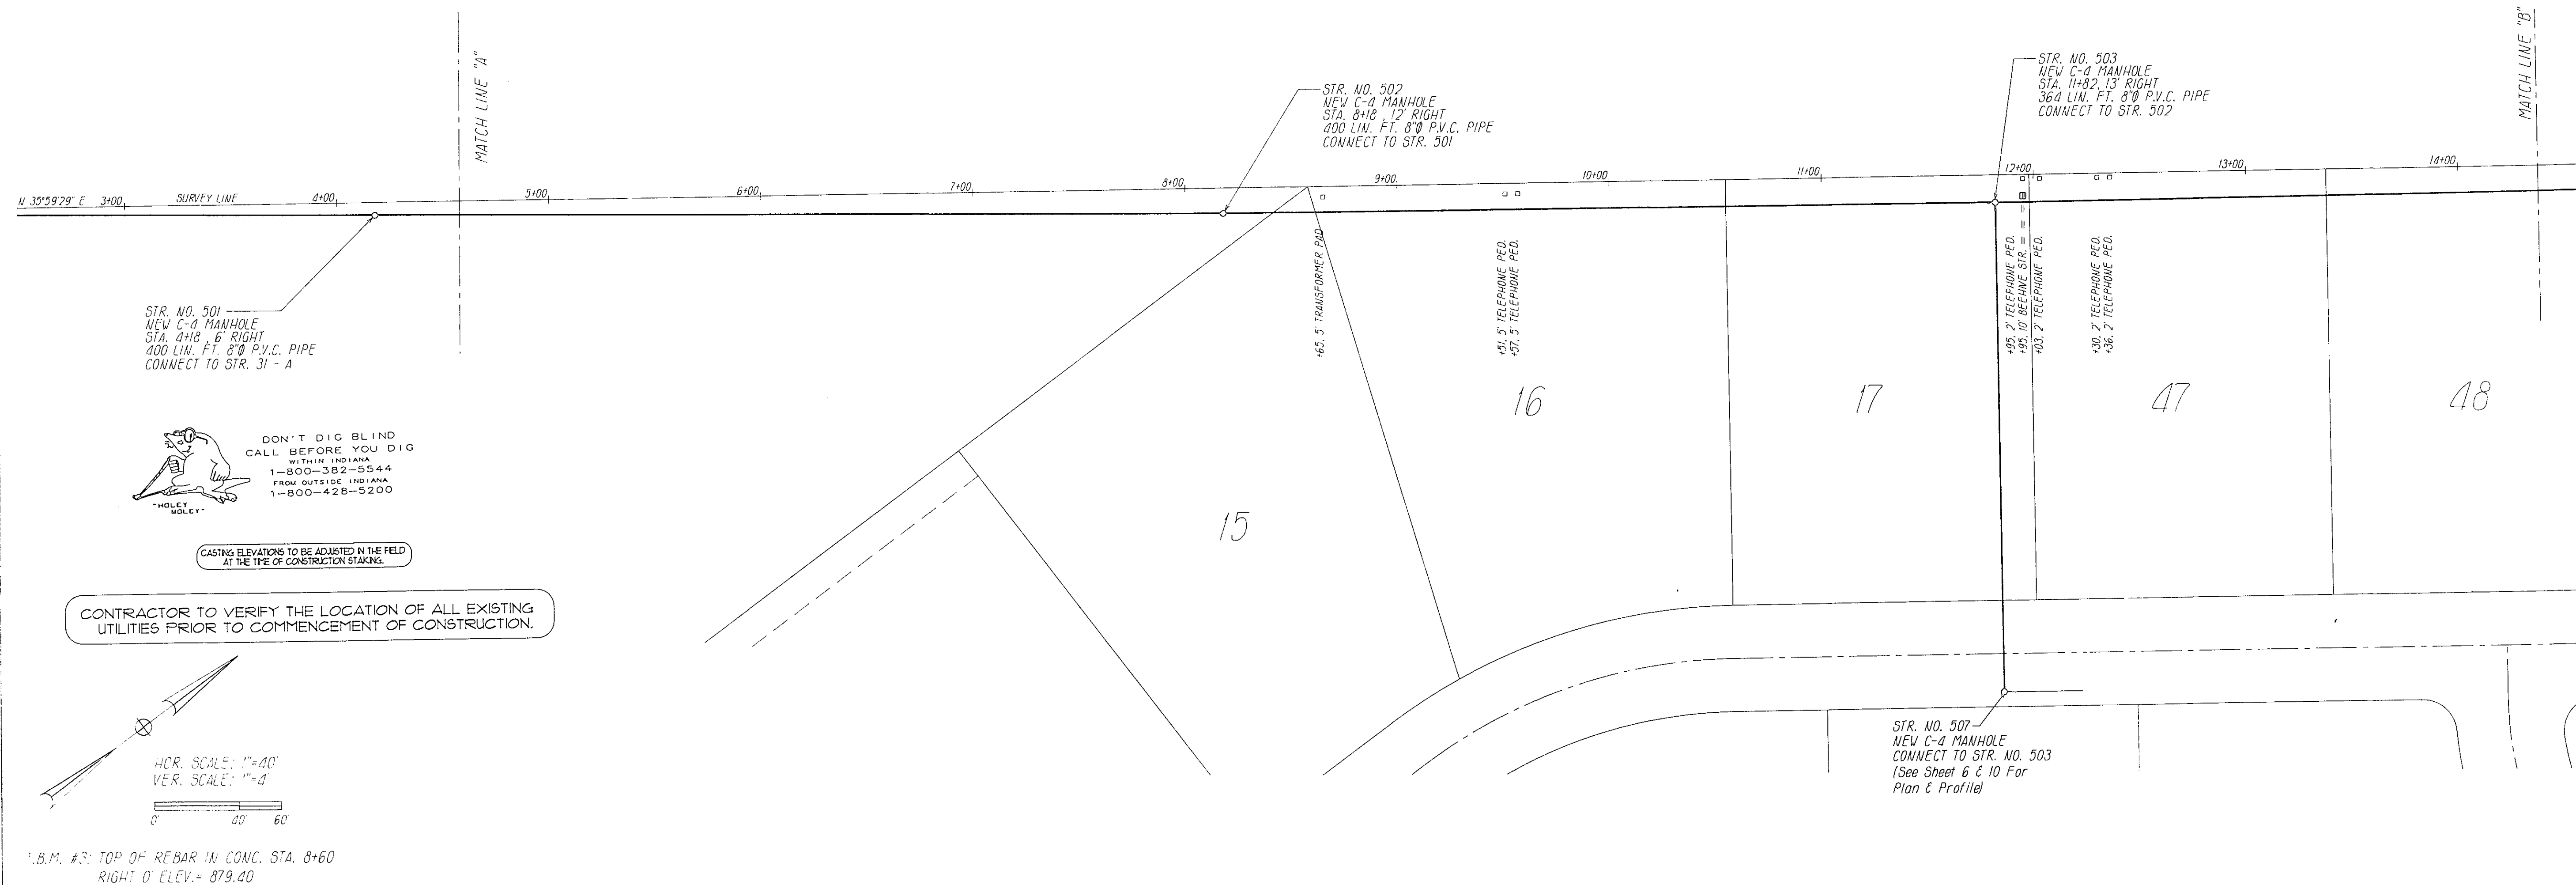

BRADLEY A. RAYL
SURVEYING & ENGINEERING
2036 MELODY LANE
ANDERSON, IN. 46012
(317) 643-5614

SANITARY SEWER PLAN AND PROFILES

REVISIONS: July 29, 1993 Str. No. 503 (P.A.N.)

HICKORY HILLS EAST
FALL CREEK TOWNSHIP
MADISON COUNTY, INDIANA

DRAWN BY: BRIAN RAYL DATE: MAY 14, 1993

BY: *Bradley A. Rayl*

DATE: 7-14-93

SHEET
4/