


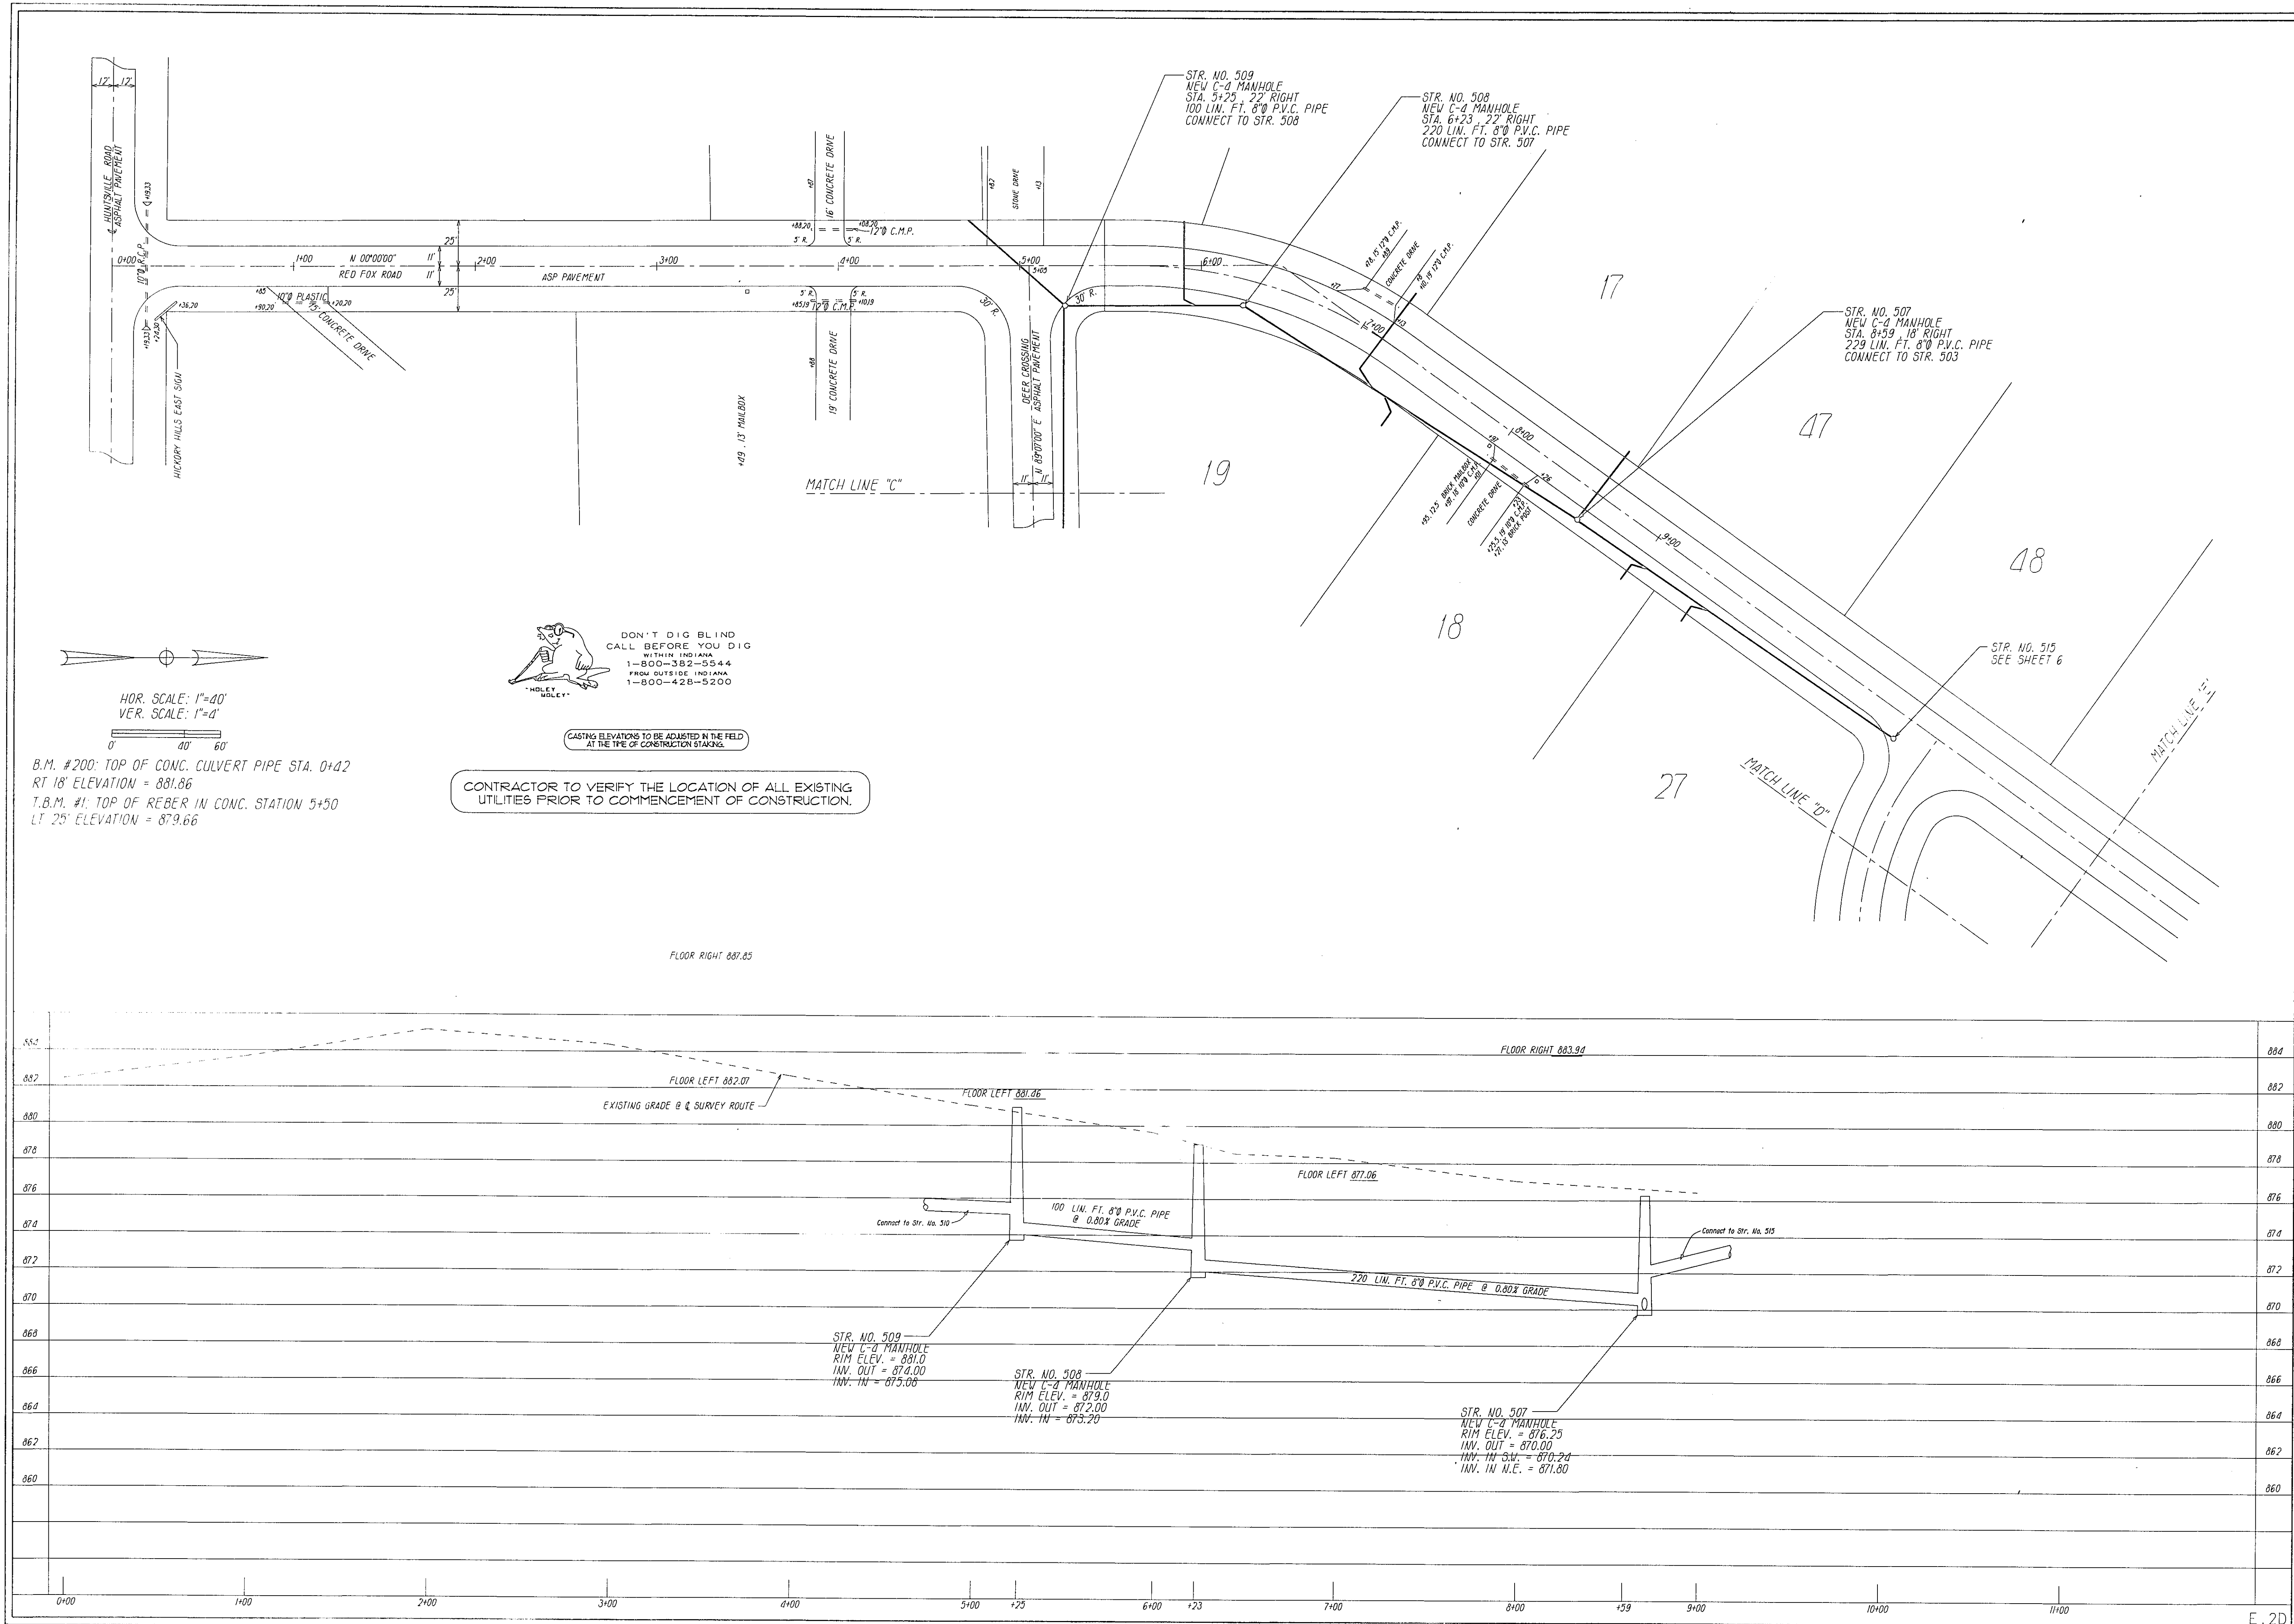

BRADLEY A. RAYL
SURVEYING & ENGINEERING
2036 MELODY LANE
ANDERSON, IN. 46012
(317) 643-5614

SANITARY SEWER PLAN AND PROFILES

HICKORY HILLS EAST
FALL CREEK TOWNSHIP
MADISON COUNTY, INDIANA

BY: *Brian Rayl*
DATE: 6-14-93
SHEET
101/

DRAWN BY: BRIAN RAYL
DATE: MAY 14, 1993