



Sanitary Sewer 12 7.0

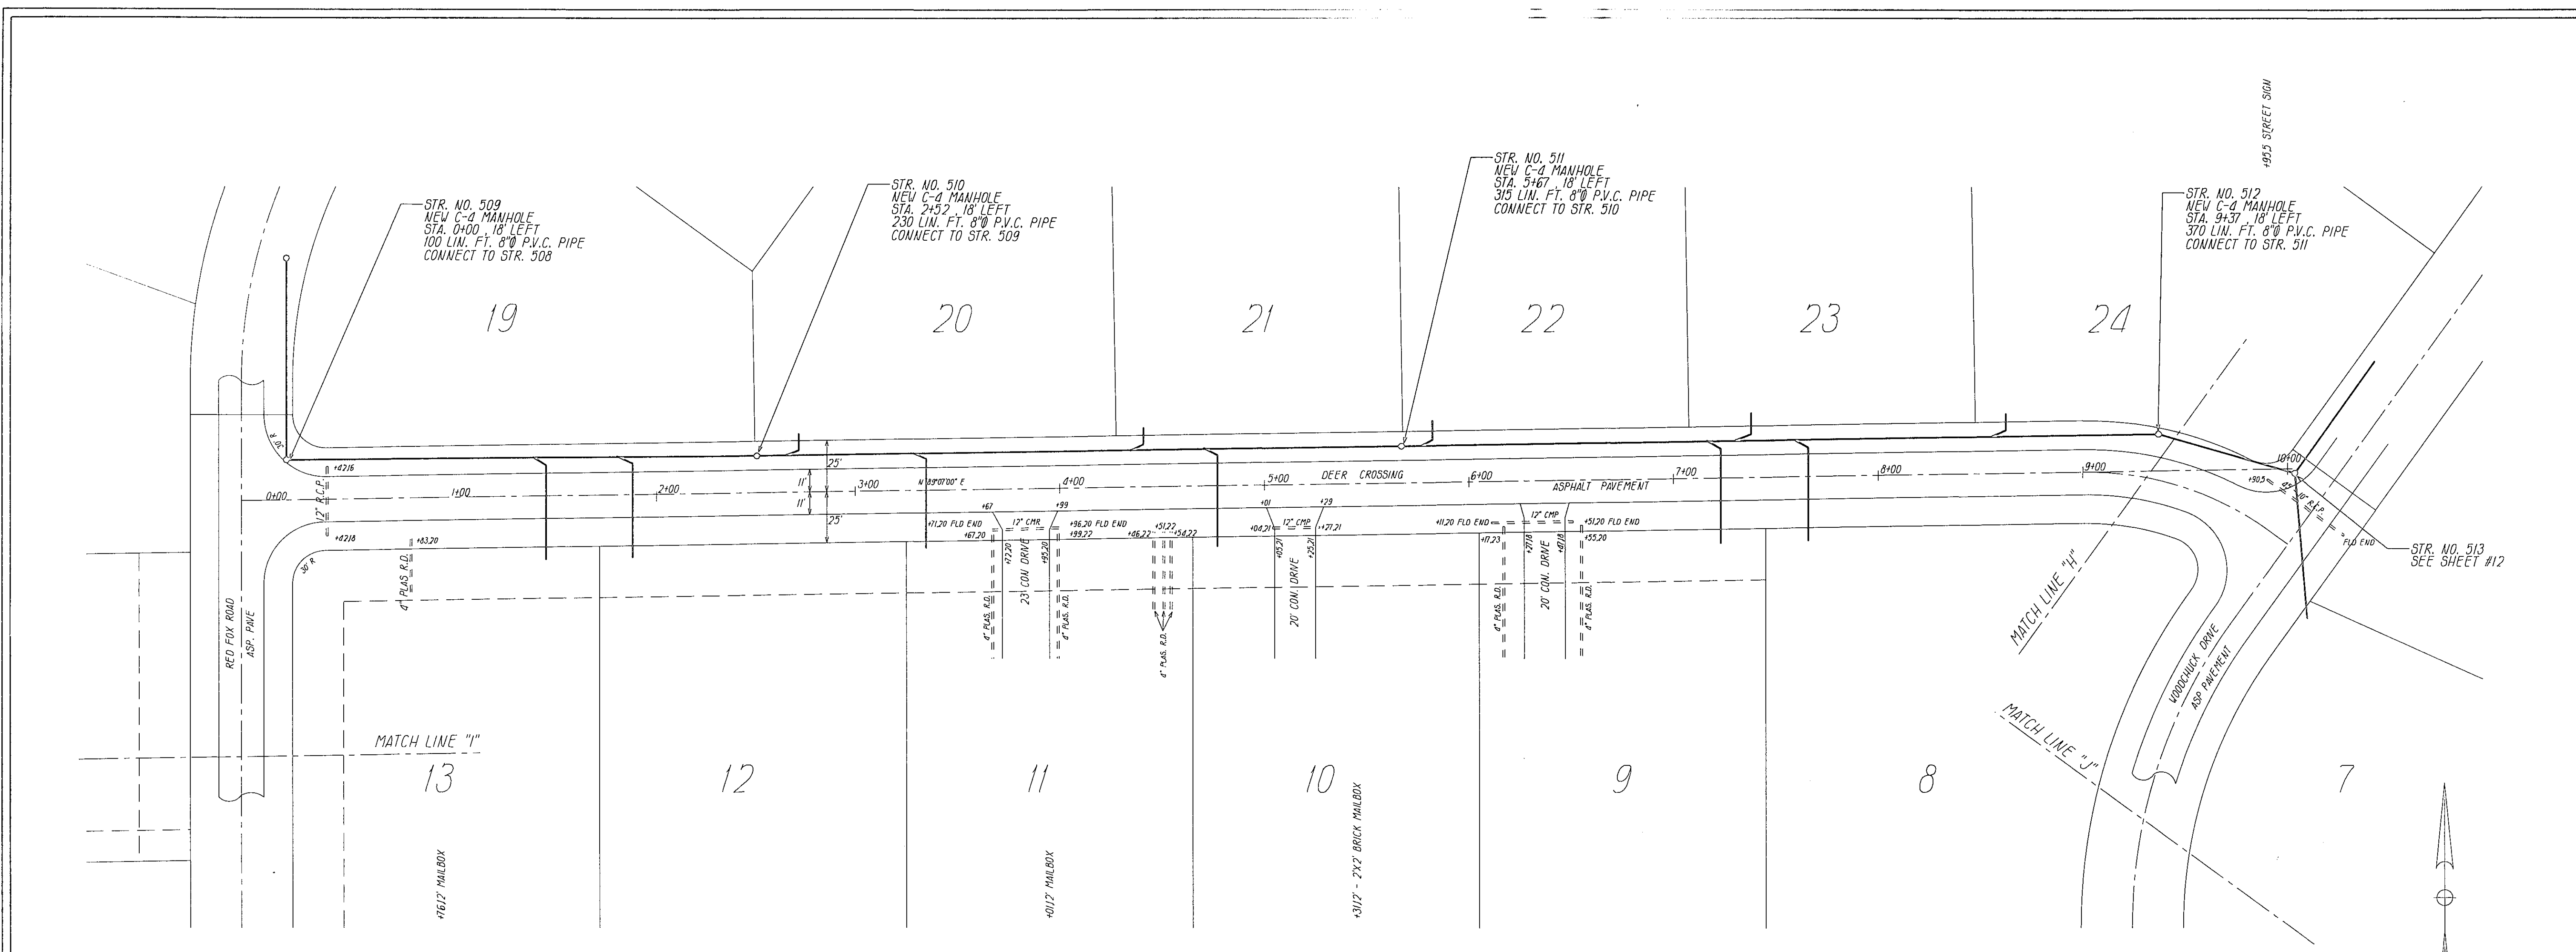


CASTING ELEVATIONS TO BE ADJUSTED IN THE FIELD
AT THE TIME OF CONSTRUCTION STAKING.

CONTRACTOR TO VERIFY THE LOCATION OF ALL EXISTING
UTILITIES PRIOR TO COMMENCEMENT OF CONSTRUCTION.

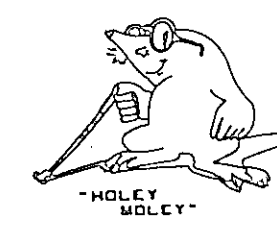

DON'T DIG BLIND
CALL BEFORE YOU DIG
WITHIN INDIANA
1-800-382-5544
FROM OUTSIDE INDIANA
1-800-428-5200


VER. SCALE: 1"=4'
0' 40' 60'

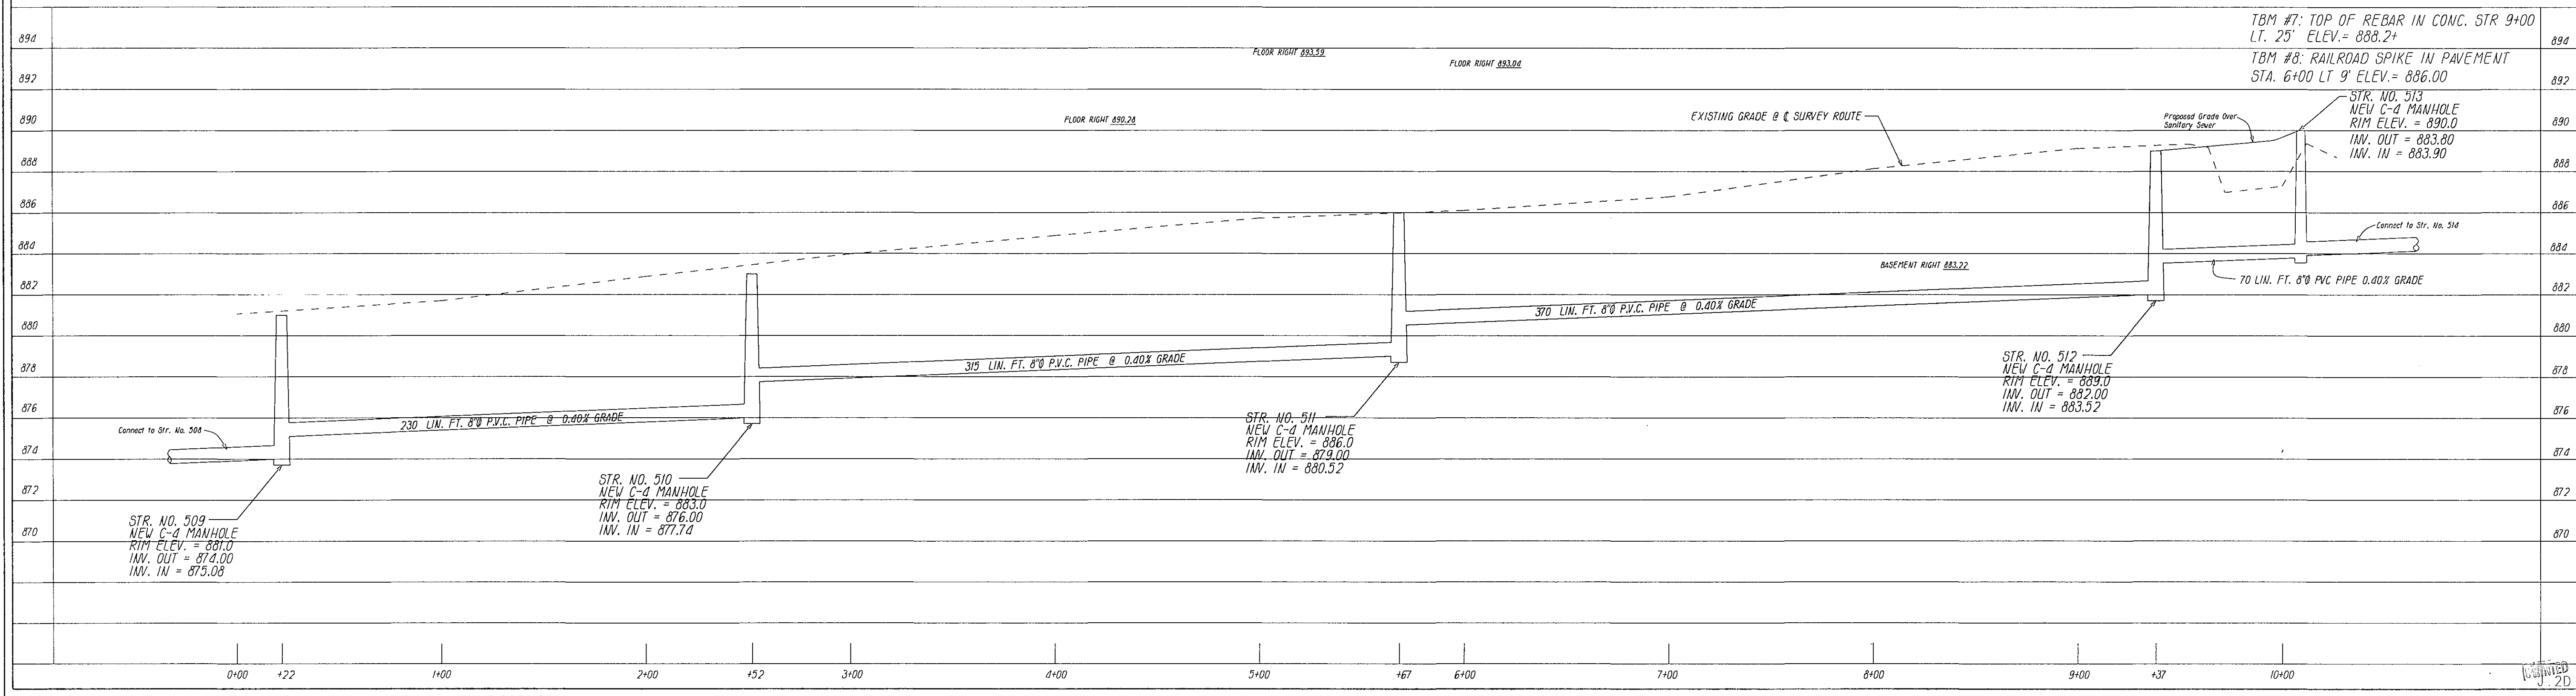

BRADLEY A. RAYL
SURVEYING & ENGINEERING
2036 MELODY LANE
ANDERSON, IN. 46012
(317) 643-5614

SANITARY SEWER PLAN AND PROFILES
REVISIONS: July 23, 1993 Add Str. No. 513 to Profile; Redraw
Pipe on Profile Between Str. No. 509 & 510 (P.A.N.)

HICKORY HILLS EAST
FALL CREEK TOWNSHIP
MADISON COUNTY, INDIANA
DATE: MAY 14, 1993
DRAWN BY: BRIAN RAYL

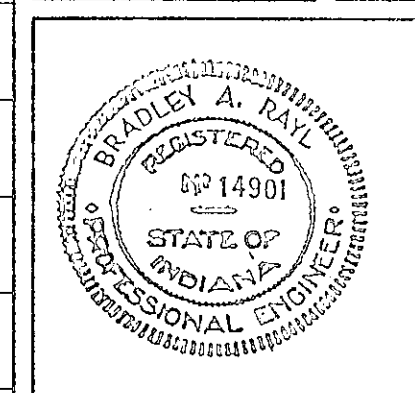

DATE: 6.4.93
SHEET
OCT 05 1993