

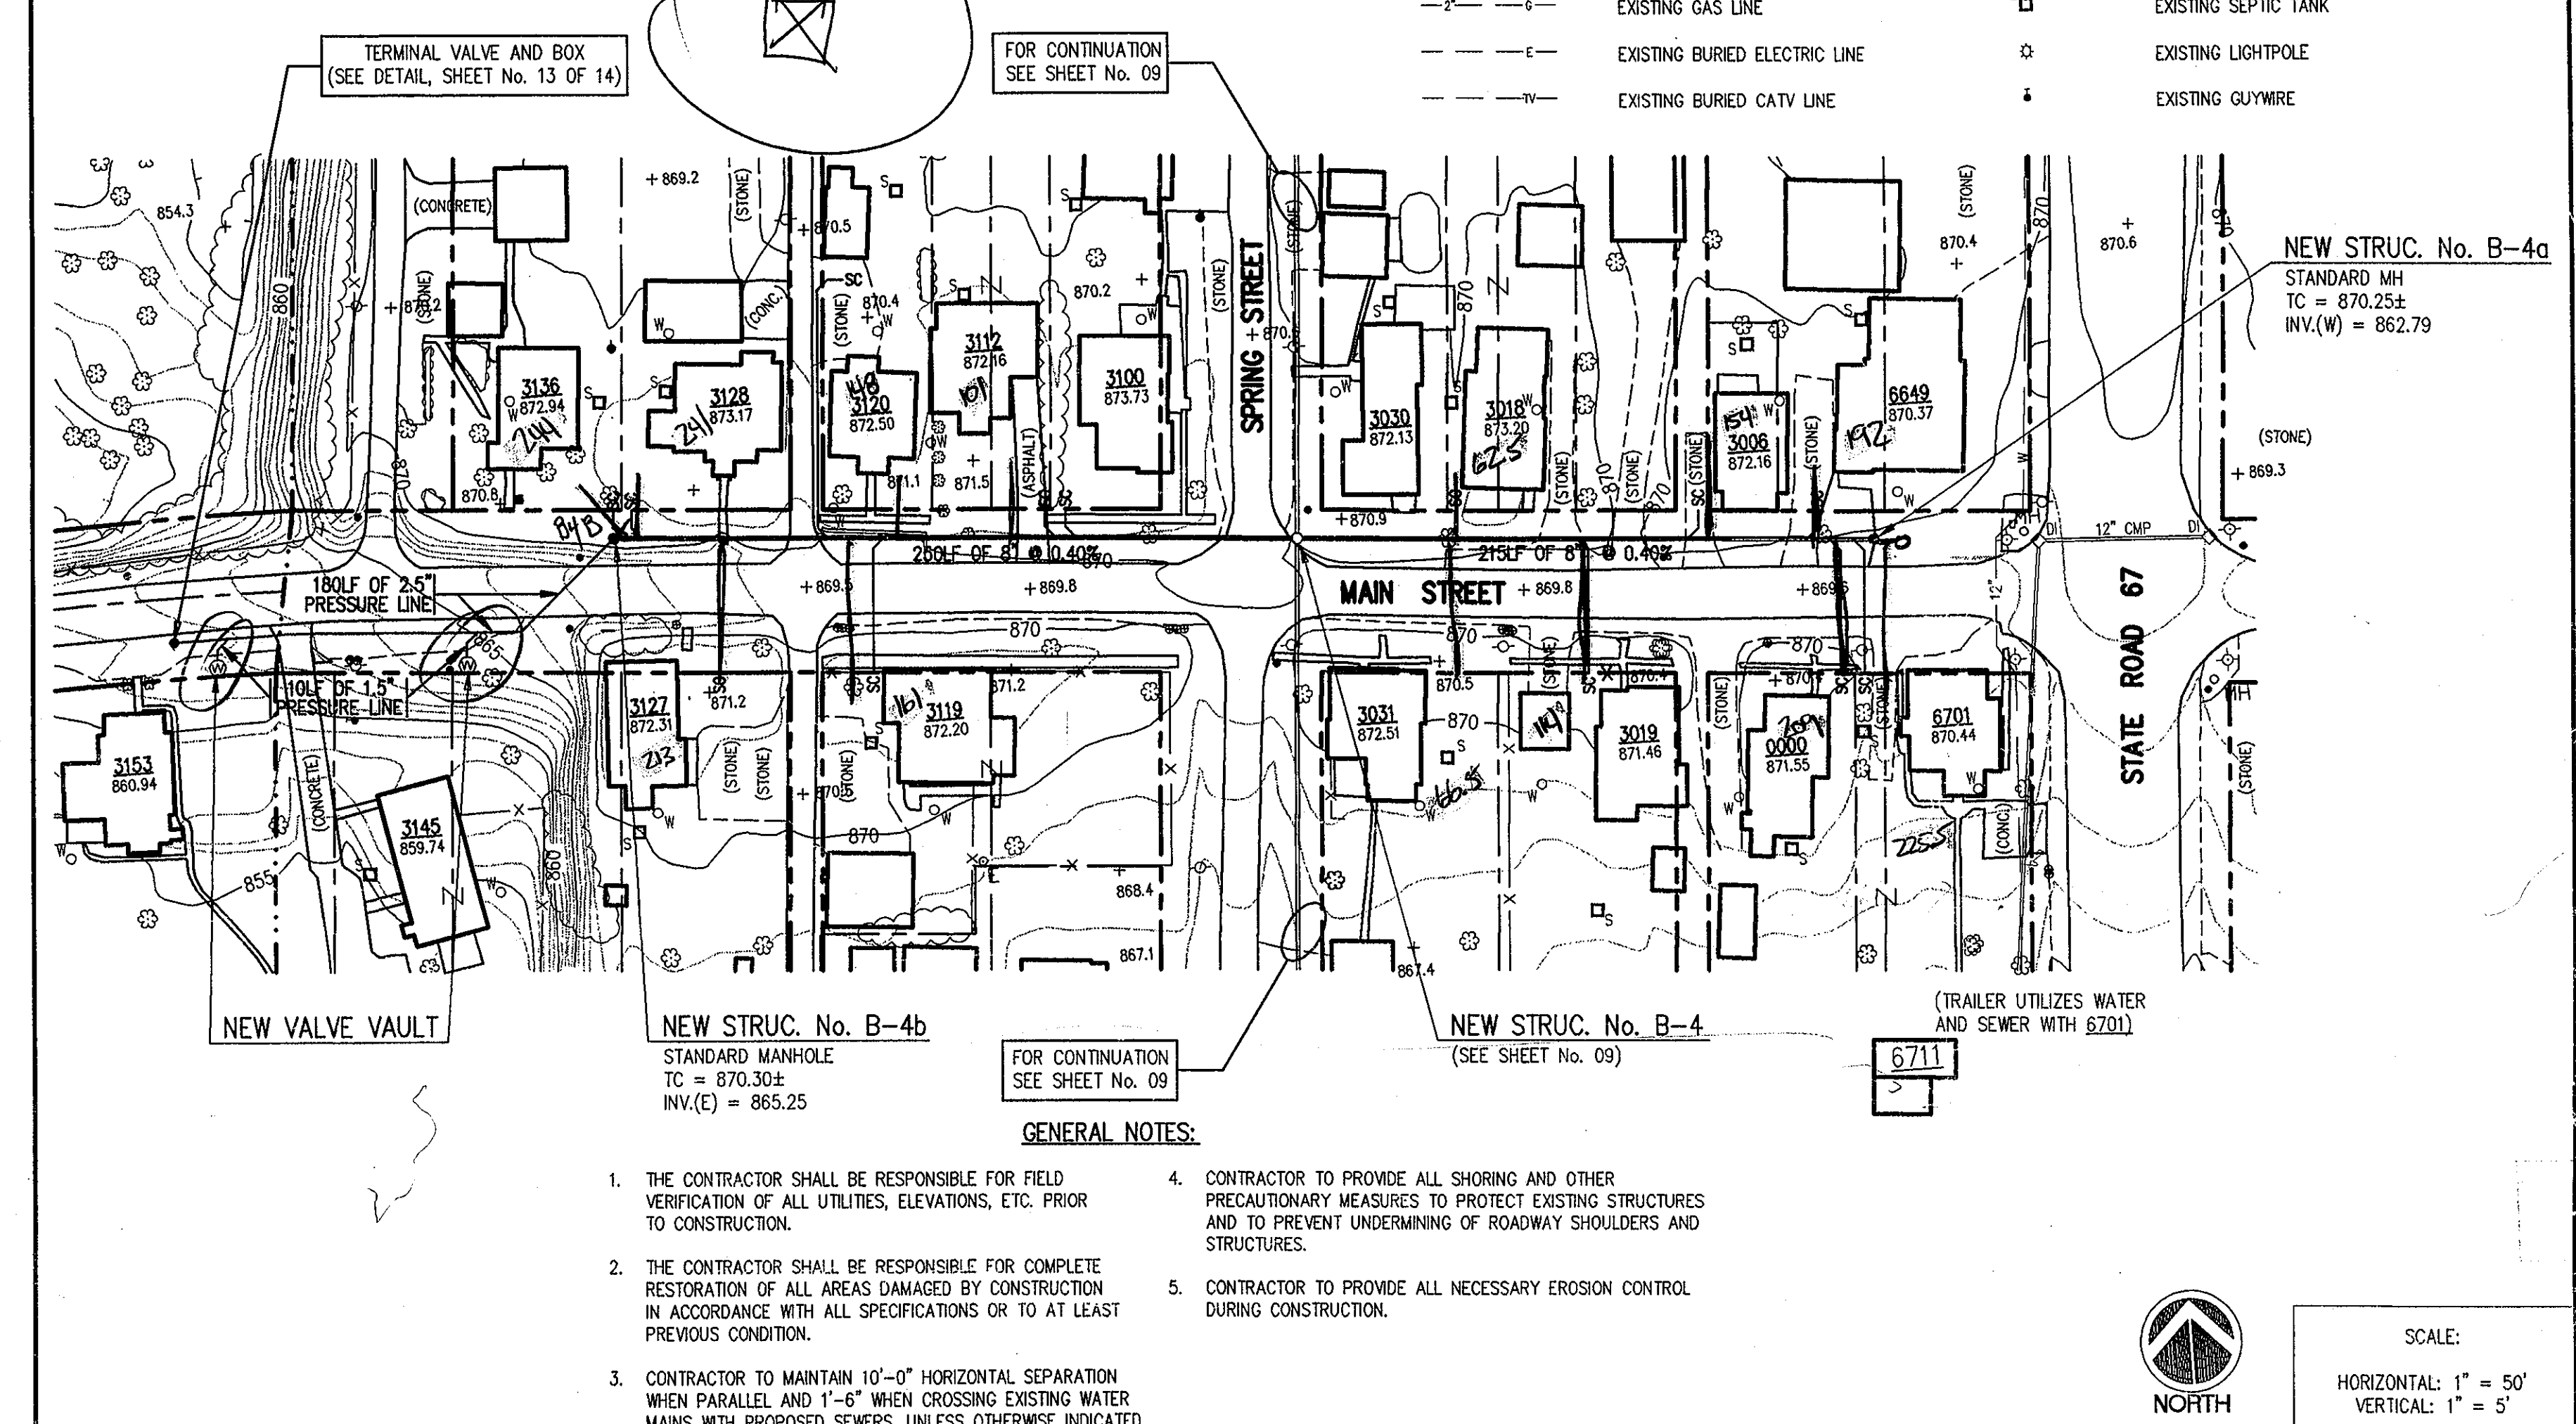


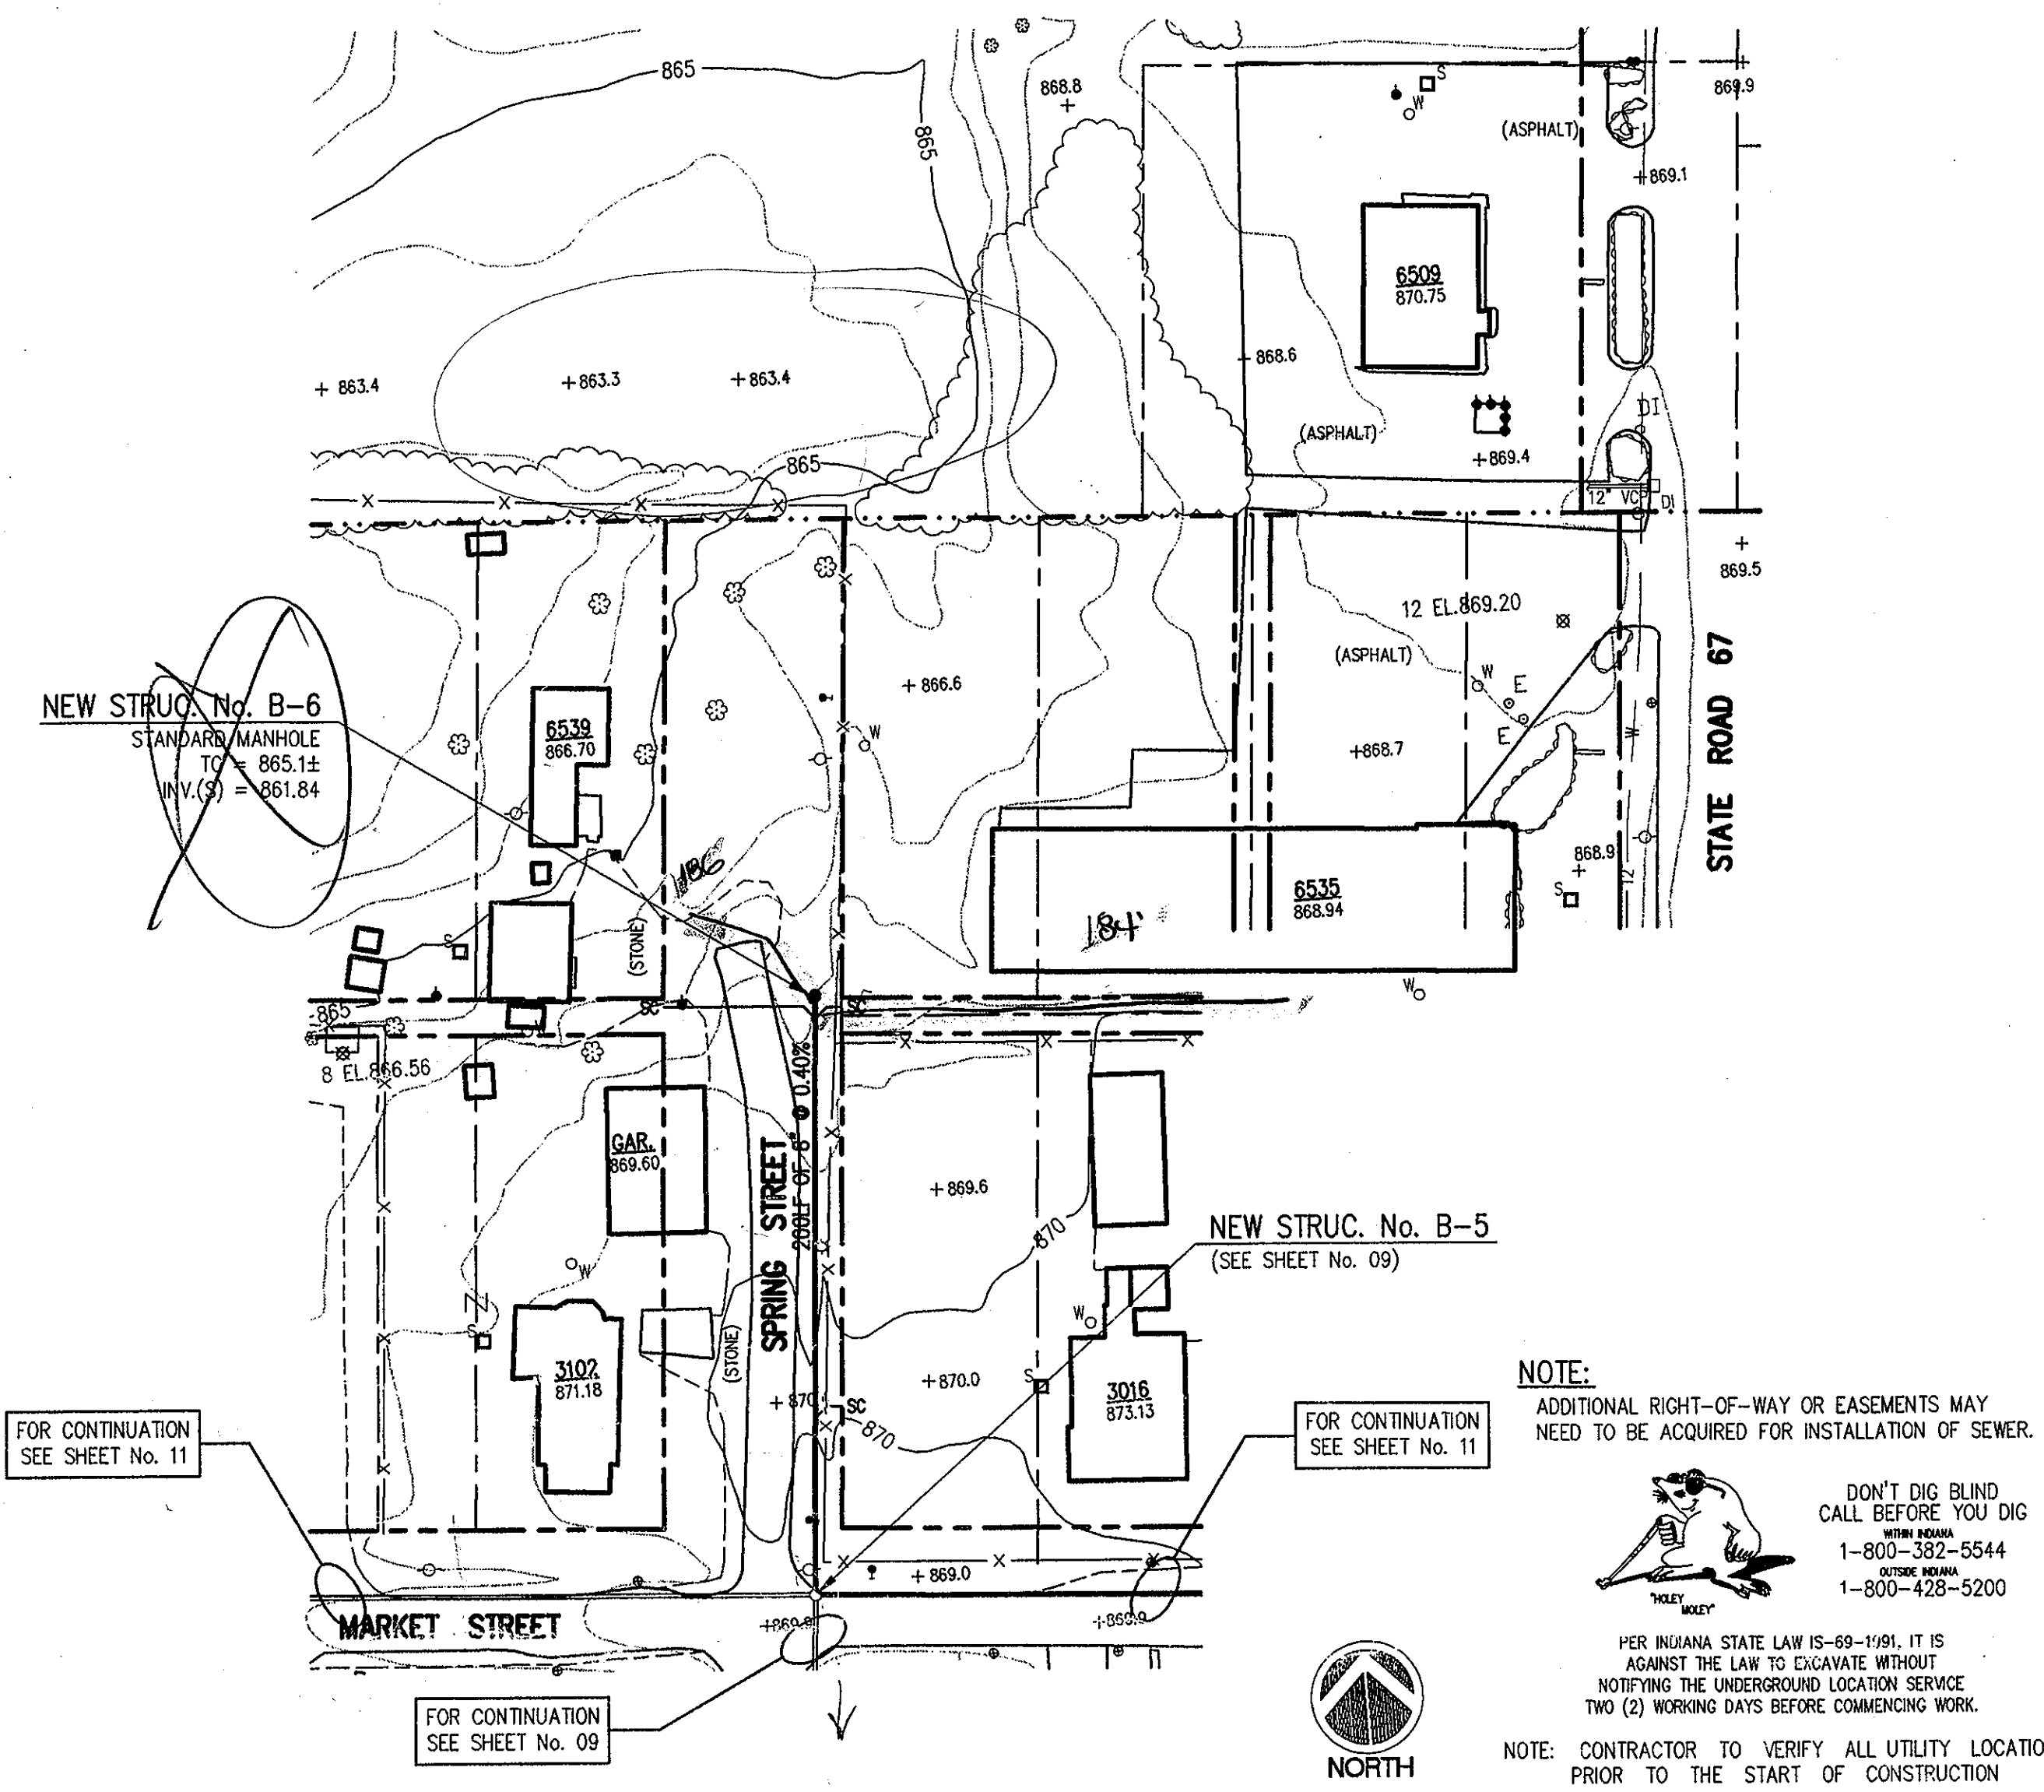

- LEGEND**
- PROPOSED GRAVITY SEWER LINE
 - PROPOSED SANITARY SEWER FORCEMAIN
 - PROPOSED SANITARY SEWER MANHOLE
 - PROPOSED SANITARY SERVICE CONNECTION
 - EXISTING WATERLINE
 - EXISTING GAS LINE
 - EXISTING BURIED ELECTRIC LINE
 - EXISTING BURIED CATV LINE
 - HUNTSVILLE AREA BOUNDARY
 - EXISTING MAILBOX
 - EXISTING LIGHTPOLE
 - EXISTING POWERPOLE
 - EXISTING WATER WELL
 - EXISTING SEPTIC TANK
 - EXISTING LIGHTPOLE
 - EXISTING GUYWIRE

- GENERAL NOTES:**
- THE CONTRACTOR SHALL BE RESPONSIBLE FOR FIELD VERIFICATION OF ALL UTILITIES, ELEVATIONS, ETC. PRIOR TO CONSTRUCTION.
 - THE CONTRACTOR SHALL BE RESPONSIBLE FOR COMPLETE RESTORATION OF ALL AREAS DAMAGED BY CONSTRUCTION IN ACCORDANCE WITH ALL SPECIFICATIONS OR TO AT LEAST PREVIOUS CONDITION.
 - CONTRACTOR TO MAINTAIN 10'-0" HORIZONTAL SEPARATION WHEN PARALLEL AND 1'-6" WHEN CROSSING EXISTING WATER MAINS WITH PROPOSED SEWERS, UNLESS OTHERWISE INDICATED.
 - CONTRACTOR TO PROVIDE ALL SHORING AND OTHER PRECAUTIONARY MEASURES TO PROTECT EXISTING STRUCTURES AND TO PREVENT UNDERMINING OF ROADWAY SHOULDERS AND STRUCTURES.
 - CONTRACTOR TO PROVIDE ALL NECESSARY EROSION CONTROL DURING CONSTRUCTION.

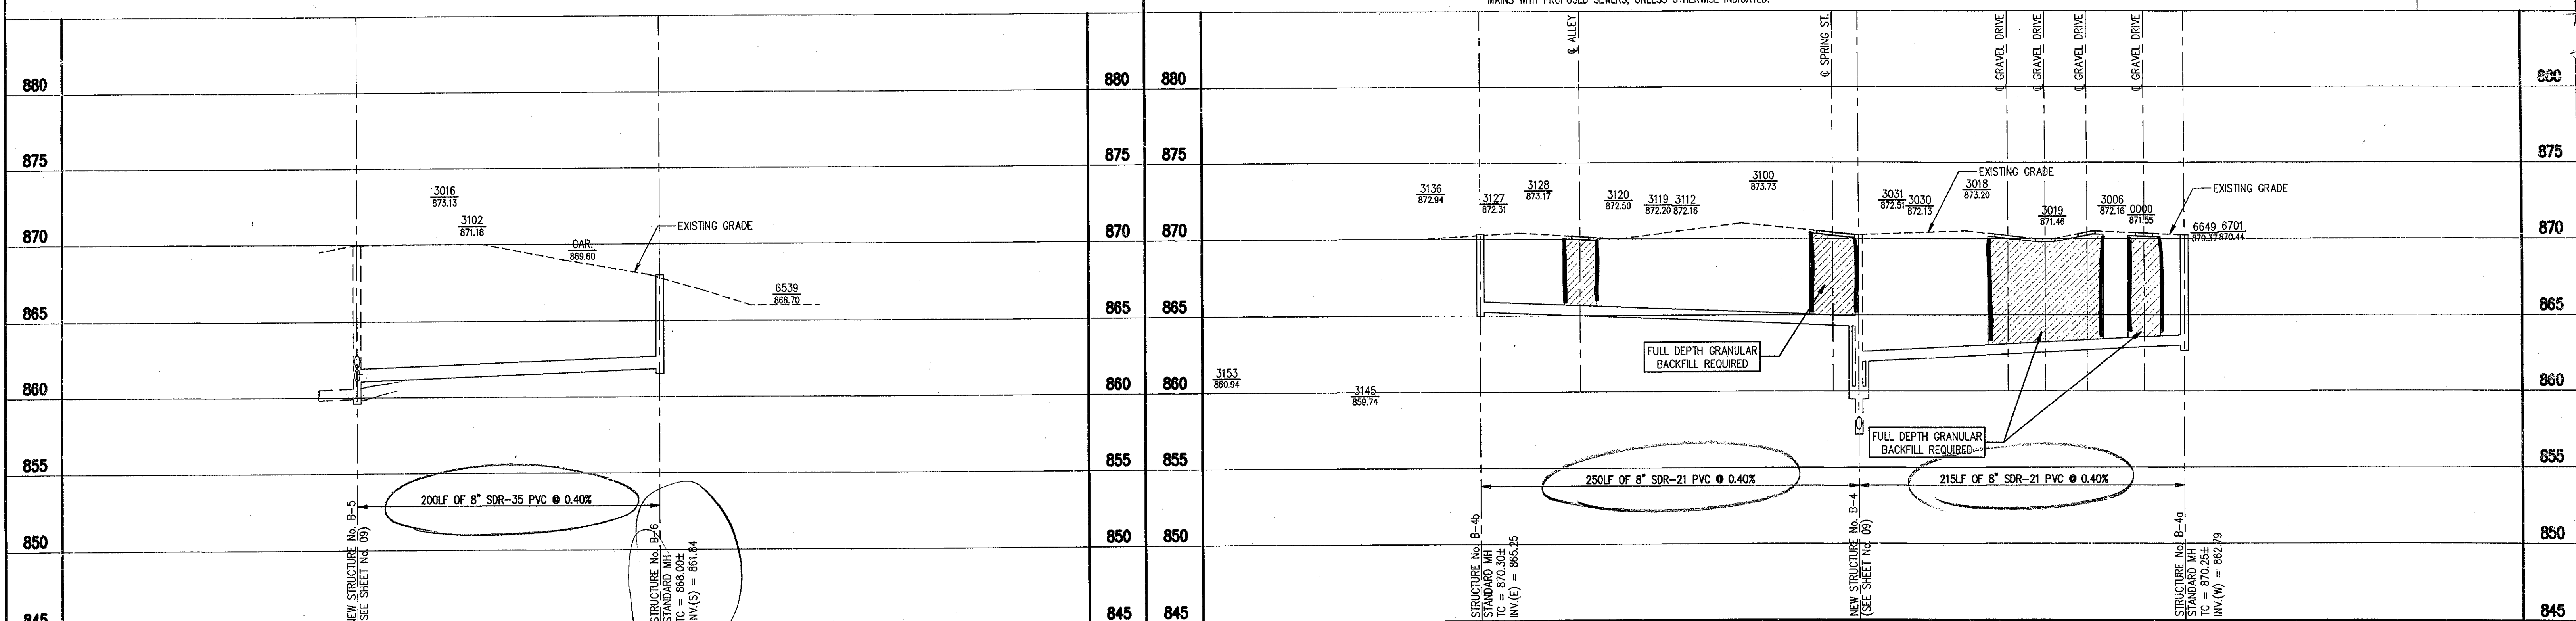

FILE NAME: 97003L07	PLOT SCALE: 1"=50'	PLOT DATE: 10/27
TRIAD ASSOCIATES INC. INDIANAPOLIS, INDIANA		
APPROVED: <i>Thomas M. Schmitt, P.E.</i> DESIGNED BY: <i>David Kieser, E.I.</i> CHECKED BY: <i>James W. Frazzli, P.E.</i>		
SANITARY SEWER AND FORCEMAIN PROJECT HUNTSVILLE, INDIANA LINE 'B' & LINE 'B-4' PLAN AND PROFILE DRAWN BY: DAP DATE: OCTOBER '97 SCALE: AS NOTED PROJECT No. 97003L SHEET No. 10		