


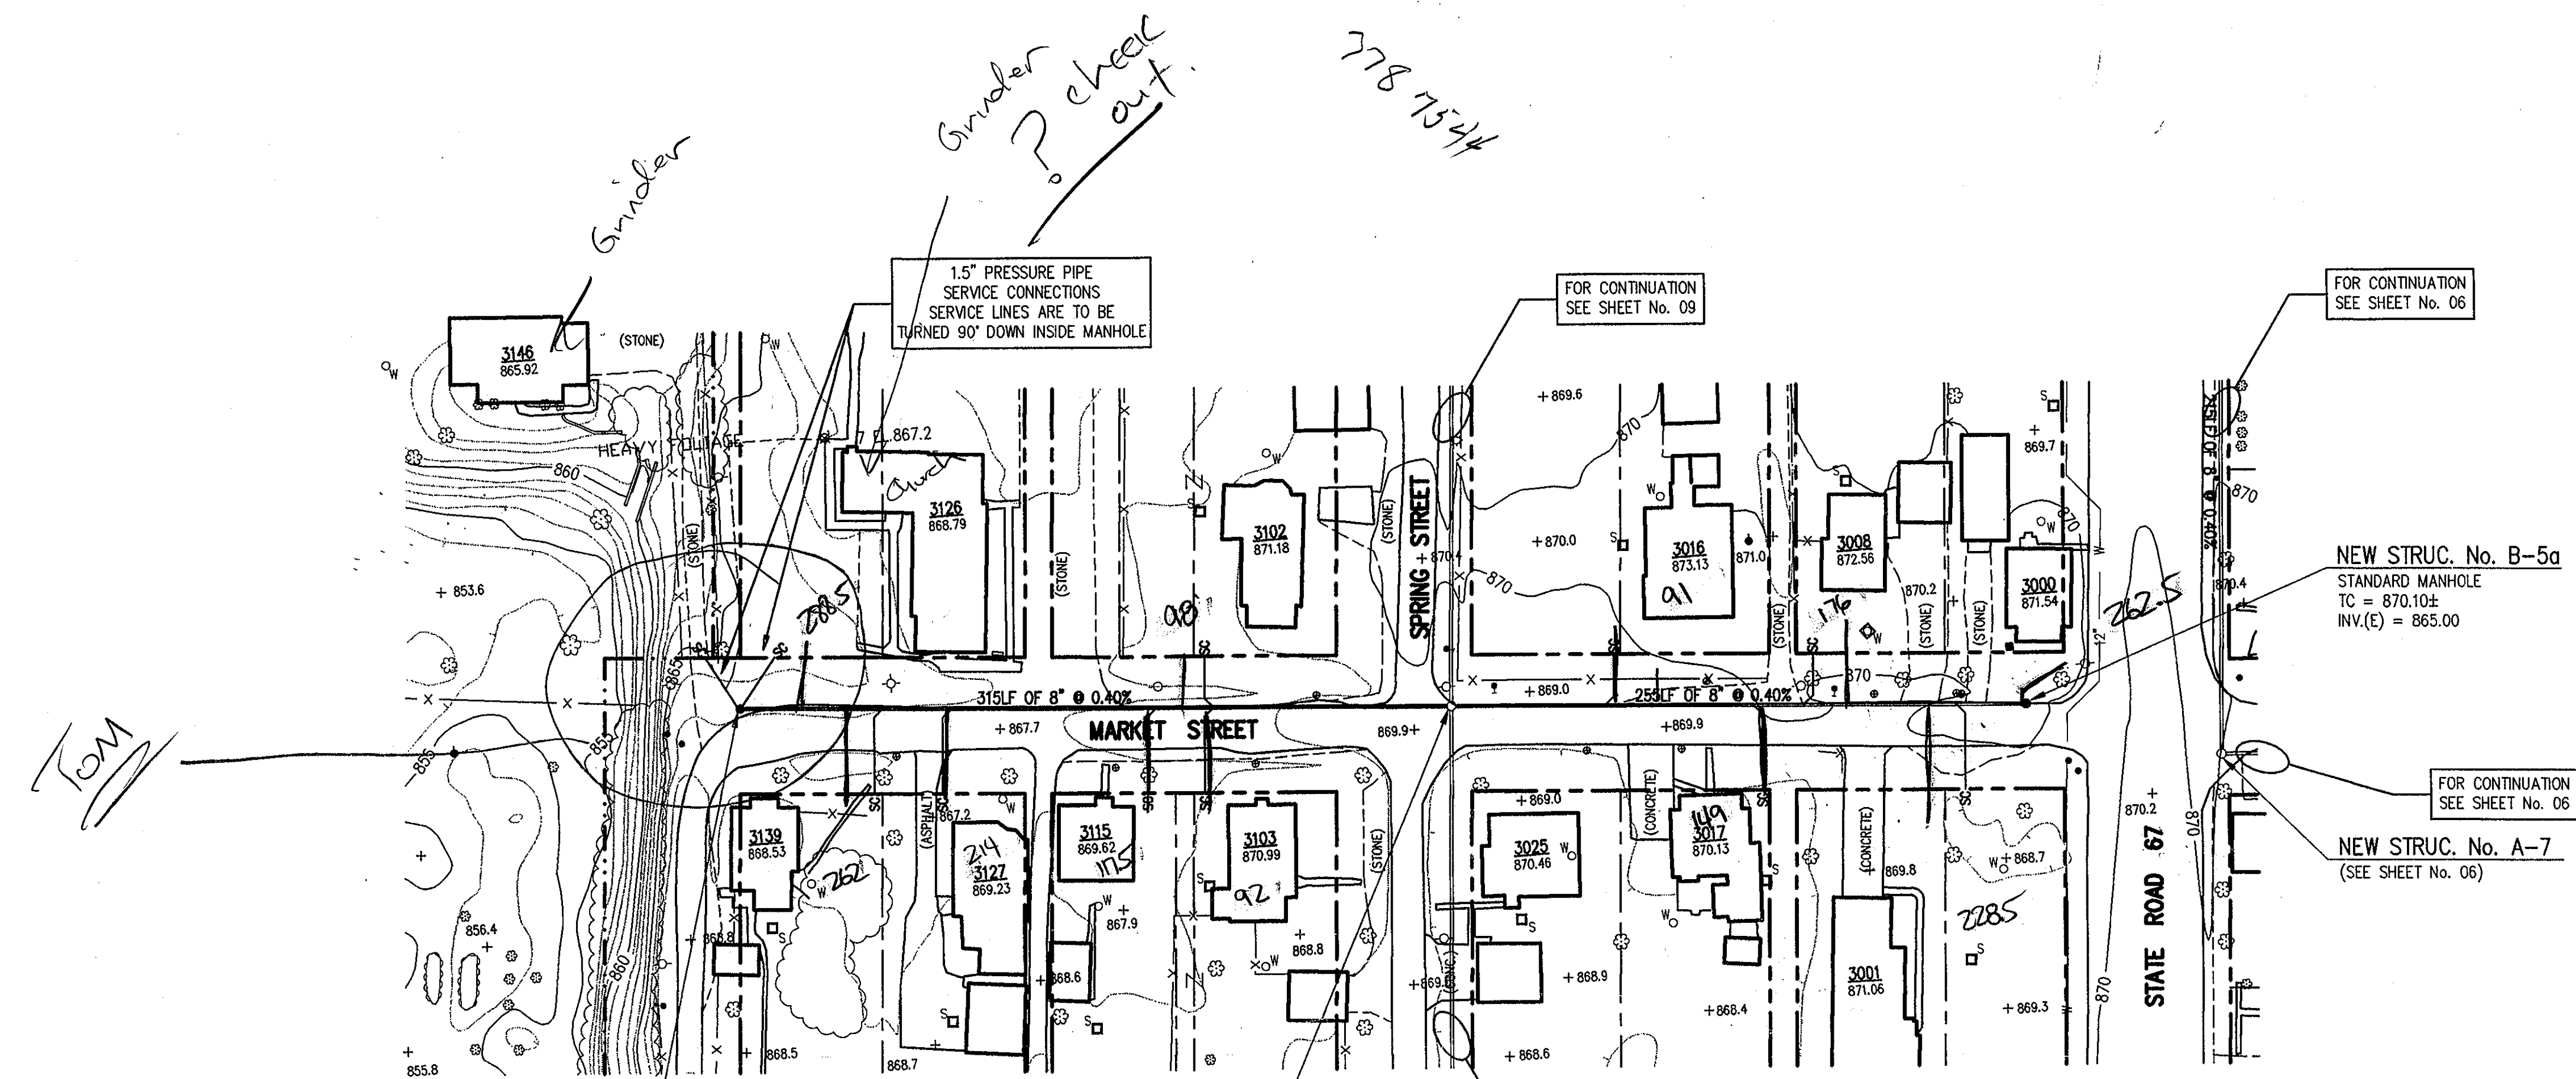

- LEGEND**
- PROPOSED GRAVITY SEWER LINE
  - - - PROPOSED SANITARY SEWER FORCEMAIN
  - PROPOSED SANITARY SEWER MANHOLE
  - SC — PROPOSED SANITARY SERVICE CONNECTION
  - - - EXISTING WATERLINE
  - - - EXISTING GAS LINE
  - - - EXISTING BURIED ELECTRIC LINE
  - - - EXISTING BURIED CATV LINE
  - - - HUNTSVILLE AREA BOUNDARY
  - EXISTING MAILBOX
  - ⊕ EXISTING LIGHTPOLE
  - ⊕ EXISTING POWERPOLE
  - W • EXISTING WATER WELL
  - EXISTING SEPTIC TANK
  - ⊕ EXISTING LIGHTPOLE
  - ⊕ EXISTING GUYWIRE

**NOTE:**  
ADDITIONAL RIGHT-OF-WAY OR EASEMENTS MAY  
NEED TO BE ACQUIRED FOR INSTALLATION OF SEWER.



PER INDIANA STATE LAW 15-69-1991, IT IS  
AGAINST THE LAW TO EXCAVATE WITHOUT  
NOTIFYING THE UNDERGROUND LOCATION SERVICE  
TWO (2) WORKING DAYS BEFORE COMMENCING WORK.


**NOTE:** CONTRACTOR TO VERIFY ALL UTILITY LOCATIONS  
PRIOR TO THE START OF CONSTRUCTION

**GENERAL NOTES:**

- THE CONTRACTOR SHALL BE RESPONSIBLE FOR FIELD VERIFICATION OF ALL UTILITIES, ELEVATIONS, ETC. PRIOR TO CONSTRUCTION.
- THE CONTRACTOR SHALL BE RESPONSIBLE FOR COMPLETE RESTORATION OF ALL AREAS DAMAGED BY CONSTRUCTION IN ACCORDANCE WITH ALL SPECIFICATIONS OR TO AT LEAST PREVIOUS CONDITION.
- CONTRACTOR TO MAINTAIN 10'-0" HORIZONTAL SEPARATION WHEN PARALLEL AND 1'-6" WHEN CROSSING EXISTING WATER MAINS WITH PROPOSED SEWERS, UNLESS OTHERWISE INDICATED.
- CONTRACTOR TO PROVIDE ALL SHORING AND OTHER PRECAUTIONARY MEASURES TO PROTECT EXISTING STRUCTURES AND TO PREVENT UNDERMINING OF ROADWAY SHOULDERS AND STRUCTURES.
- CONTRACTOR TO PROVIDE ALL NECESSARY EROSION CONTROL DURING CONSTRUCTION.



**SCALE:**  
HORIZONTAL: 1" = 50'  
VERTICAL: 1" = 5'

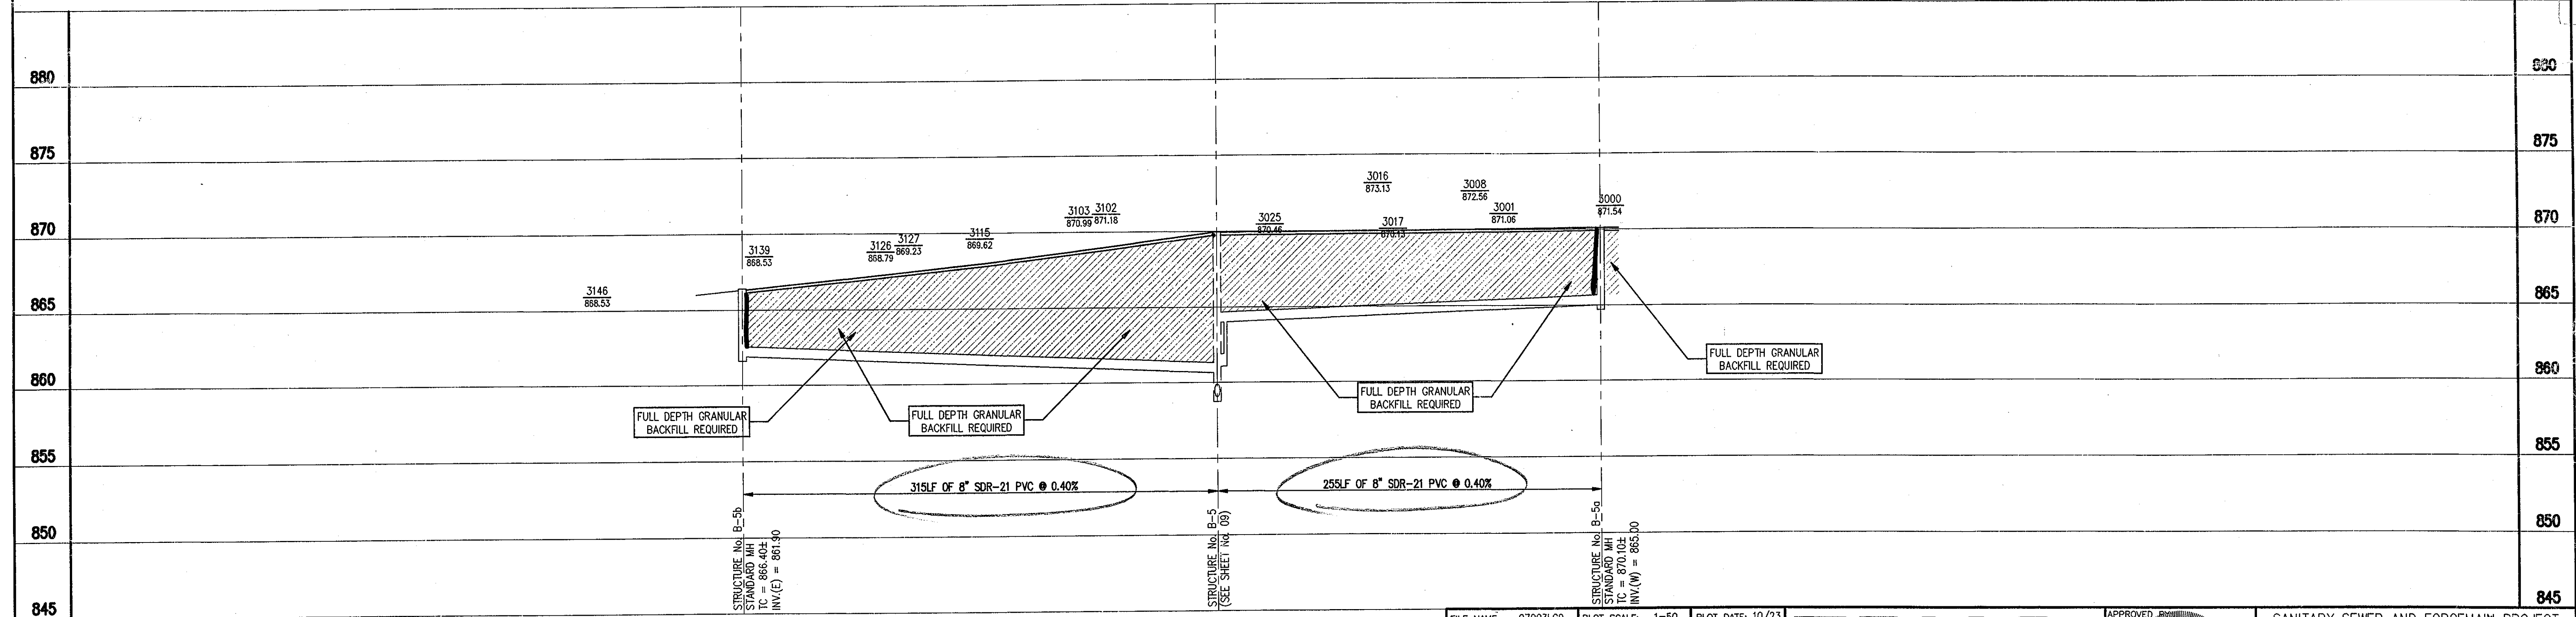

FILE NAME: 97003LC9 PLOT SCALE: 1"=50' PLOT DATE: 10/23

**TRIAD ASSOCIATES INC.**  
INDIANAPOLIS, INDIANA

APPROVED:   
Thomas M. Schubert, P.E.

**SANITARY SEWER AND FORCEMAIN PROJECT HUNTSVILLE, INDIANA**  
**LINE 'B-5' PLAN AND PROFILE**  
DRAWN BY: DAP DATE: OCTOBER '97 PROJECT No.: 97003LC SHEET No.: 11  
SCALE: AS NOTED  
DESIGNED BY: David Kieser, E.I.  
CHECKED BY: James W. Frazell, P.E.