
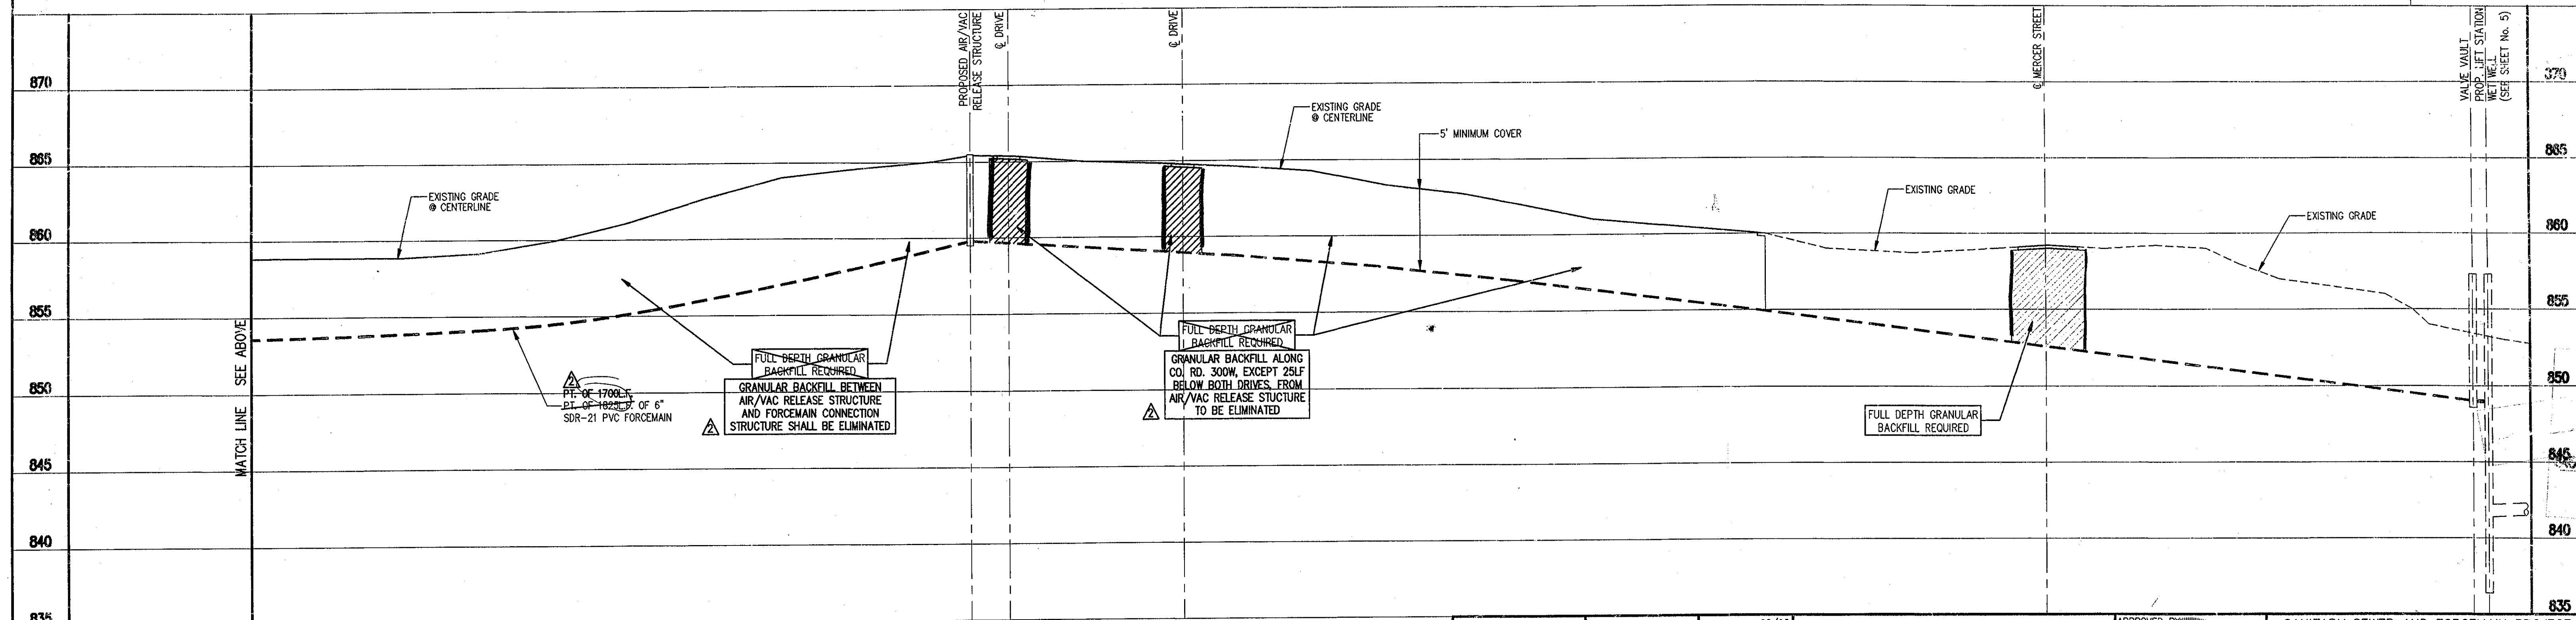


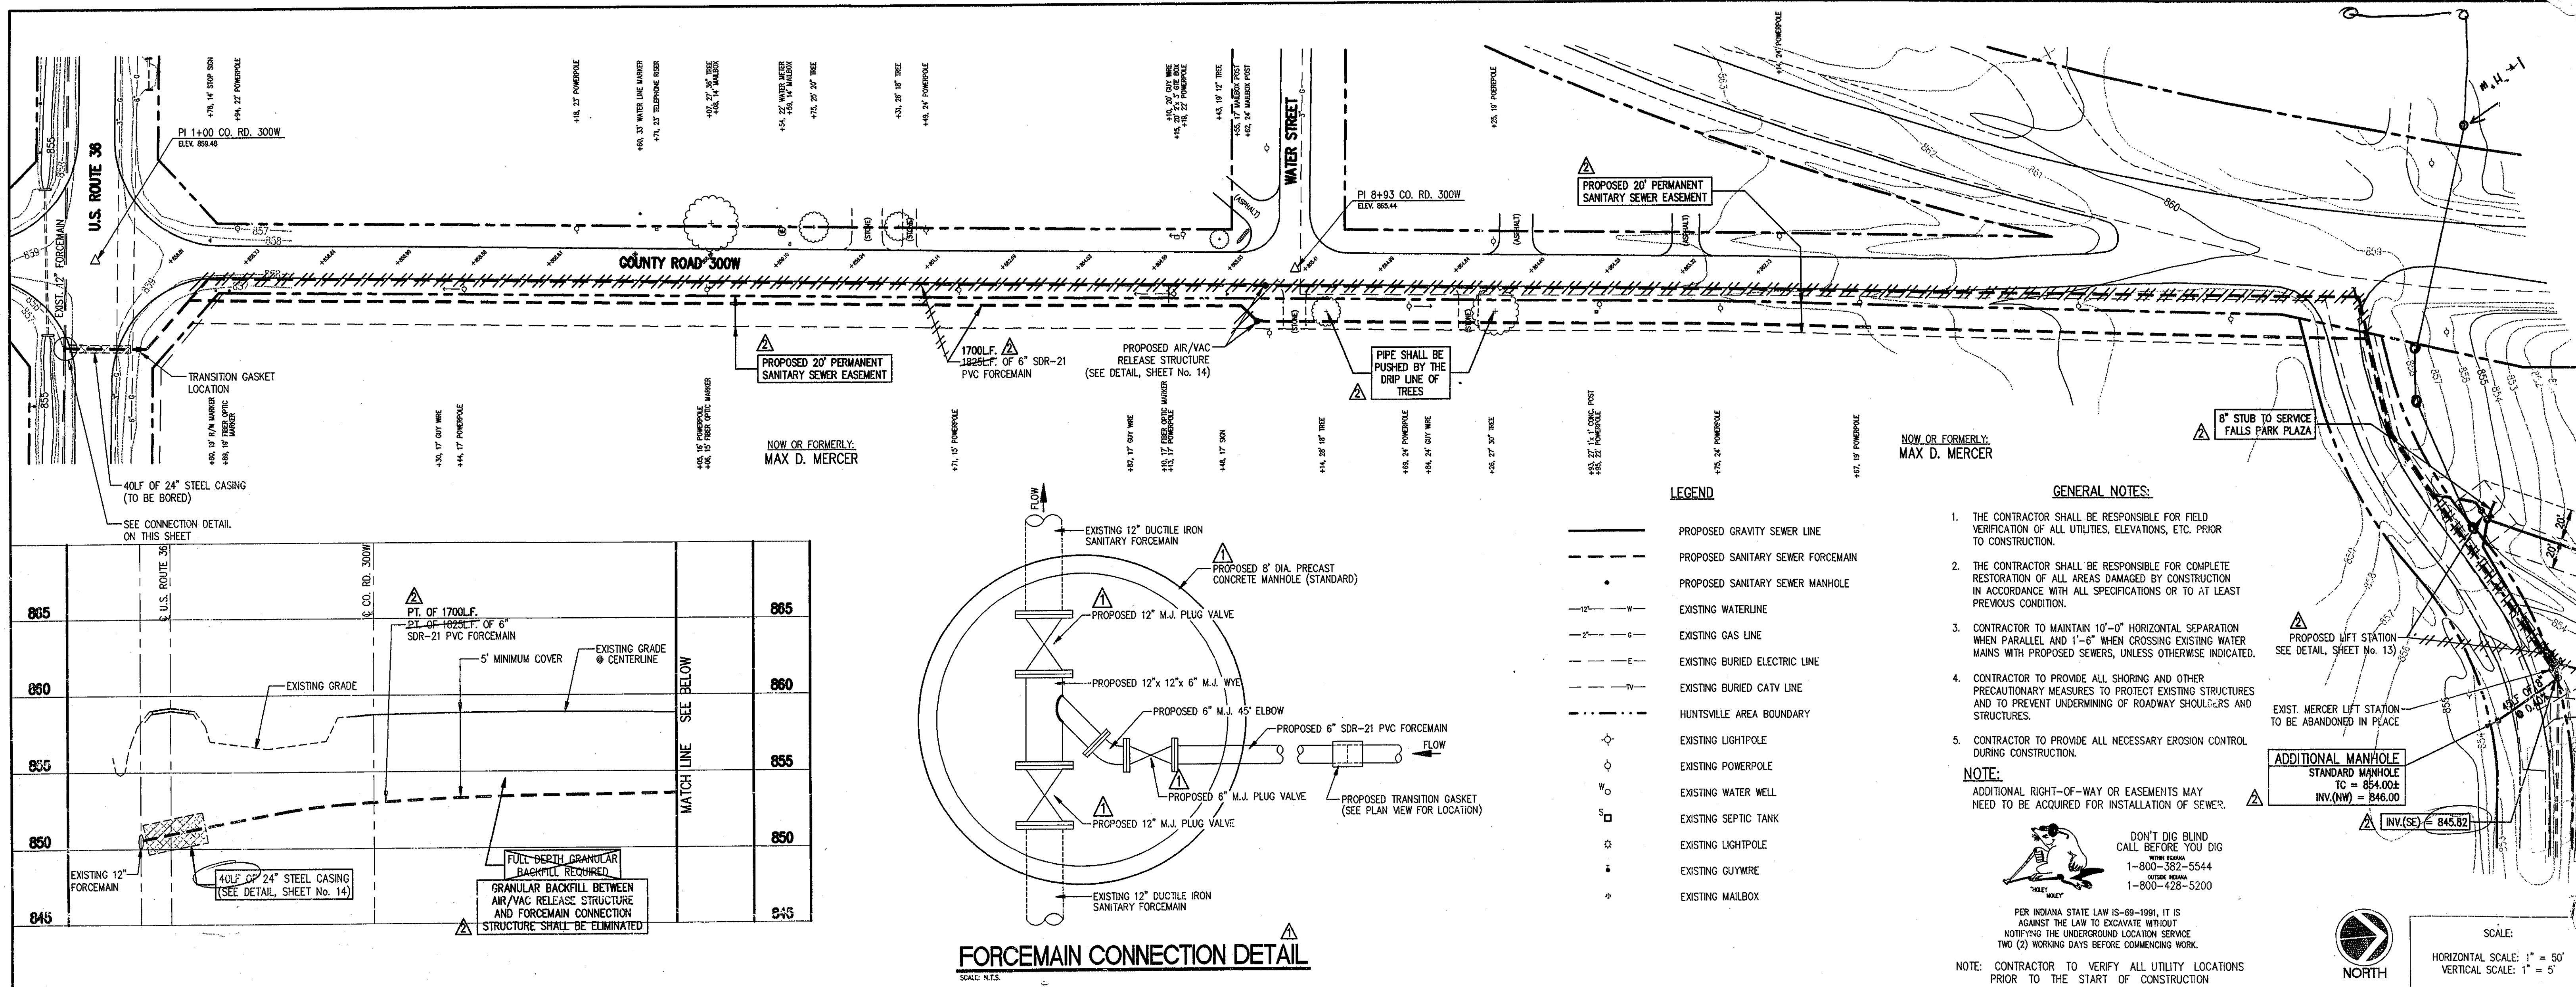

LEGEND

- PROPOSED GRAVITY SEWER LINE
- PROPOSED SANITARY SEWER FORCEMAIN
- PROPOSED SANITARY SEWER MANHOLE
- EXISTING WATERLINE
- EXISTING GAS LINE
- EXISTING BURIED ELECTRIC LINE
- EXISTING BURIED CATV LINE
- HUNTSVILLE AREA BOUNDARY
- EXISTING LIGHTPOLE
- EXISTING POWERPOLE
- EXISTING WATER WELL
- EXISTING SEPTIC TANK
- EXISTING LIGHTPOLE
- EXISTING GUYWIRE
- EXISTING MAILBOX

GENERAL NOTES:

- THE CONTRACTOR SHALL BE RESPONSIBLE FOR FIELD VERIFICATION OF ALL UTILITIES, ELEVATIONS, ETC. PRIOR TO CONSTRUCTION.
- THE CONTRACTOR SHALL BE RESPONSIBLE FOR COMPLETE RESTORATION OF ALL AREAS DAMAGED BY CONSTRUCTION IN ACCORDANCE WITH ALL SPECIFICATIONS OR TO AT LEAST PREVIOUS CONDITION.
- CONTRACTOR TO MAINTAIN 10'-0" HORIZONTAL SEPARATION WHEN PARALLEL AND 1'-6" WHEN CROSSING EXISTING WATER MAINS WITH PROPOSED SEWERS, UNLESS OTHERWISE INDICATED.
- CONTRACTOR TO PROVIDE ALL SHORING AND OTHER PRECAUTIONARY MEASURES TO PROTECT EXISTING STRUCTURES AND TO PREVENT UNDERMINING OF ROADWAY SHOULDERS AND STRUCTURES.
- CONTRACTOR TO PROVIDE ALL NECESSARY EROSION CONTROL DURING CONSTRUCTION.

NOTE:

ADDITIONAL RIGHT-OF-WAY OR EASEMENTS MAY NEED TO BE ACQUIRED FOR INSTALLATION OF SEWER.



DON'T DIG BLIND
CALL BEFORE YOU DIG
TOLL FREE
1-800-382-5544
HUNTSVILLE
1-800-428-5200


PER INDIANA STATE LAW IS-89-1991, IT IS AGAINST THE LAW TO EXCAVATE WITHOUT NOTIFYING THE UNDERGROUND LOCATION SERVICE TWO (2) WORKING DAYS BEFORE COMMENCING WORK.



SCALE:
HORIZONTAL SCALE: 1" = 50'
VERTICAL SCALE: 1" = 5'

FILE NAME:	97003LC1	PLOT SCALE:	1"=50'	PLOT DATE:	02/05
DATE	11/07/97	REVISION	REVISED AS PER ADDENDUM No.1	BY	D.A.P.
DATE	01/27/98	REVISION	REVISED AS PER MEETING w/ OWNER	BY	D.A.P.
NO.	DATE	DESCRIPTION	BY	INDIANAPOLIS, INDIANA	

TRIAD ASSOCIATES INC.
INDIANAPOLIS, INDIANA

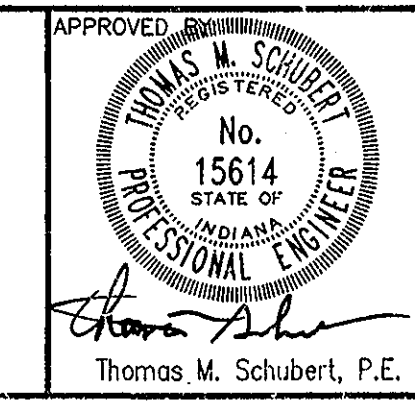

SANITARY SEWER AND FORCEMAIN PROJECT HUNTSVILLE, INDIANA			
FORCEMAIN PLAN & PROFILE			
DRAWN BY:	DATE	PROJECT No.	SHEET No.
DAP	OCTOBER '97	97003LC1	4
DESIGNED BY:	SCALE	AS NOTED	
David Kieser, E.I.			
CHECKED BY:			
James W. Frazell, P.E.			