

NEW STRUC. No. A-7
STANDARD MANHOLE
TC = 870.00±
INV.(N) = 861.82
INV.(E) = 861.80

NEW STRUC. No. A-8
STANDARD MANHOLE
TC = 869.50±
INV.(N) = 862.70
INV.(S) = 862.68

NEW STRUC. No. A-9
STANDARD MANHOLE
TC = 868.20±
INV.(S) = 863.84

NEW STRUC. No. A-6
(SEE SHEET No. 05)

NEW STRUC. No. A-5
(SEE SHEET No. 05)

NEW STRUC. No. A-5a
STANDARD MANHOLE
TC = 870.10±
INV.(W) = 862.00
INV.(E) = 861.98

NEW STRUC. No. A-5b
STANDARD MANHOLE
TC = 869.20±
INV.(E) = 863.20

GENERAL NOTES:

1. THE CONTRACTOR SHALL BE RESPONSIBLE FOR FIELD VERIFICATION OF ALL UTILITIES, ELEVATIONS, ETC. PRIOR TO CONSTRUCTION.
2. THE CONTRACTOR SHALL BE RESPONSIBLE FOR COMPLETE RESTORATION OF ALL AREAS DAMAGED BY CONSTRUCTION IN ACCORDANCE WITH ALL SPECIFICATIONS OR TO AT LEAST PREVIOUS CONDITION.
3. CONTRACTOR TO MAINTAIN 10'-0" HORIZONTAL SEPARATION WHEN PARALLEL AND 1'-6" WHEN CROSSING EXISTING WATER MAINS WITH PROPOSED SEWERS, UNLESS OTHERWISE INDICATED.
4. CONTRACTOR TO PROVIDE ALL SHORING AND OTHER PRECAUTIONARY MEASURES TO PROTECT EXISTING STRUCTURES AND TO PREVENT UNDERMINING OF ROADWAY SHOULDERS AND STRUCTURES.
5. CONTRACTOR TO PROVIDE ALL NECESSARY EROSION CONTROL DURING CONSTRUCTION.

LEGEND

PROPOSED GRAVITY SEWER LINE	--- --	HUNTSVILLE AREA BOUNDARY
PROPOSED SANITARY SEWER FORCEMAIN	---	EXISTING MAILBOX
PROPOSED SANITARY SEWER MANHOLE	○	EXISTING LIGHTPOLE
PROPOSED SANITARY SERVICE CONNECTION	○	EXISTING POWERPOLE
EXISTING WATERLINE	W	EXISTING WATER WELL
EXISTING GAS LINE	G	EXISTING SEPTIC TANK
EXISTING BURIED ELECTRIC LINE	E	EXISTING LIGHTPOLE
EXISTING BURIED CATV LINE	C	EXISTING GUYWIRE

NOTE:

ADDITIONAL RIGHT-OF-WAY OR EASEMENTS MAY NEED TO BE ACQUIRED FOR INSTALLATION OF SEWER.




DON'T DIG BLIND
CALL BEFORE YOU DIG
UTILITY LOCATIONS
1-800-382-5544
1-800-428-5200

PER INDIANA STATE LAW IS-69-1991, IT IS AGAINST THE LAW TO EXCAVATE WITHOUT NOTIFYING THE UNDERGROUND LOCATION SERVICE TWO (2) WORKING DAYS BEFORE COMMENCING WORK.

NOTE: CONTRACTOR TO VERIFY ALL UTILITY LOCATIONS PRIOR TO THE START OF CONSTRUCTION




SCALE:
HORIZONTAL: 1" = 50'
VERTICAL: 1" = 5'

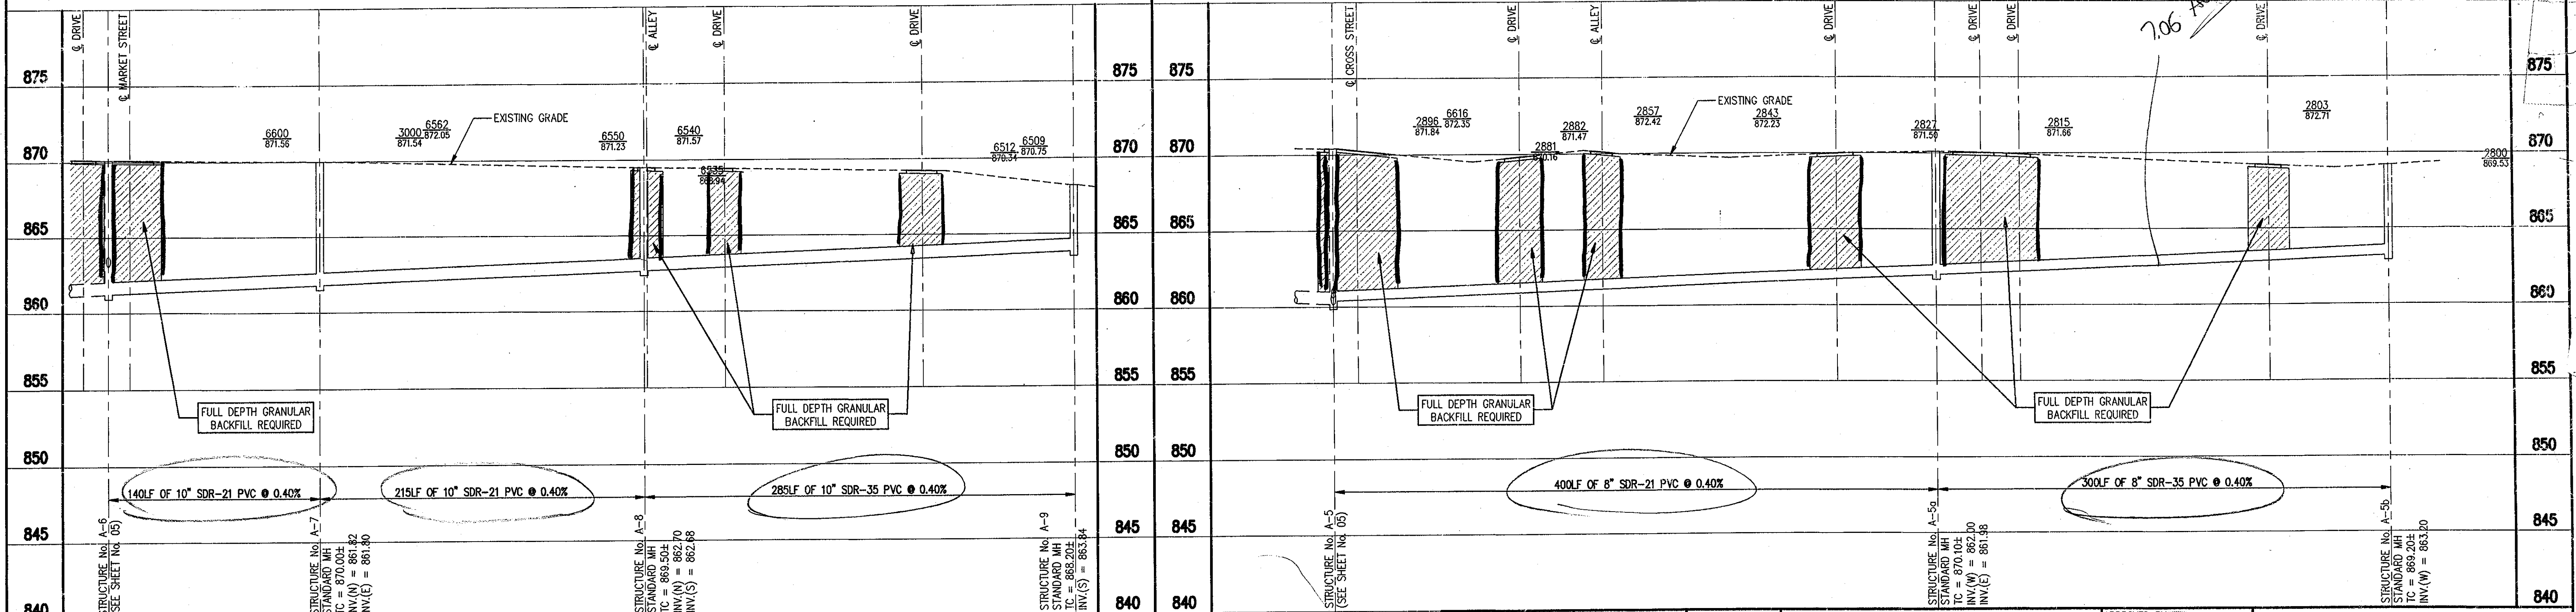

FILE NAME: 97003LC3 PLOT SCALE: 1=50 PLOT DATE: 10/23

NO.	DATE	DESCRIPTION	BY

TRIAD ASSOCIATES INC.
INDIANAPOLIS, INDIANA

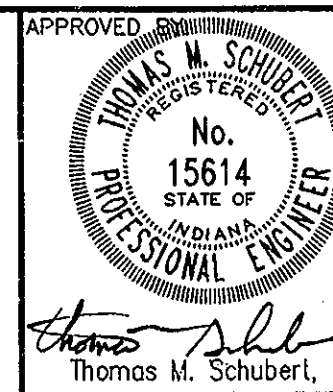

SANITARY SEWER AND FORCEMAIN PROJECT
HUNTSVILLE, INDIANA
LINE 'A' & LINE 'A-5'
PLAN AND PROFILE
DRAWN BY: DAP DATE: OCTOBER '97 PROJECT No. 97003L SHEET No. 6
DESIGNED BY: David Kisser, E.I.
CHECKED BY: James W. Frazell, P.E.