
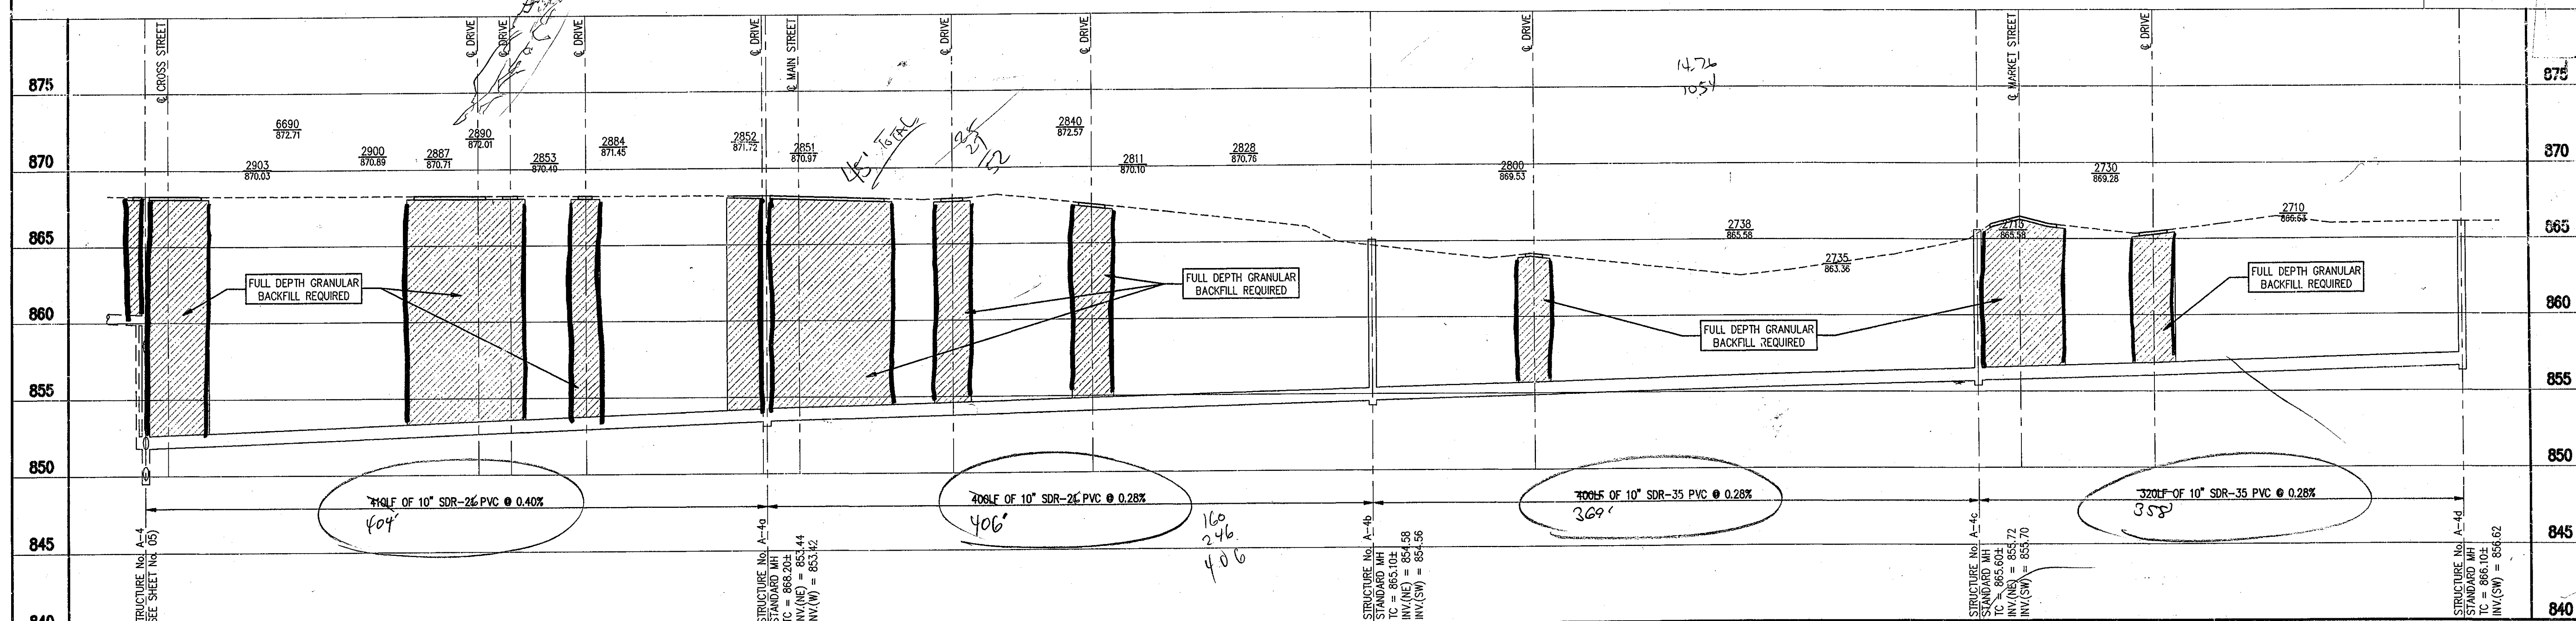


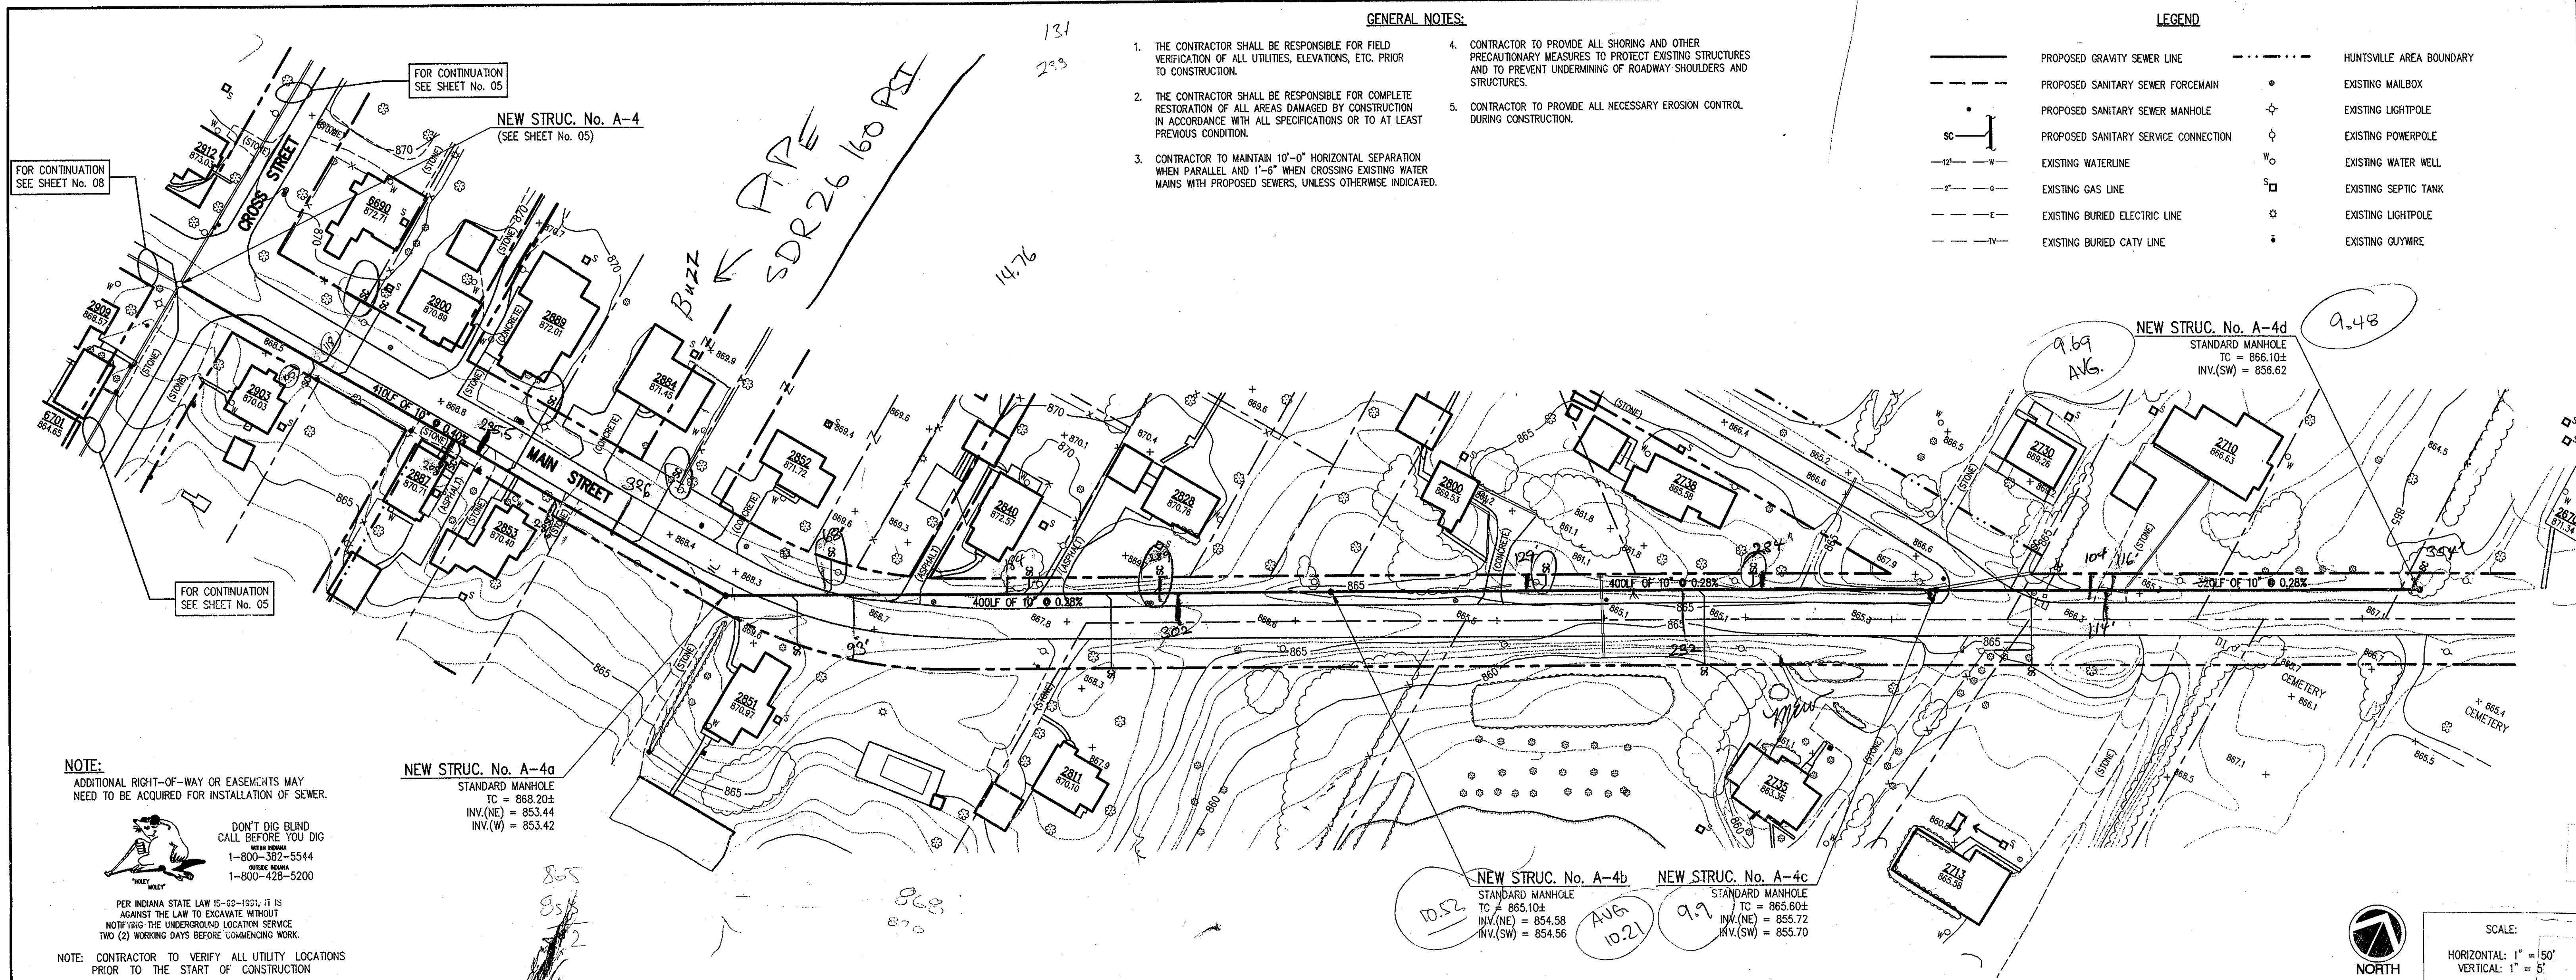

FILE NAME: 97003LC4	PLOT SCALE: 1"=50'	PLOT DATE: 10/23	TRIAD ASSOCIATES INC. INDIANAPOLIS, INDIANA		SANITARY SEWER AND FORCEMAIN PROJECT HUNTSVILLE, INDIANA	
LINE 'A-4'		PROJECT No. 97003LC			SHEET No. 7	
PLAN AND PROFILE		DESIGNED BY: David Kieser, E.I.			CHECKED BY: James W. Frozell, P.E.	
DRAWN BY: DAP		DATE: OCTOBER '97			SCALE: AS NOTED	