

1. THE CONTRACTOR SHALL BE RESPONSIBLE FOR FIELD VERIFICATION OF ALL UTILITIES, ELEVATIONS, ETC. PRIOR TO CONSTRUCTION.
2. THE CONTRACTOR SHALL BE RESPONSIBLE FOR COMPLETE RESTORATION OF ALL AREAS DAMAGED BY CONSTRUCTION IN ACCORDANCE WITH ALL SPECIFICATIONS OR TO AT LEAST PREVIOUS CONDITION.
3. CONTRACTOR TO MAINTAIN 10'-0" HORIZONTAL SEPARATION WHEN PARALLEL AND 1'-6" WHEN CROSSING EXISTING WATER MAINS WITH PROPOSED SEWERS, UNLESS OTHERWISE INDICATED.
4. CONTRACTOR TO PROVIDE ALL SHORING AND OTHER PRECAUTIONARY MEASURES TO PROTECT EXISTING STRUCTURES AND TO PREVENT UNDERMINING OF ROADWAY SHOULDERS AND STRUCTURES.
5. CONTRACTOR TO PROVIDE ALL NECESSARY EROSION CONTROL DURING CONSTRUCTION.






NOTE:
ADDITIONAL RIGHT-OF-WAY OR EASEMENTS MAY
NEED TO BE ACQUIRED FOR INSTALLATION OF SEWER.



DON'T DIG BLIND
CALL BEFORE YOU DIG
WITHIN INDIANA
1-800-382-5544
OUTSIDE INDIANA
1-800-428-5200

PER INDIANA STATE LAW IS-69-1991, IT IS AGAINST THE LAW TO EXCAVATE WITHOUT NOTIFYING THE UNDERGROUND LOCATION SERVICE TWO (2) WORKING DAYS BEFORE COMMENCING WORK.


NOTE: CONTRACTOR TO VERIFY ALL UTILITY LOCATIONS
PRIOR TO THE START OF CONSTRUCTION

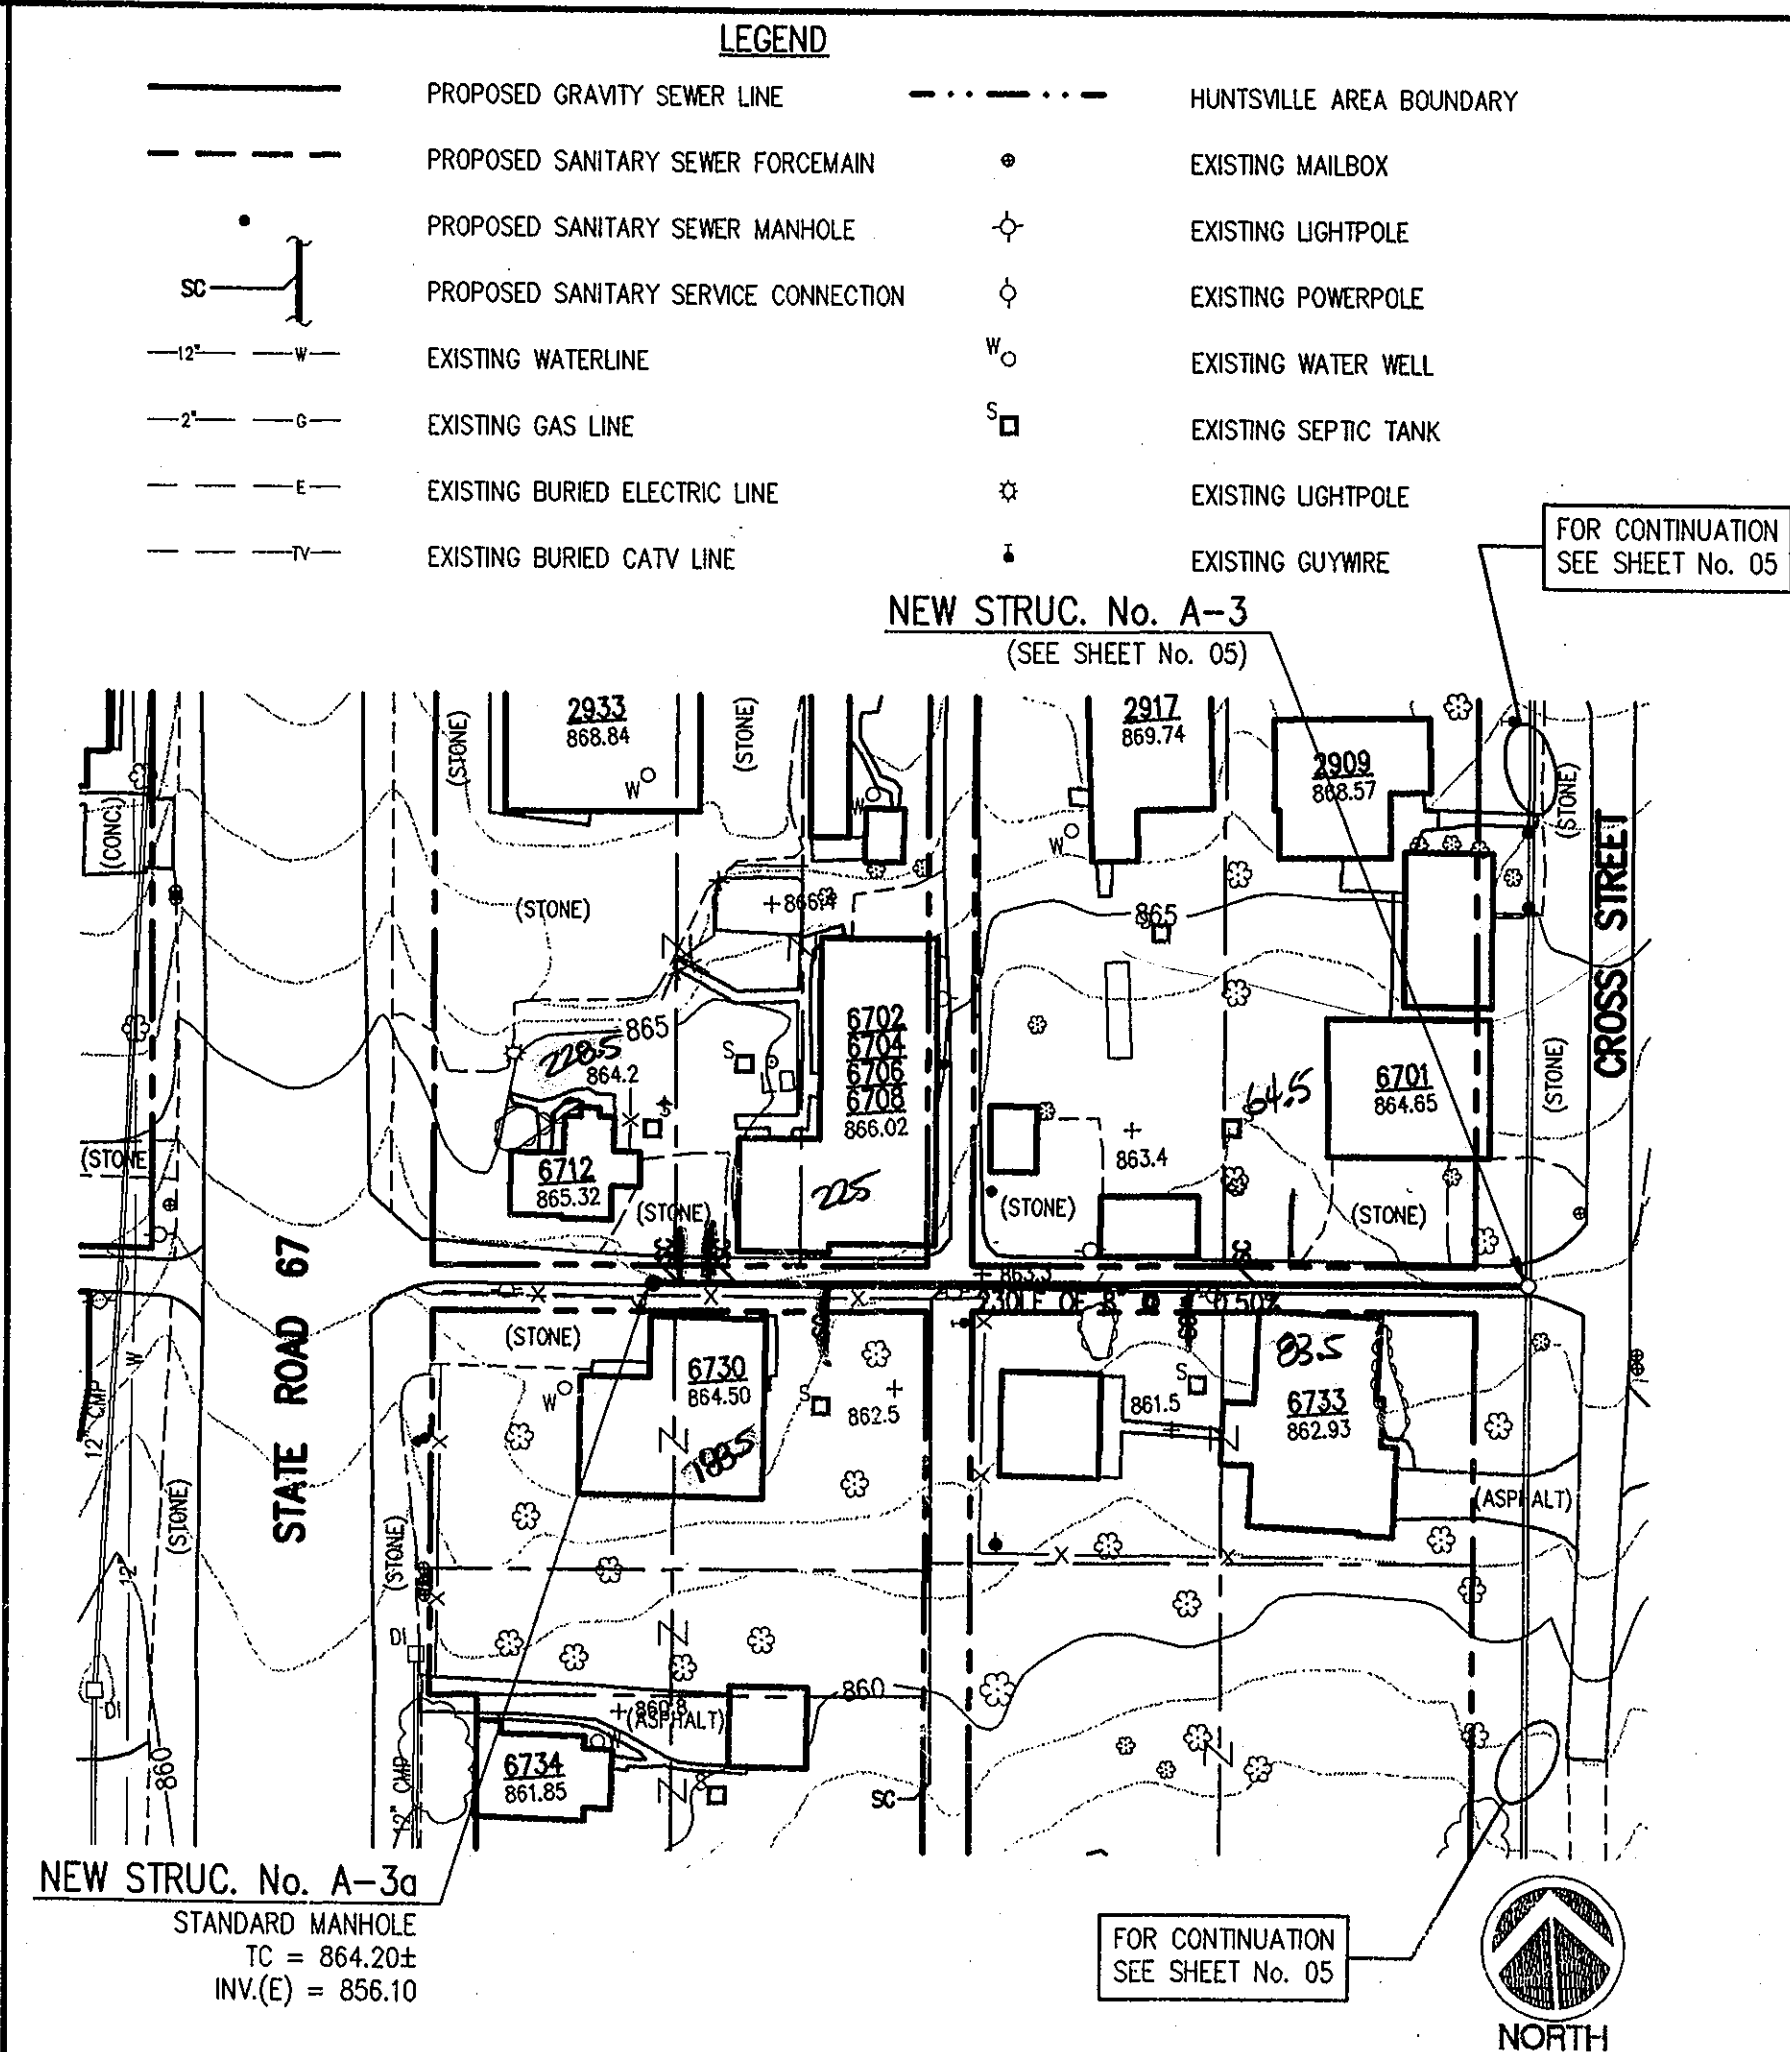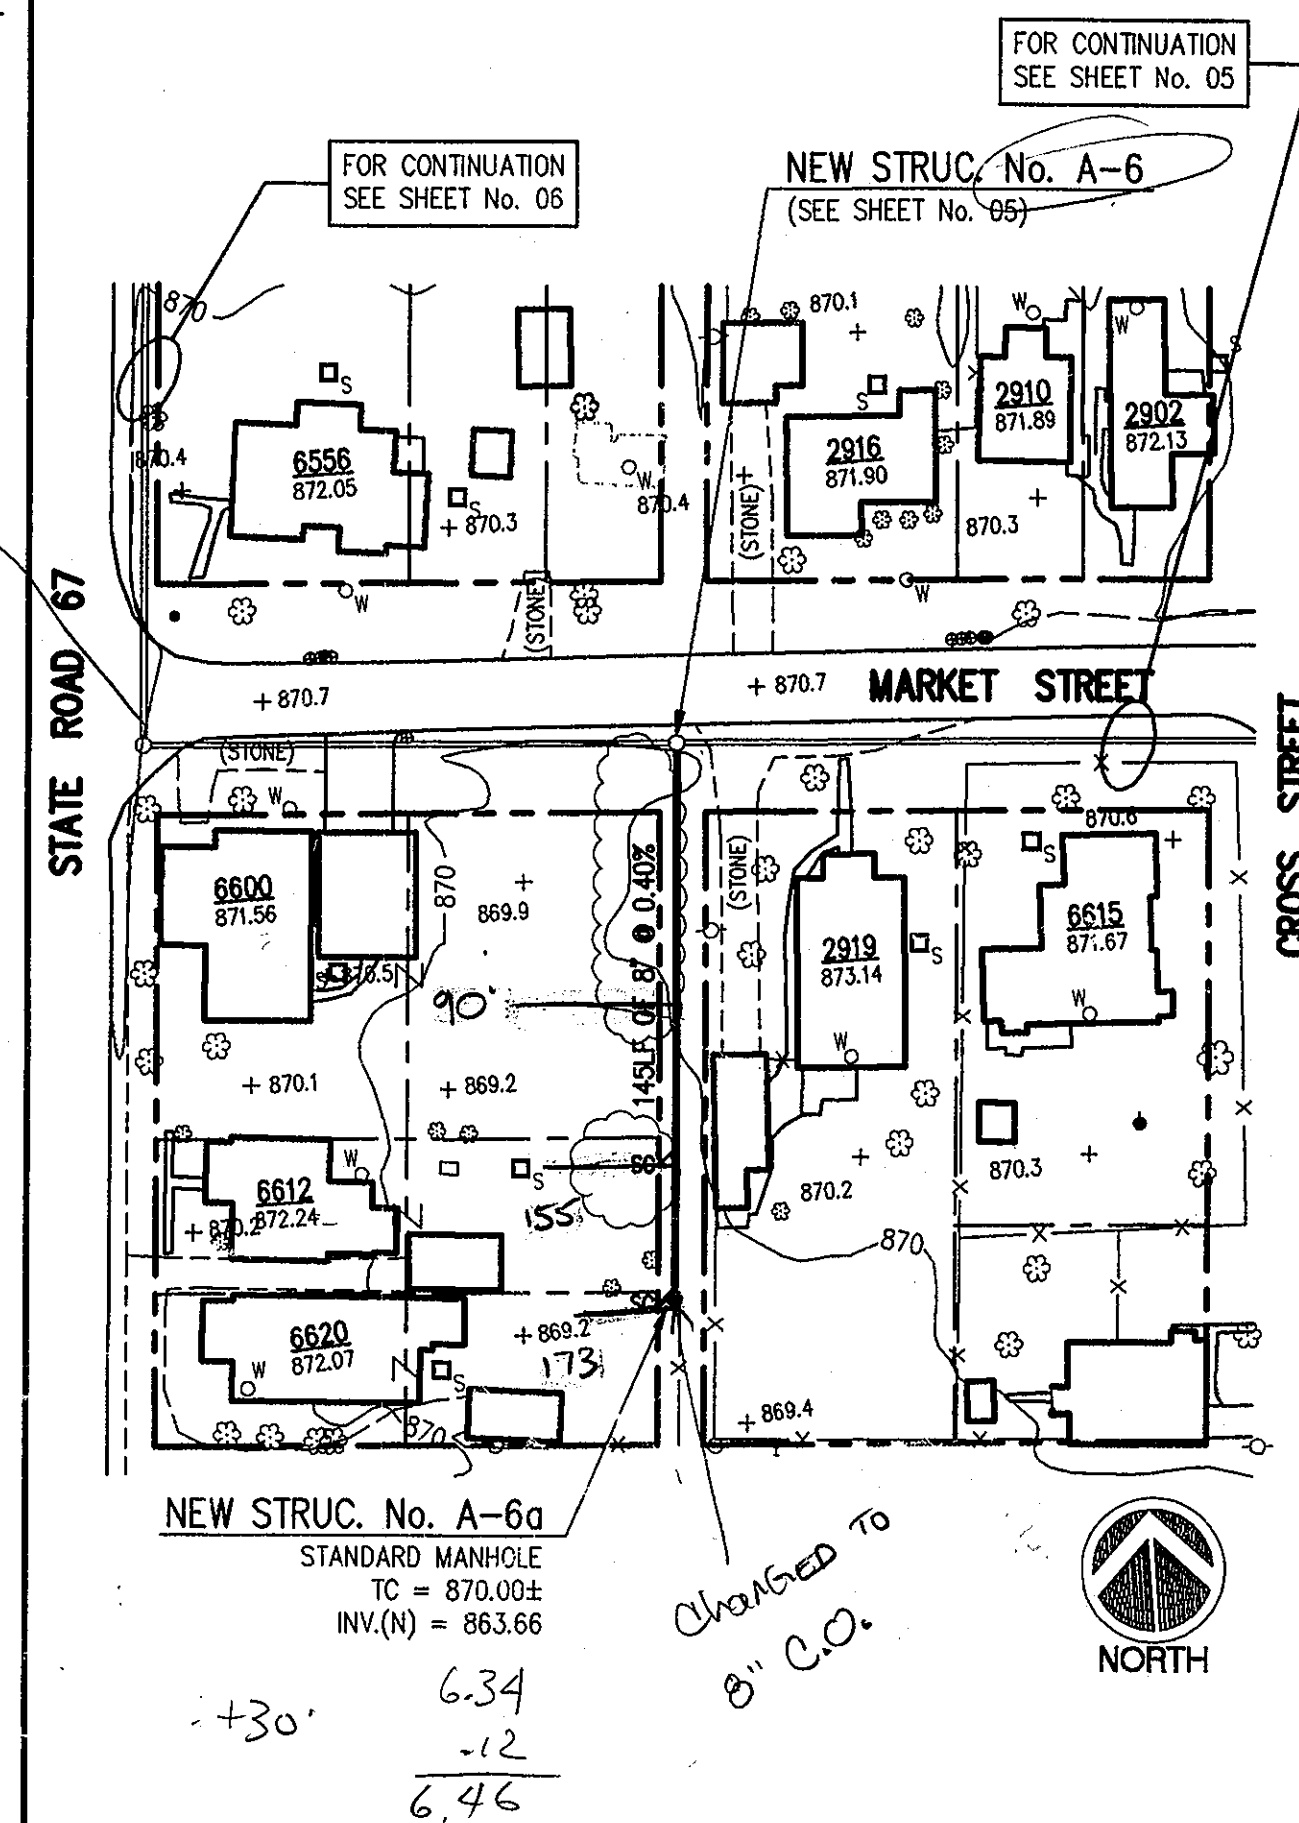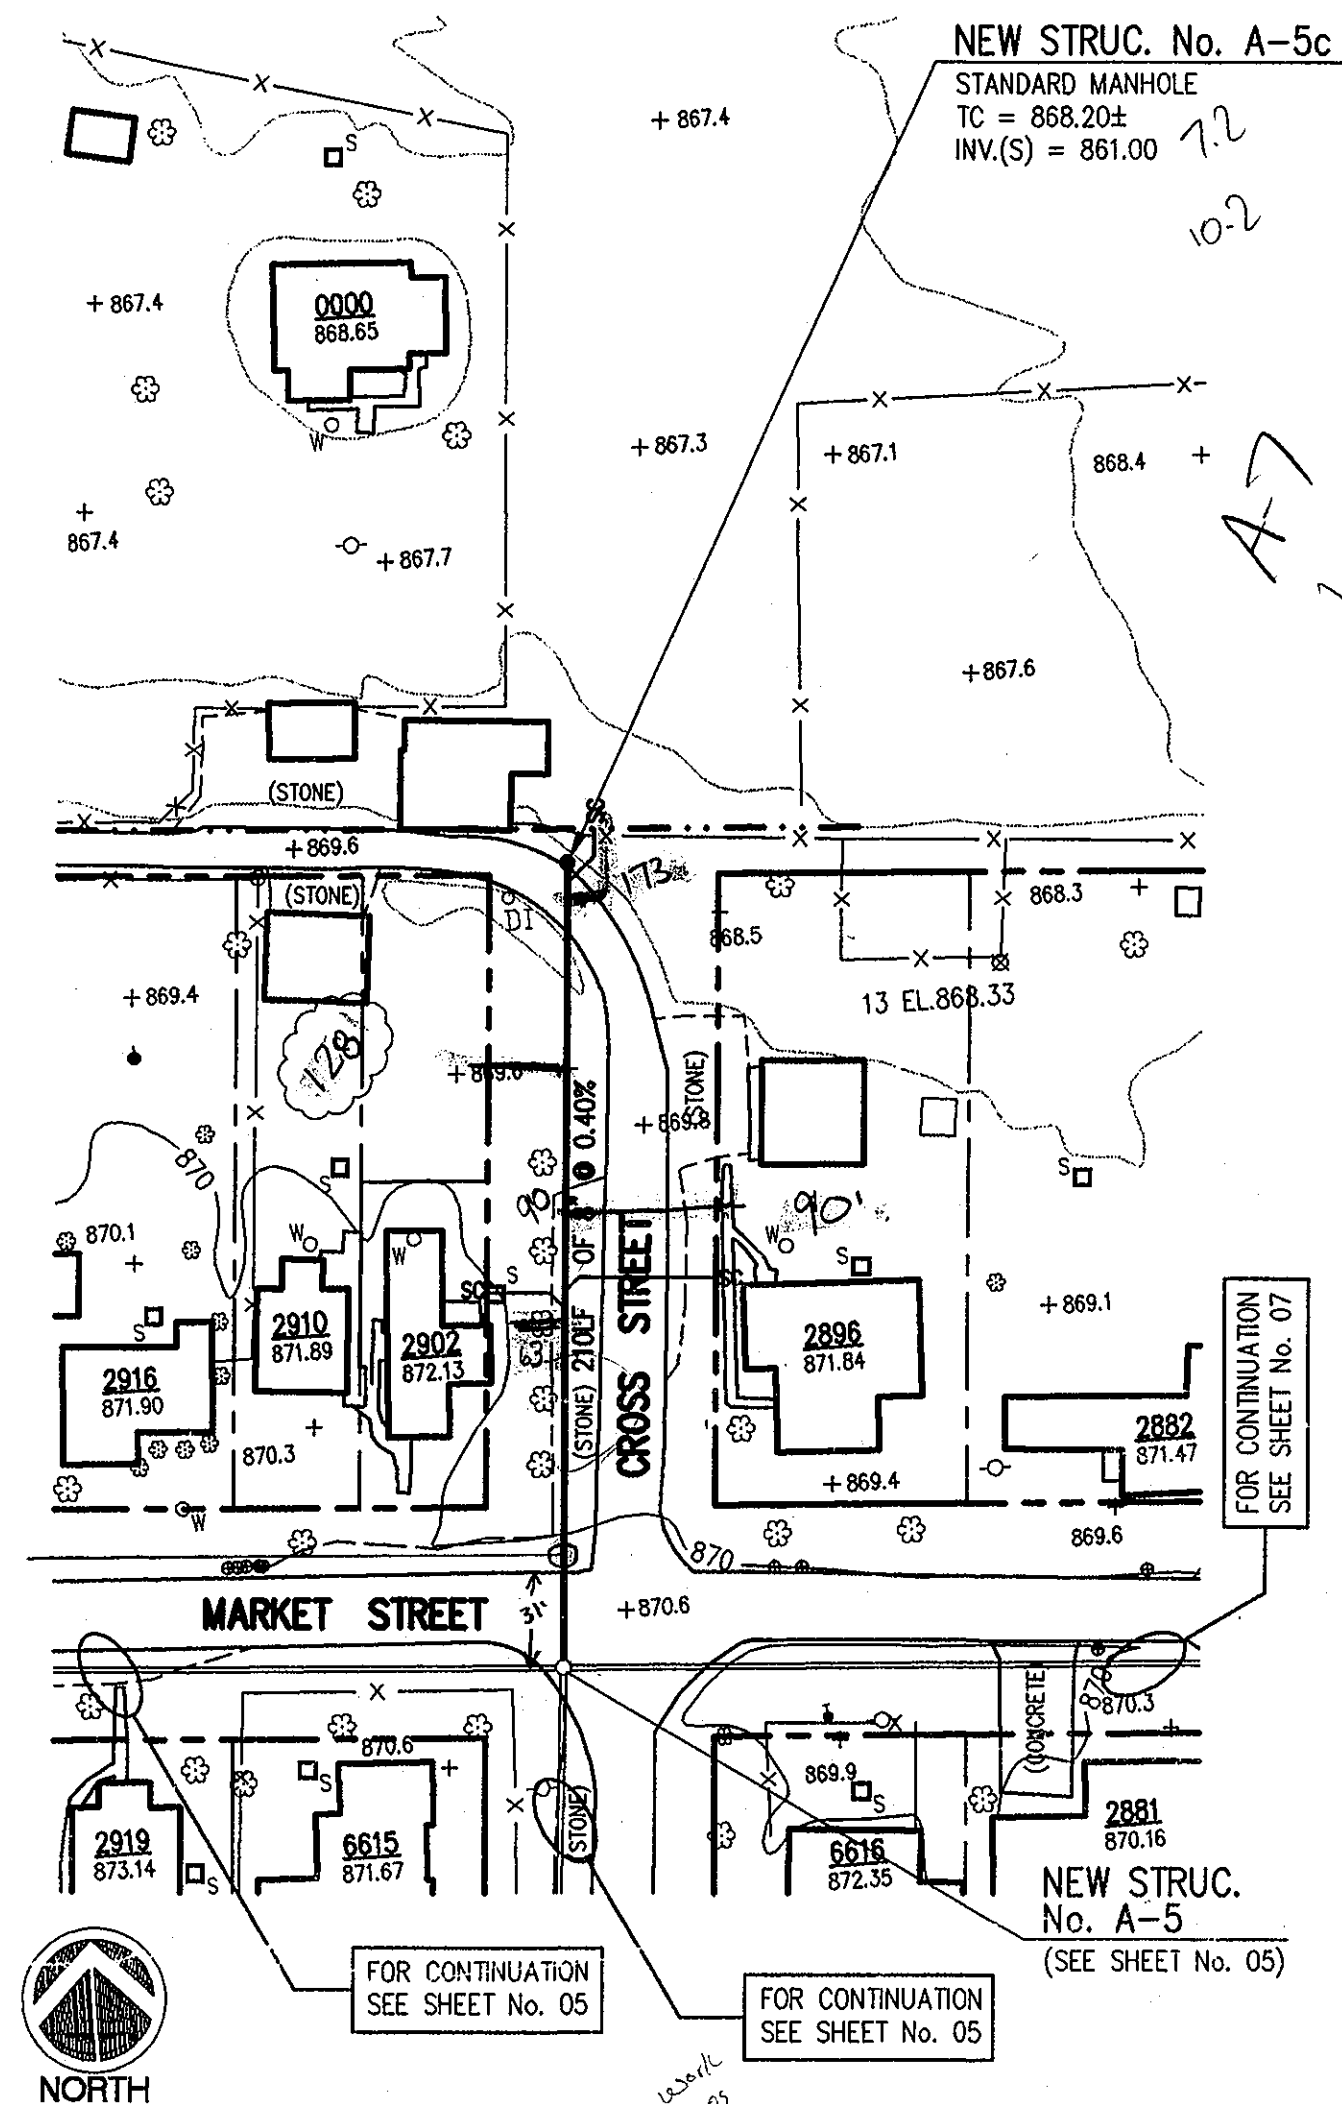

6.8 Average

55

SCALE:
HORIZONTAL: 1" = 50'
VERTICAL: 1" = 5'

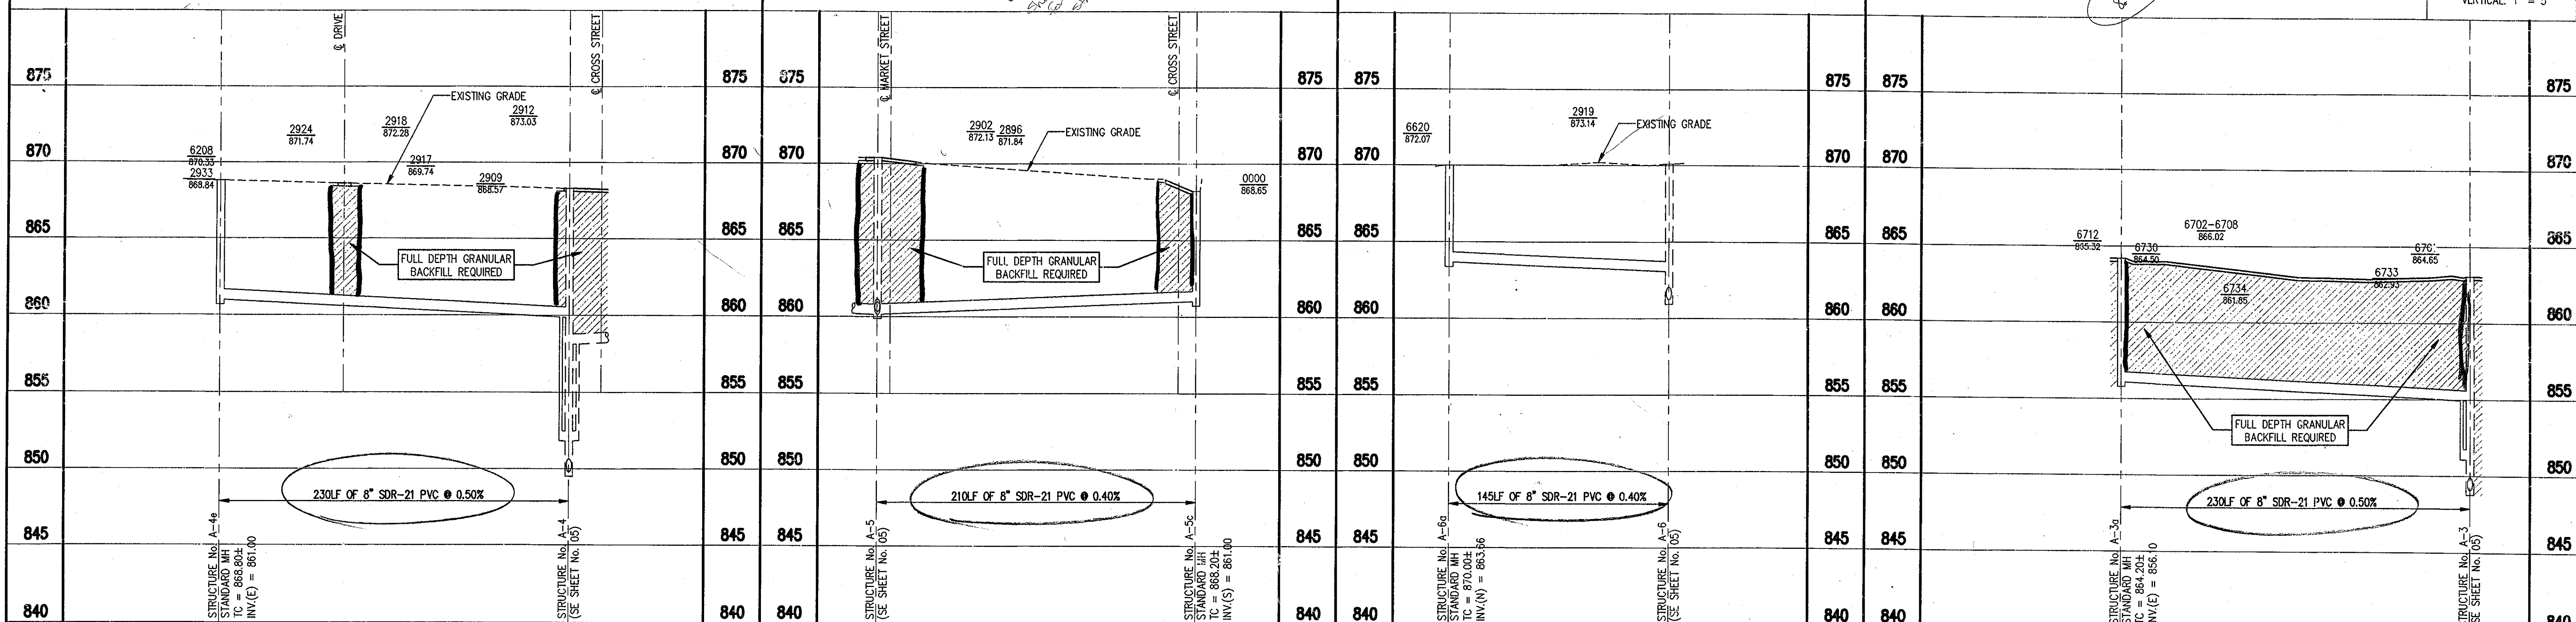

11/07/97	REVISED AS PER ADDENDUM No.1	D.A.P.
----------	------------------------------	--------


--	--	--	--

[illegible]

--	--	--	--

[illegible][illegible][illegible]

**TRIAD
ASSOCIATES
INC.**

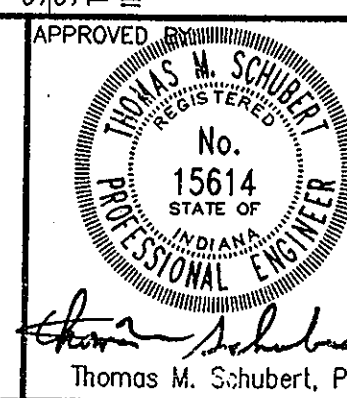

SANITARY SEWER AND FORCEMAIN PROJECT
HUNTSVILLE, INDIANA

LINE 'A-3', LINE 'A-4', LINE 'A-5', LINE 'A-6'
PLAN AND PROFILE

DRAWN BY:	DATE	PROJECT No.	SHEET No.
DAB	OCTOBER '97	070031	8

DAF	USACE	AS NOTED	97005L	8
DESIGNED BY:		David Kieser, E.I.		

CHECKED BY: W. Frozell, P.E.