


LEGEND

—	PROPOSED GRAVITY SEWER LINE	---	HUNTSVILLE AREA BOUNDARY
---	PROPOSED SANITARY SEWER FORCEMAIN	•	EXISTING MAILBOX
•	PROPOSED SANITARY SEWER MANHOLE	+	EXISTING LIGHTPOLE
+	PROPOSED SANITARY SERVICE CONNECTION	+	EXISTING POWERPOLE
+	EXISTING WATERLINE	+	EXISTING WATER WELL
+	EXISTING GAS LINE	+	EXISTING SEPTIC TANK
+	EXISTING BURIED ELECTRIC LINE	+	EXISTING LIGHTPOLE
+	EXISTING BURIED CATV LINE	+	EXISTING GUYWIRE

GENERAL NOTES:


1. THE CONTRACTOR SHALL BE RESPONSIBLE FOR FIELD VERIFICATION OF ALL UTILITIES, ELEVATIONS, ETC. PRIOR TO CONSTRUCTION.
2. THE CONTRACTOR SHALL BE RESPONSIBLE FOR COMPLETE RESTORATION OF ALL AREAS DAMAGED BY CONSTRUCTION IN ACCORDANCE WITH ALL SPECIFICATIONS OR TO AT LEAST PREVIOUS CONDITION.
3. CONTRACTOR TO MAINTAIN 10'-0" HORIZONTAL SEPARATION WHEN PARALLEL AND 1'-6" WHEN CROSSING EXISTING WATER MAINS WITH PROPOSED SEWERS, UNLESS OTHERWISE INDICATED.
4. CONTRACTOR TO PROVIDE ALL SHORING AND OTHER PRECAUTIONARY MEASURES TO PROTECT EXISTING STRUCTURES AND TO PREVENT UNDERMINING OF ROADWAY SHOULDERS AND STRUCTURES.
5. CONTRACTOR TO PROVIDE ALL NECESSARY EROSION CONTROL DURING CONSTRUCTION.

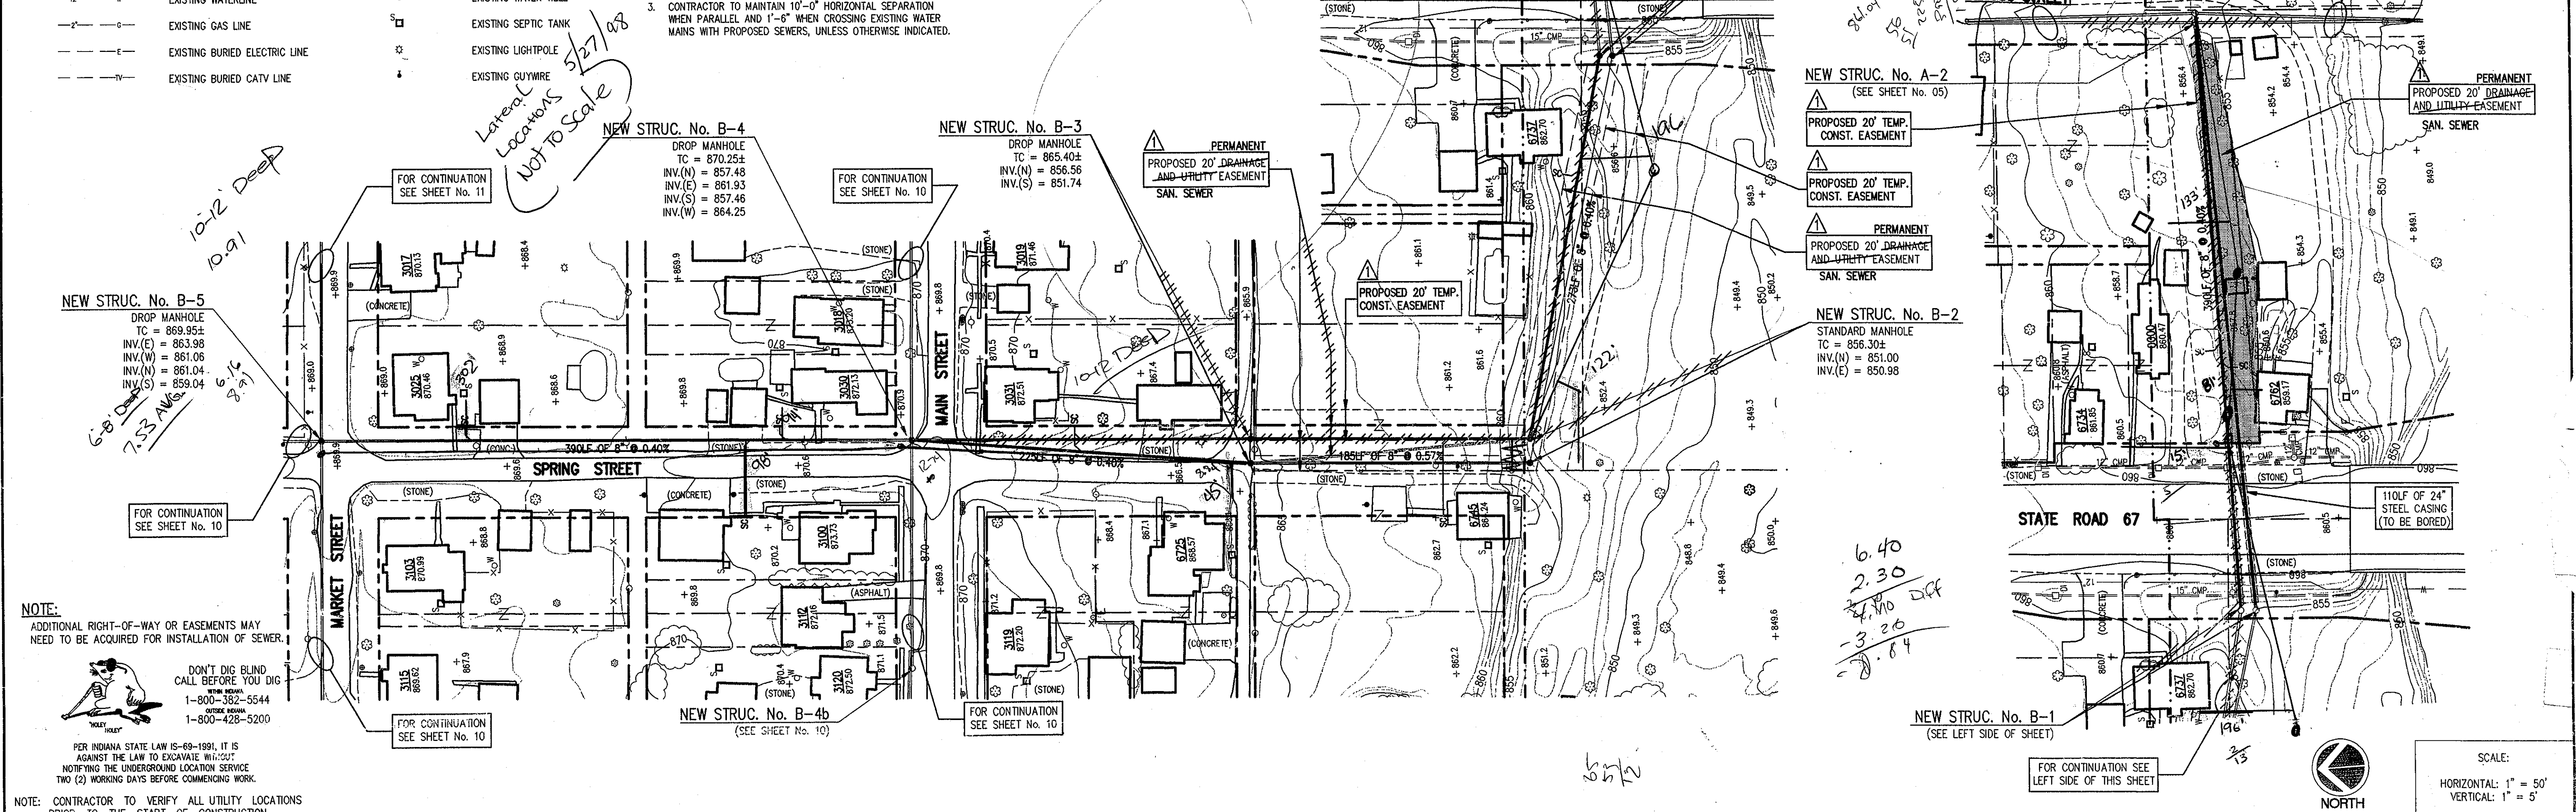

NOTE: ADDITIONAL RIGHT-OF-WAY OR EASEMENTS MAY NEED TO BE ACQUIRED FOR INSTALLATION OF SEWER.

PER INDIANA STATE LAW IS-69-1991, IT IS AGAINST THE LAW TO EXCAVATE WITHOUT NOTIFYING THE UNDERGROUND LOCATION SERVICE TWO (2) WORKING DAYS BEFORE COMMENCING WORK.

NOTE: CONTRACTOR TO VERIFY ALL UTILITY LOCATIONS PRIOR TO THE START OF CONSTRUCTION

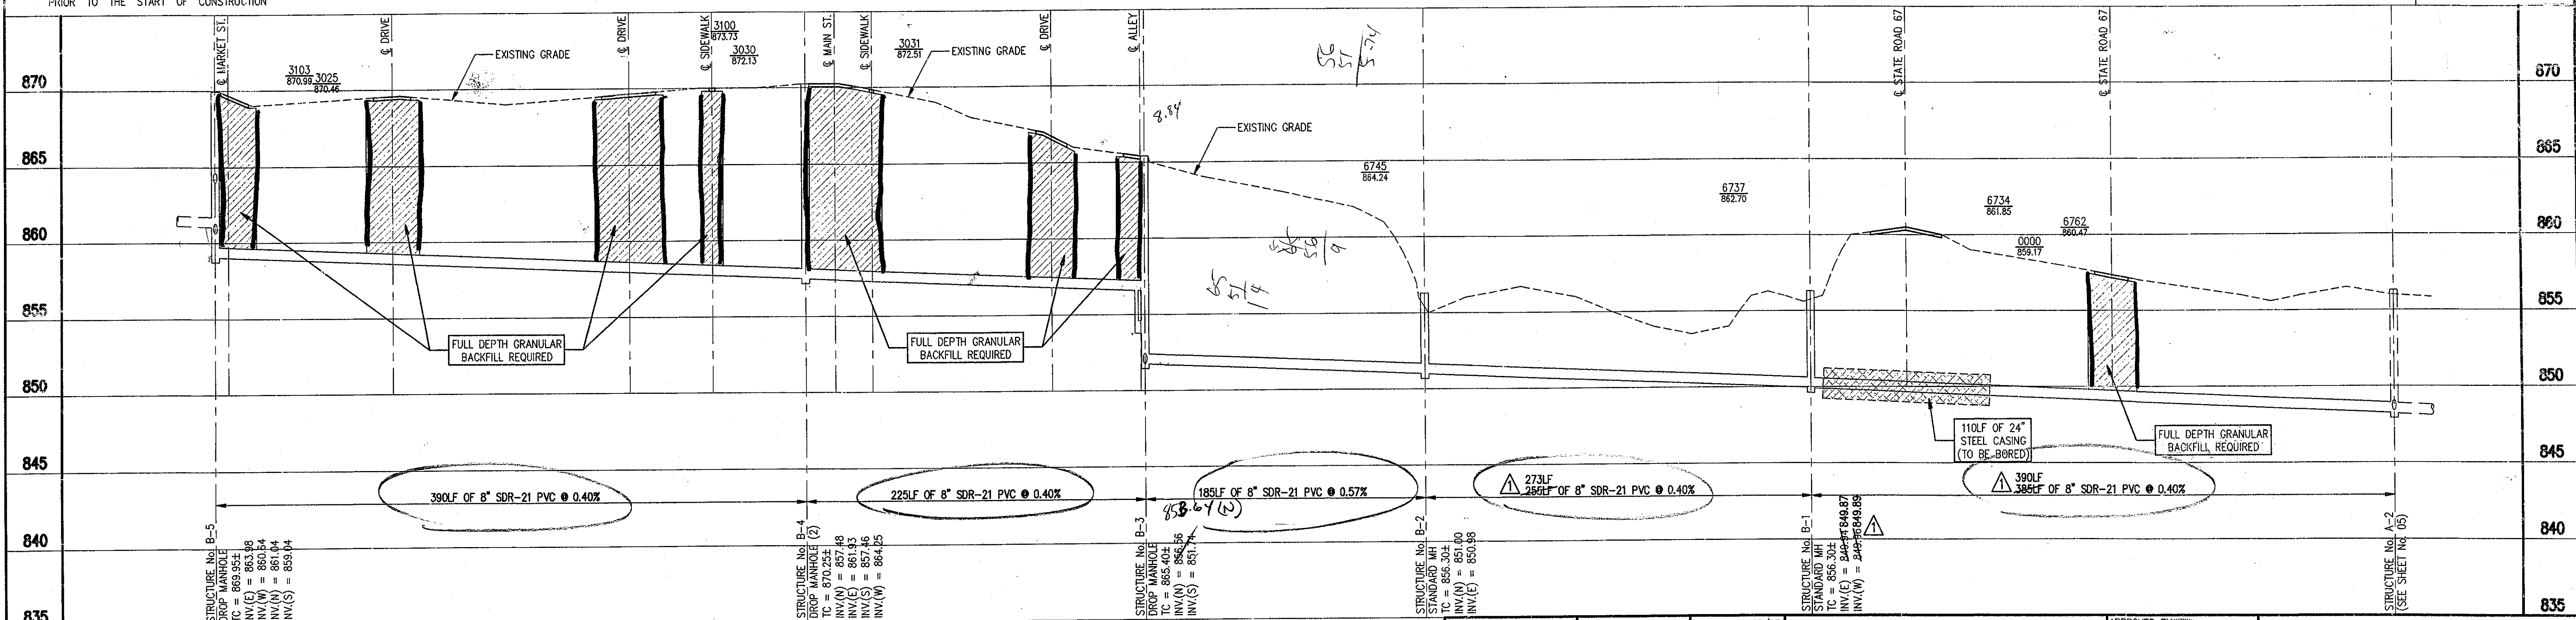

FILE NAME: 97003LC6		PLOT SCALE: 1"=50'		PLOT DATE: 10/27/98	
01/27/98		REVISED AS PER MEETING w/ OWNER		D.A.P.	
NO.		DATE		DESCRIPTION	
BY		DATE		DESCRIPTION	

TRIAD ASSOCIATES INC.

INDIANAPOLIS, INDIANA

APPROVED:

Thomas M. Schubert, P.E.

SANITARY SEWER AND FORCEMAIN PROJECT
HUNTSVILLE, INDIANA

LINE 'B'
PLAN AND PROFILE

DRAWN BY: DAP
SCALE: AS NOTED
PROJECT No. 97003L
SHEET No. 9

DESIGNED BY: David Kleser, E.I.
CHECKED BY: James W. Frazell, P.E.