

FALL CREEK REGIONAL WASTE DISTRICT

HUNTSVILLE ROAD SEWER PROJECT

FALL CREEK REGIONAL DISTRICT BOARD

Bill Clark
BILL CLARK - PRESIDENT

Morris McCurdy
MORRIS MCCURDY - MEMBER

Charles Hennis
CHARLES HENNIS - MEMBER

Mark Jablonski
MARK JABLONSKI - MEMBER

Agon Tolbert
AGON TOLBERT - MEMBER

MARVIN KELLY - MEMBER


Steve Poore
STEVE POORE - MEMBER

MARION MORRIS - MEMBER

John Ellingwood
JOHN ELLINGWOOD - MEMBER

Joe Fowlett
JOE FOWLETT - GENERAL MANAGER

BEGIN
PROJECT

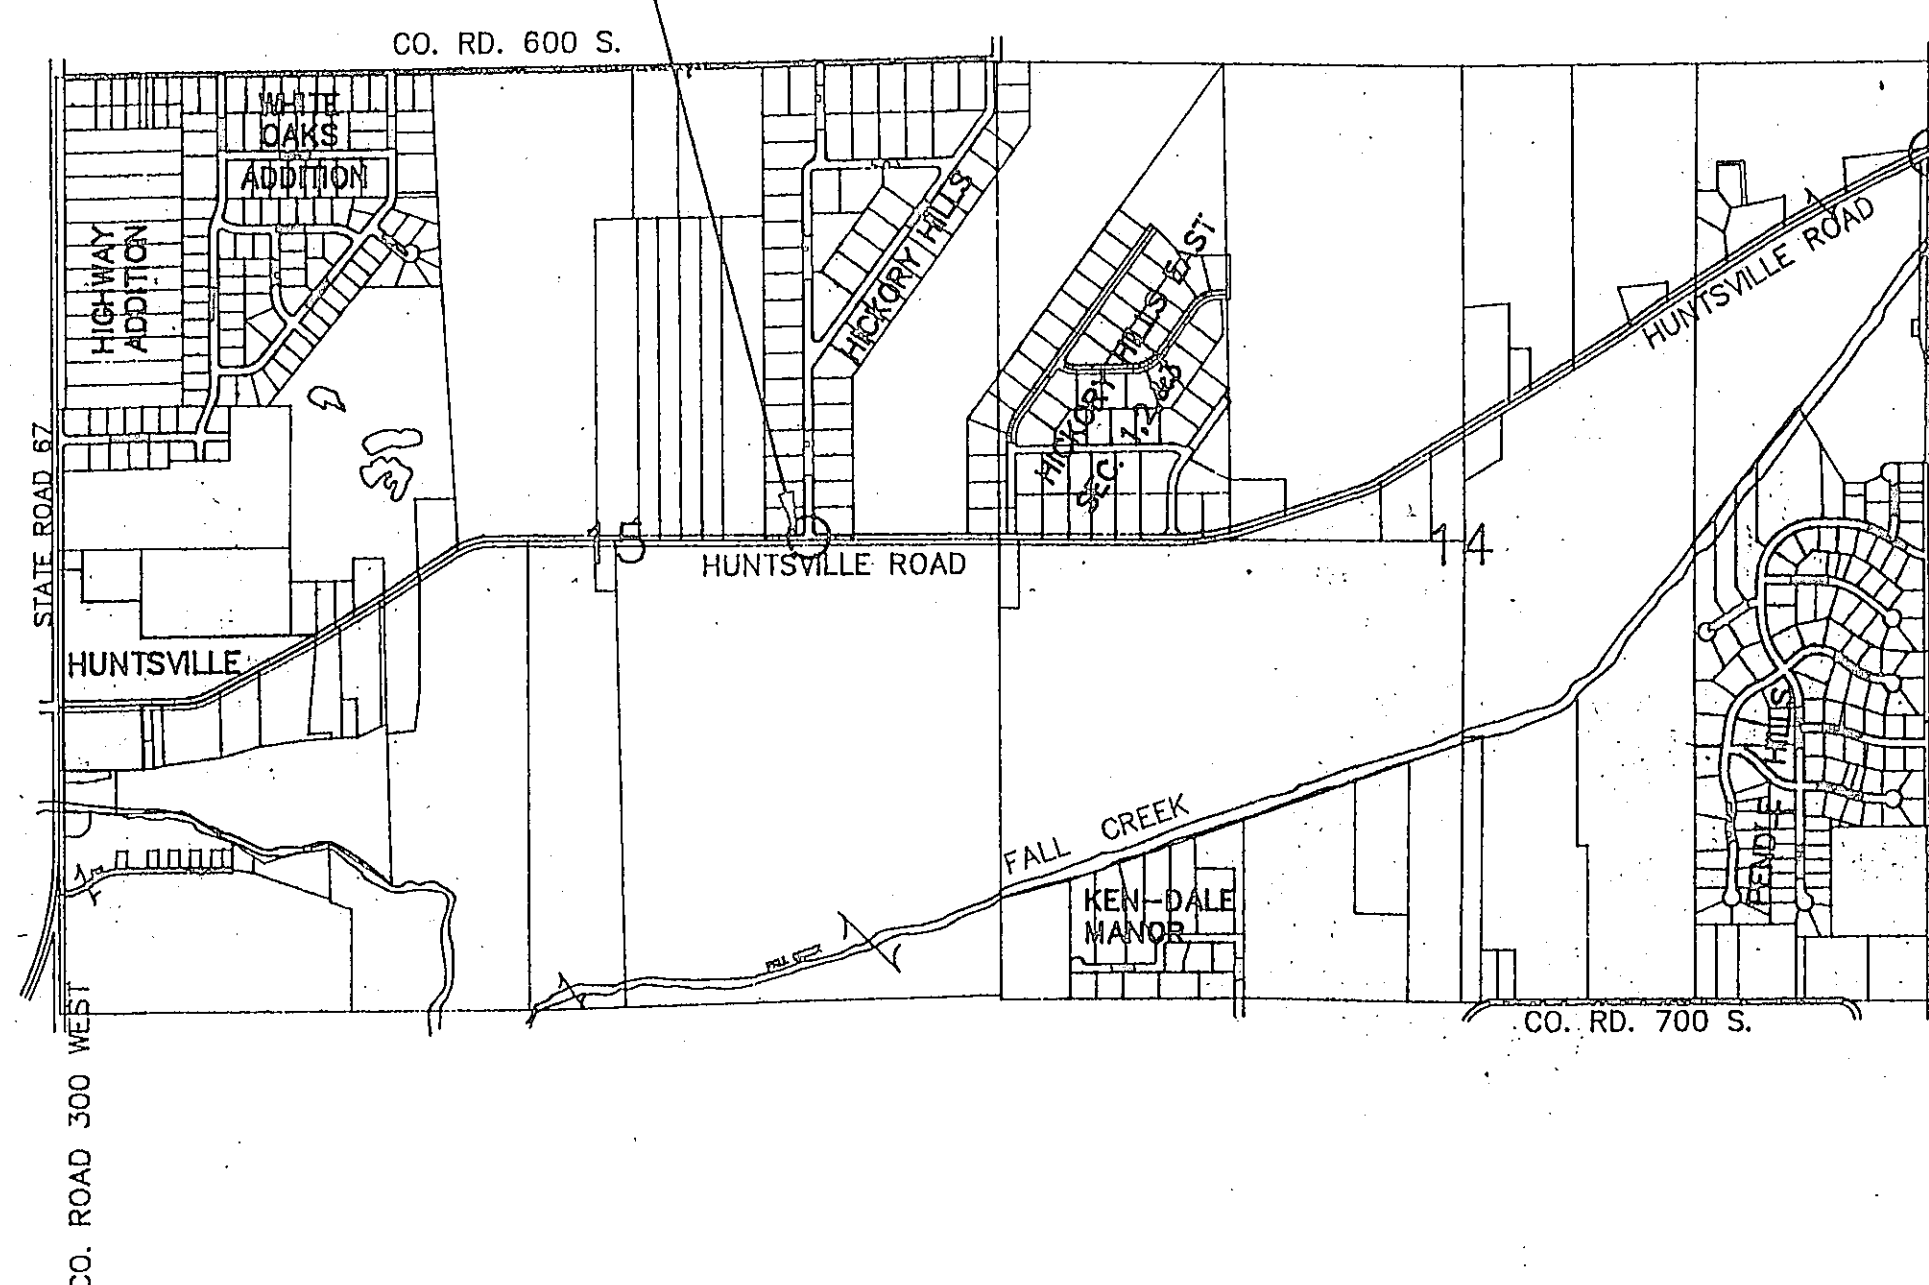

END PROJECT

INDEX	
SHEET	DESCRIPTION
1	TITLE SHEET
2	SHEET INDEX
3-8	PLAN AND PROFILE
9	DETAILS

CERTIFIED BY: Richard E. Durham

DATE: October 30, 1992

FOR W.D. HUNTSVILLE ROAD SEWER PLANS

1	2	3	100
---	---	---	---	---	---	---	---	---	----	----	-----

DURHAM Engineering
12 W. 8th STREET - ANDERSON, INDIANA
(317) 644-3111

SCALE
SHEET NO. 1 of 9

