



Drawing name: K:\IND_LIVE\1705080022 Mahoney Corner_Sec1_Ingalls.JV1 Design\CAD\Drawings\Sanitary Plan and Profile C500 SANITARY PLAN & PROFILE Jun 19, 2025 1:30pm by: TristenCorthers
This document, together with the concepts and designs presented herein, as an instrument of service, is intended only for the specific purpose and client for which it was prepared. Reuse of and improper reliance on this document without written authorization and adaptation by Kinley-Horn and Associates, Inc. shall be without liability to Kinley-Horn and Associates, Inc.

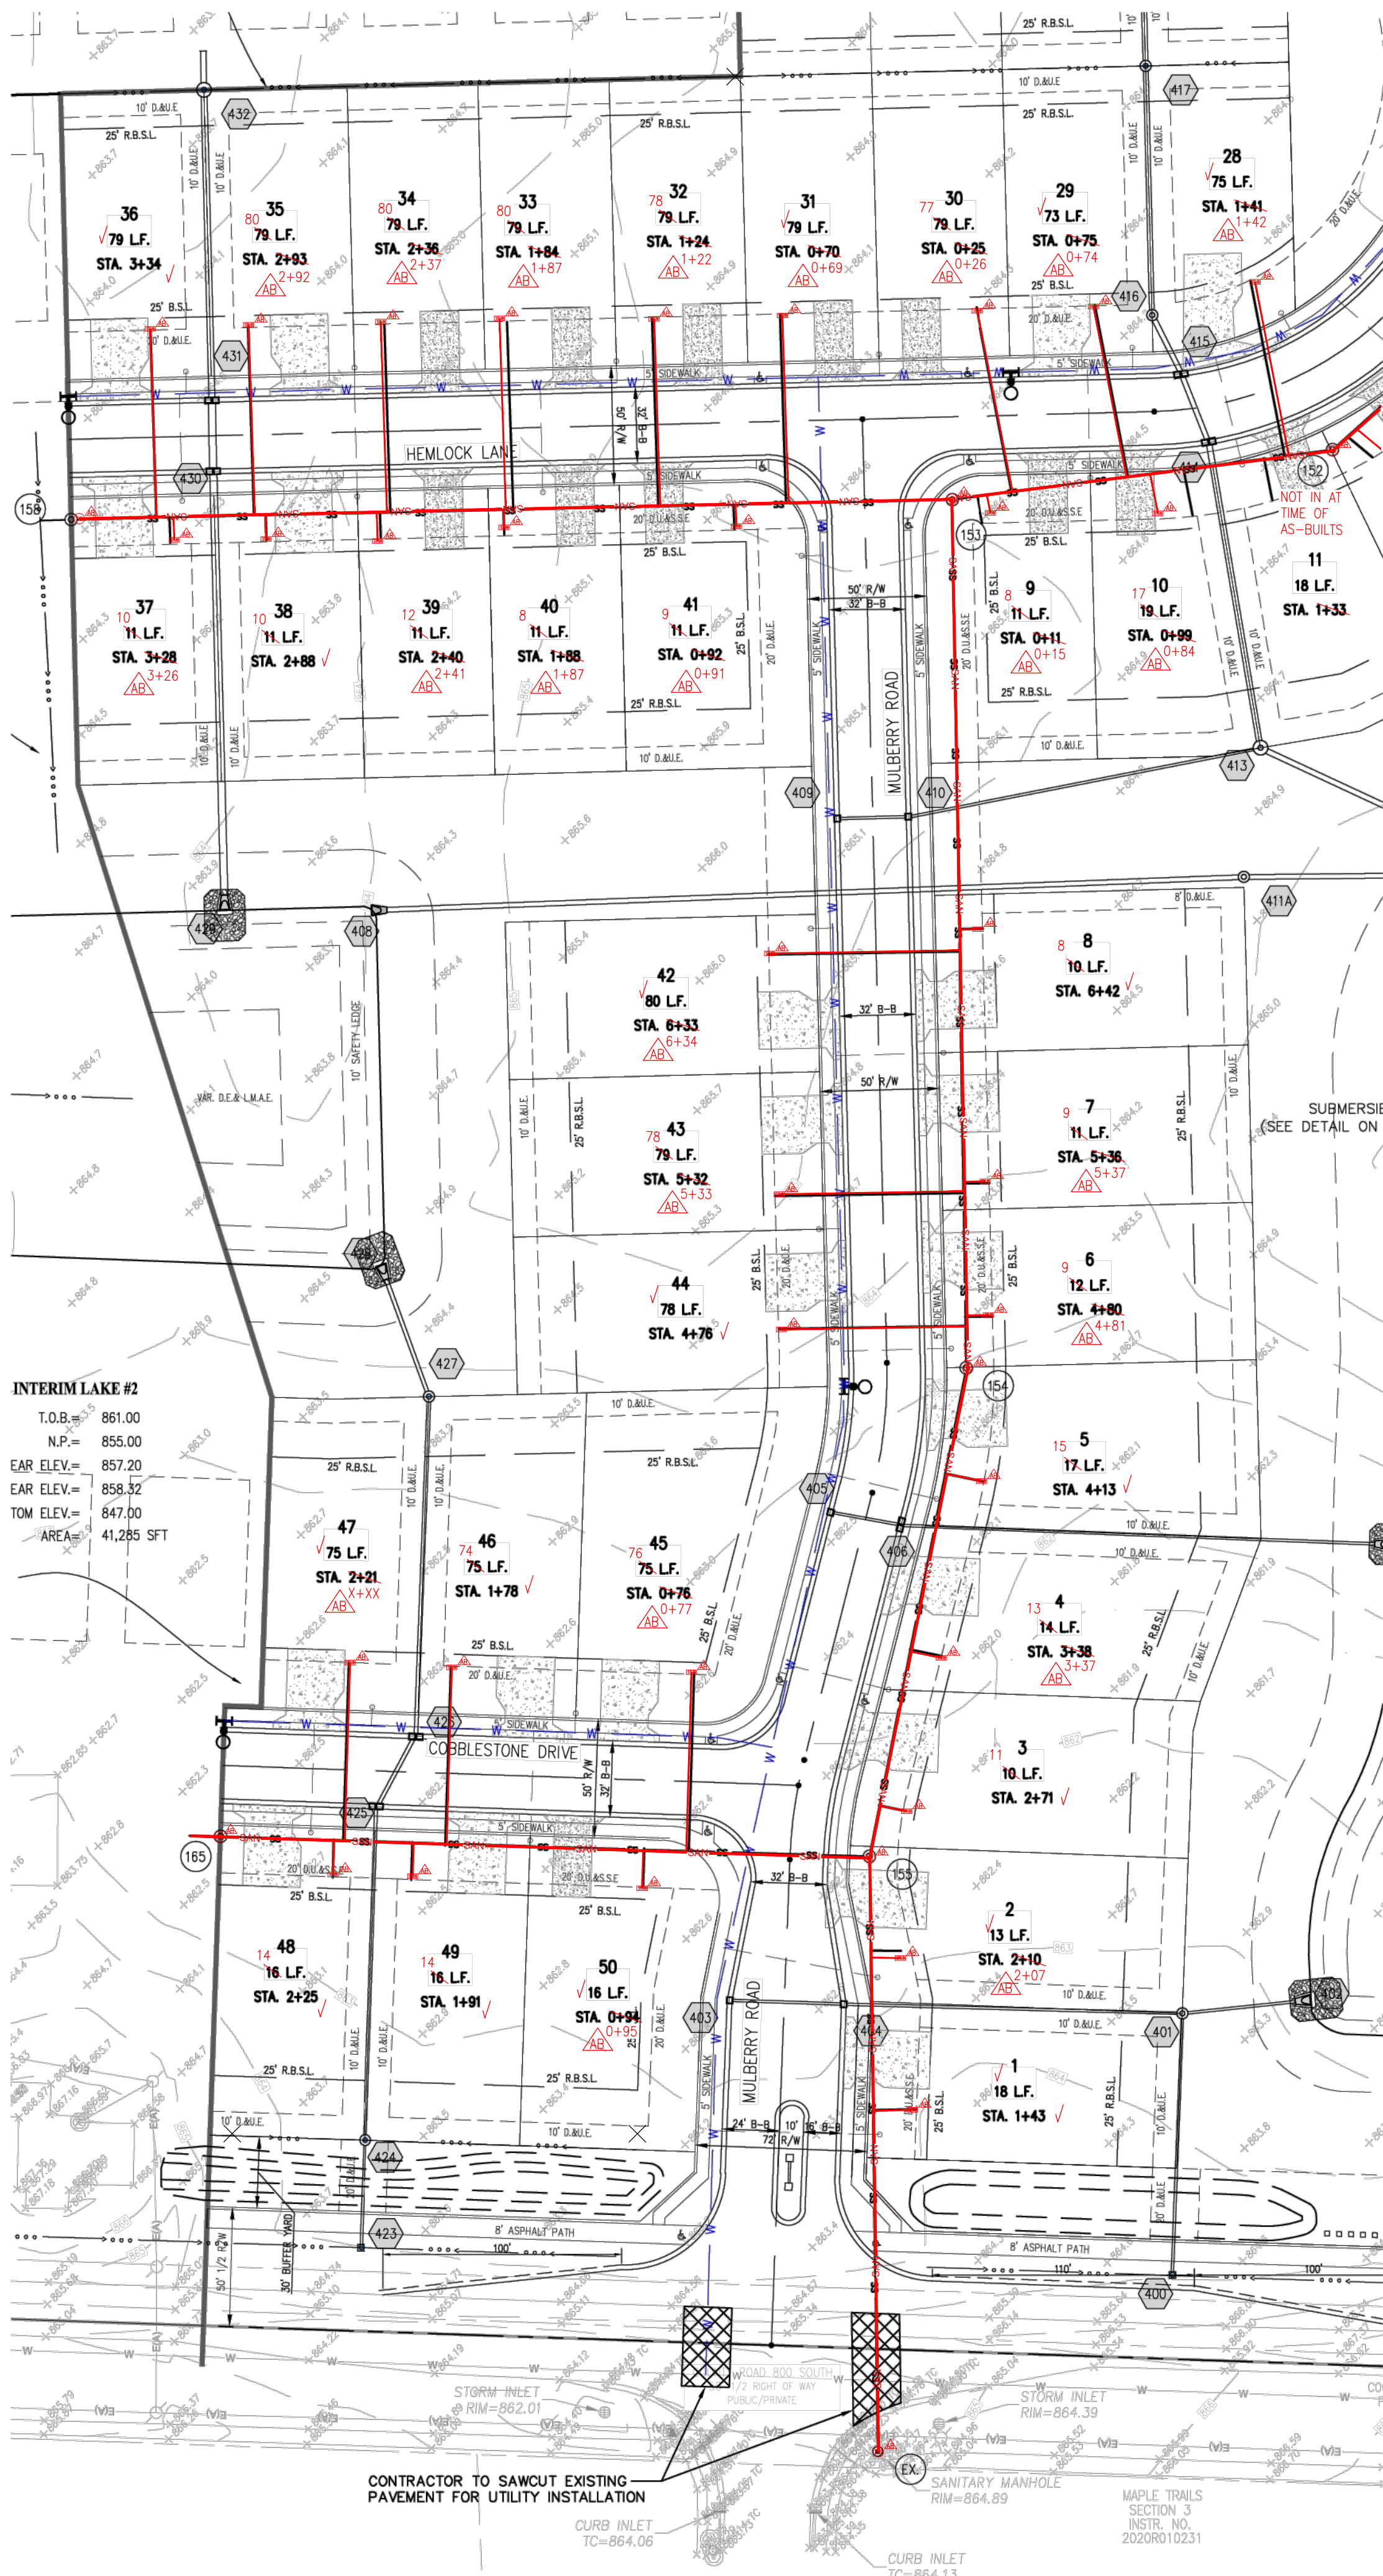

RECORD DRAWING
SANITARY SEWER AS-BUILTS
SANITARY SEWER STRUCTURES ONLY
DATE:08/06/2025



ANDREW D. BAXTER, JR.
PROFESSIONAL LAND SURVEYOR
#LS20400029

I, THE ABOVE SIGNED, CERTIFY THAT THE RECORD DRAWING INFORMATION PRESENTED ON THIS SHEET WAS PERFORMED UNDER MY DIRECT SUPERVISION, I FURTHER CERTIFY THAT TO THE BEST OF MY KNOWLEDGE AND BELIEF THAT THE IMPROVEMENTS HAVE BEEN INSTALLED IN REASONABLE COMPLIANCE WITH THE ORIGINAL DESIGN PLANS WITH RESPECT TO HORIZONTAL LOCATIONS AND GRADES AND ANY DEVIATIONS OF LOCATIONS, GRADE OR MATERIAL USED ARE SHOWN IN THESE "RECORD CONSTRUCTION DRAWINGS" (PLANS) AS OF 10/29/2025.

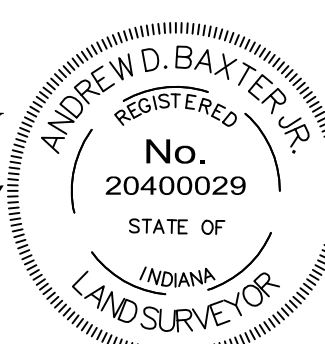


- ### LATERAL NOTES
- ALL SANITARY SEWER LATERALS ARE TO BE 6" PVC SDR 26 LAID AT A MIN. SLOPE OF 1.04% (1/8" PER FOOT)
 - LATERAL CONNECTIONS TO THE SANITARY SEWER SHALL BE MADE WITH A FABRICATED SDR 26 TEE-WYE. SADDLE TAPS ARE NOT PERMITTED FOR NEW CONSTRUCTION.
 - CLEANOUTS SHALL BE LOCATED 3 FEET OUTSIDE OF THE BUILDING. TO BE INSTALLED TO GRADE AT ALL BENDS OF 45 DEGREES OR GREATER, AND AT THE HIGH POINT OF THE CONNECTION, ADJACENT TO THE BUILDING SEWER CONNECTION.
 - PROPOSED SANITARY LATERALS SHALL MAINTAIN A 18"(1.5') VERTICAL SEPARATION WITH THE WATER MAIN.

- ### NOTES
- REFER TO SHEET C201 FOR STRUCTURE TABLE.
 - REFER TO SHEET C101 FOR GENERAL NOTES.
 - STORM DRAINS, DOWNSPOUTS, ETC. ARE NOT PERMITTED TO DISCHARGE INTO THE SANITARY SEWER.
 - PVC GRAVITY SEWER PIPE AND FITTINGS MUST, AT MINIMUM, BE INSTALLED IN ACCORDANCE WITH THE DIRECTIONS CONTAINED IN ASTM D2321 AND FOLLOW CURRENT FORMD STANDARDS

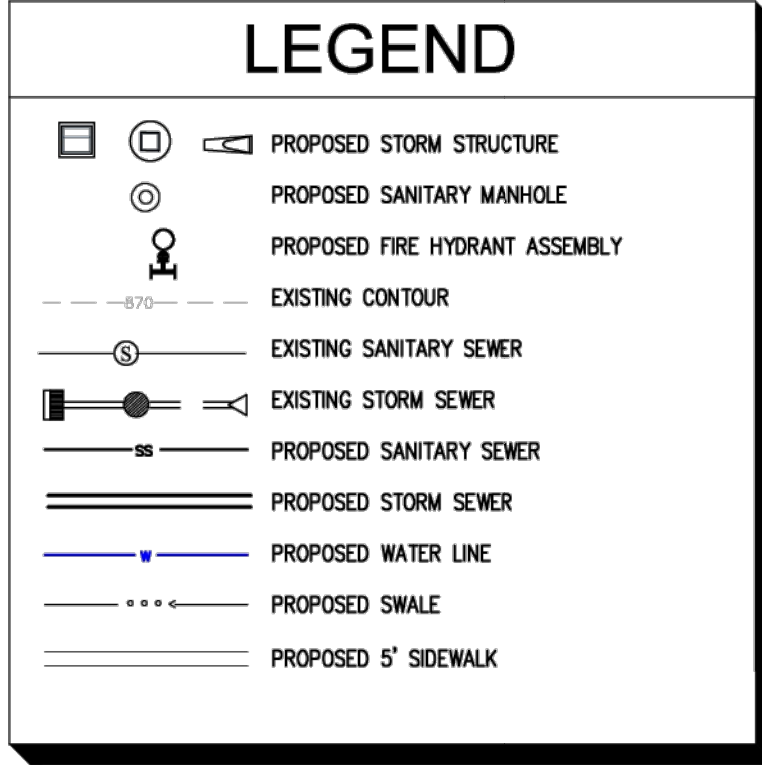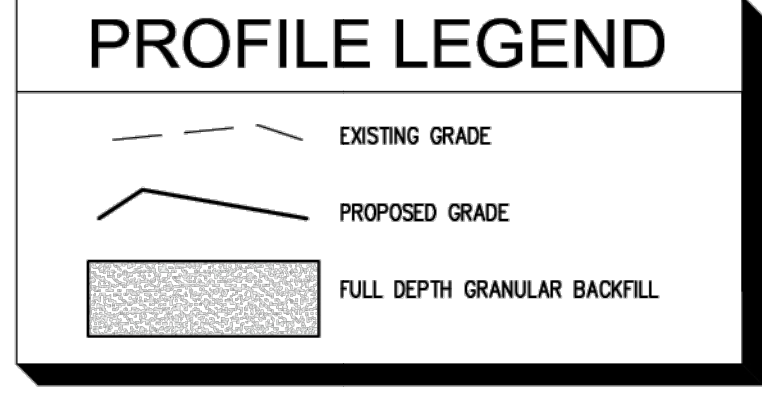


DATE OF LAST FIELDWORK: 10/28/2025


NOTE: SLOPES AND DISTANCES ARE FROM CENTER OF MANHOLE LID TO CENTER OF MANHOLE LID. SLOPES AND DISTANCES ARE APPROXIMATE.

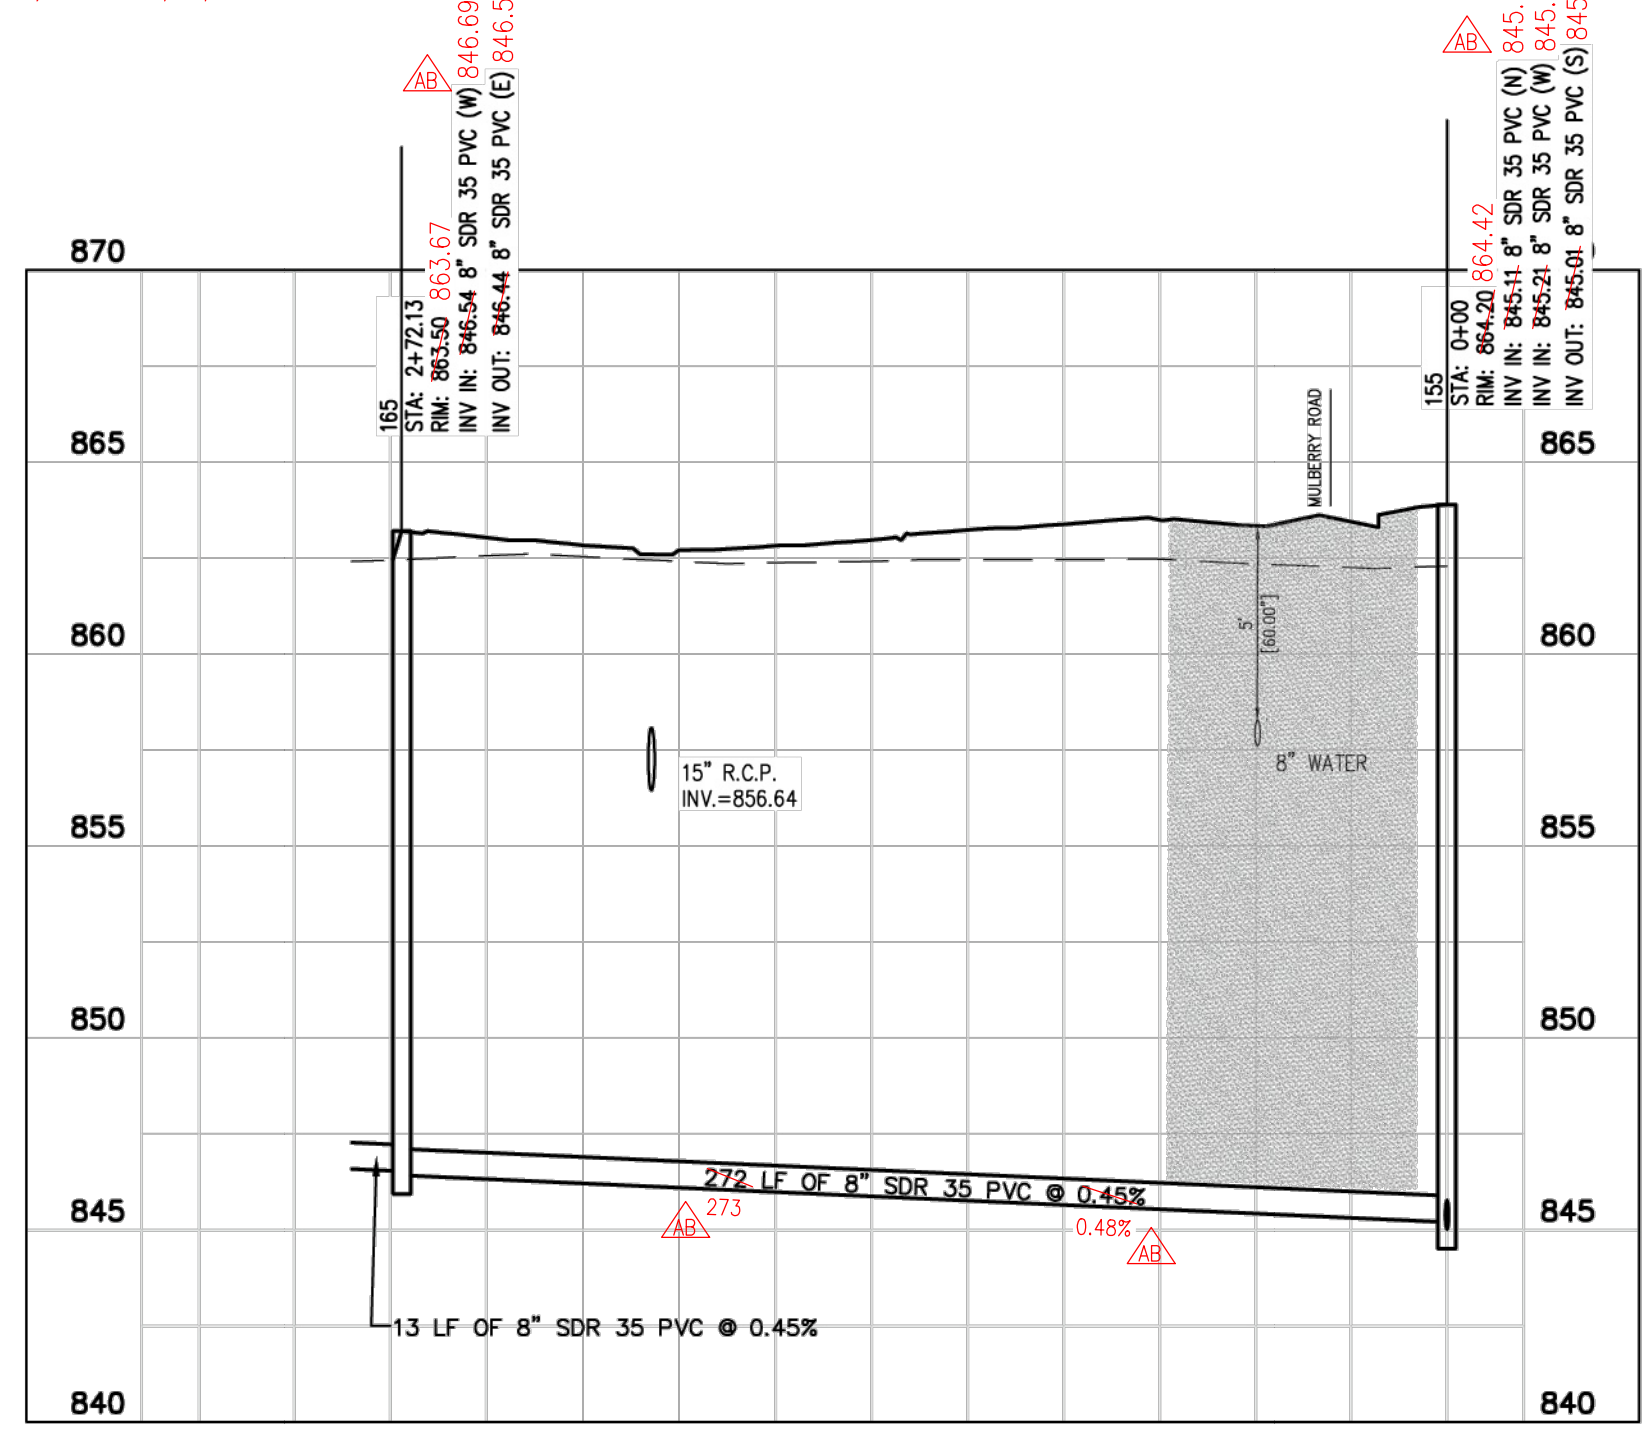

SAN 165-155
H: 1"=50 ; V: 1"=5

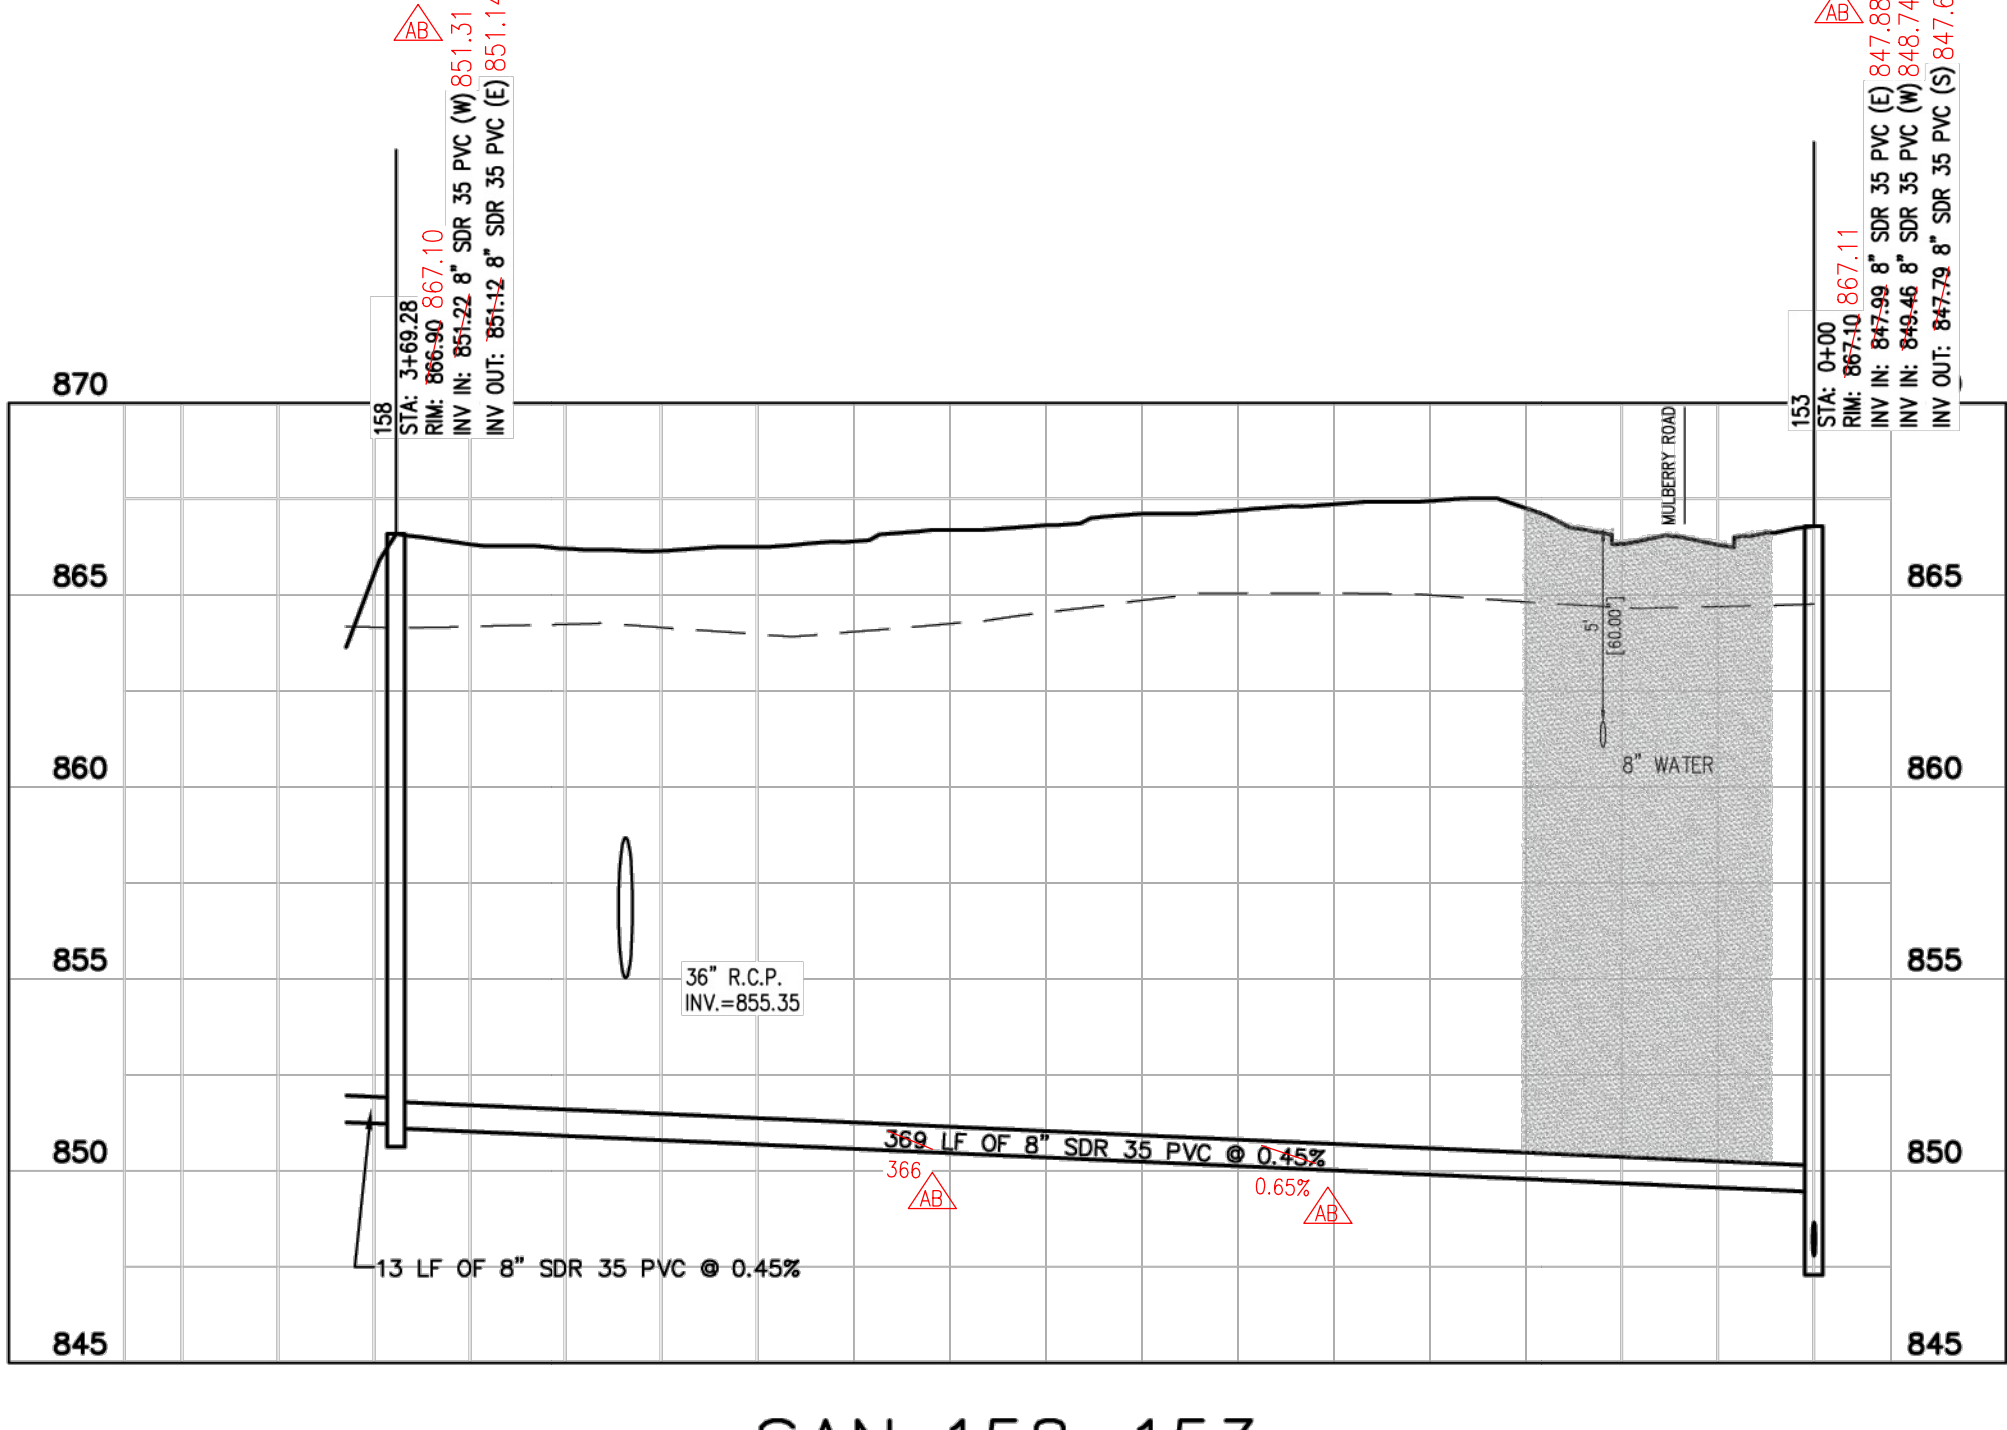

SAN 158-153
H: 1"=50 ; V: 1"=5

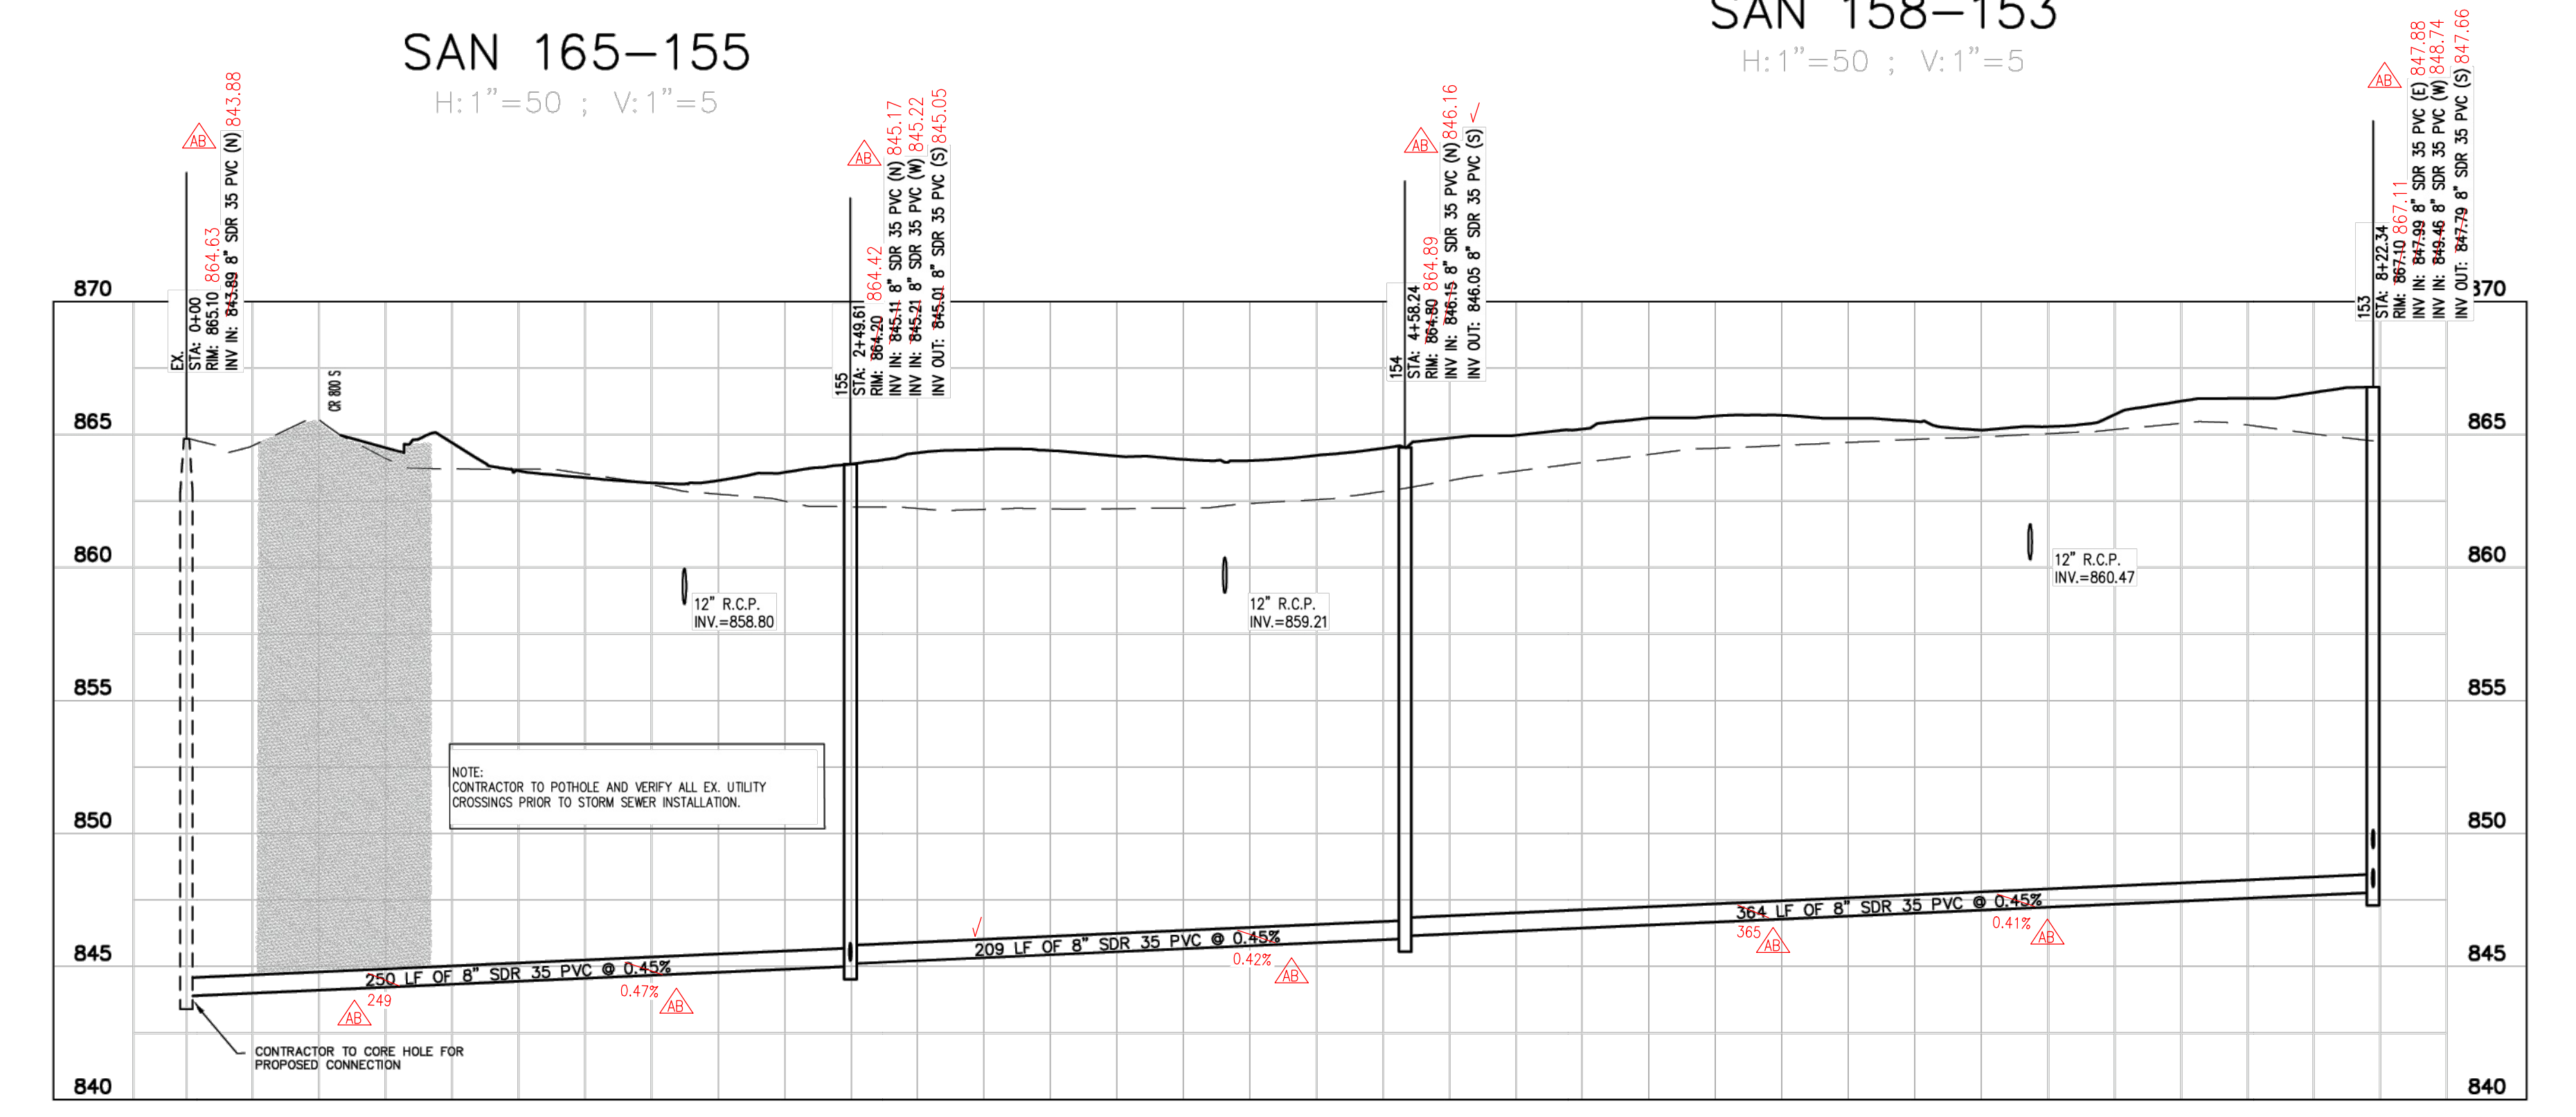

SAN 153-EX
H: 1"=50 ; V: 1"=5

Indiana Utilities Protection Service



MAHONEY'S CORNER		SANITARY PLAN & PROFILE		TAYLOR MORRISON		Kimley»Horn	
ORIGINAL ISSUE:	02/14/2025	SEC 1	INGALLS, IN	DESIGNED BY BAH	AS NOTED	DRAWN BY: PCW	SCALE:
KHA PROJECT NO.	170508002			CHECKED BY: BAH			
SHEET NUMBER	C500						