

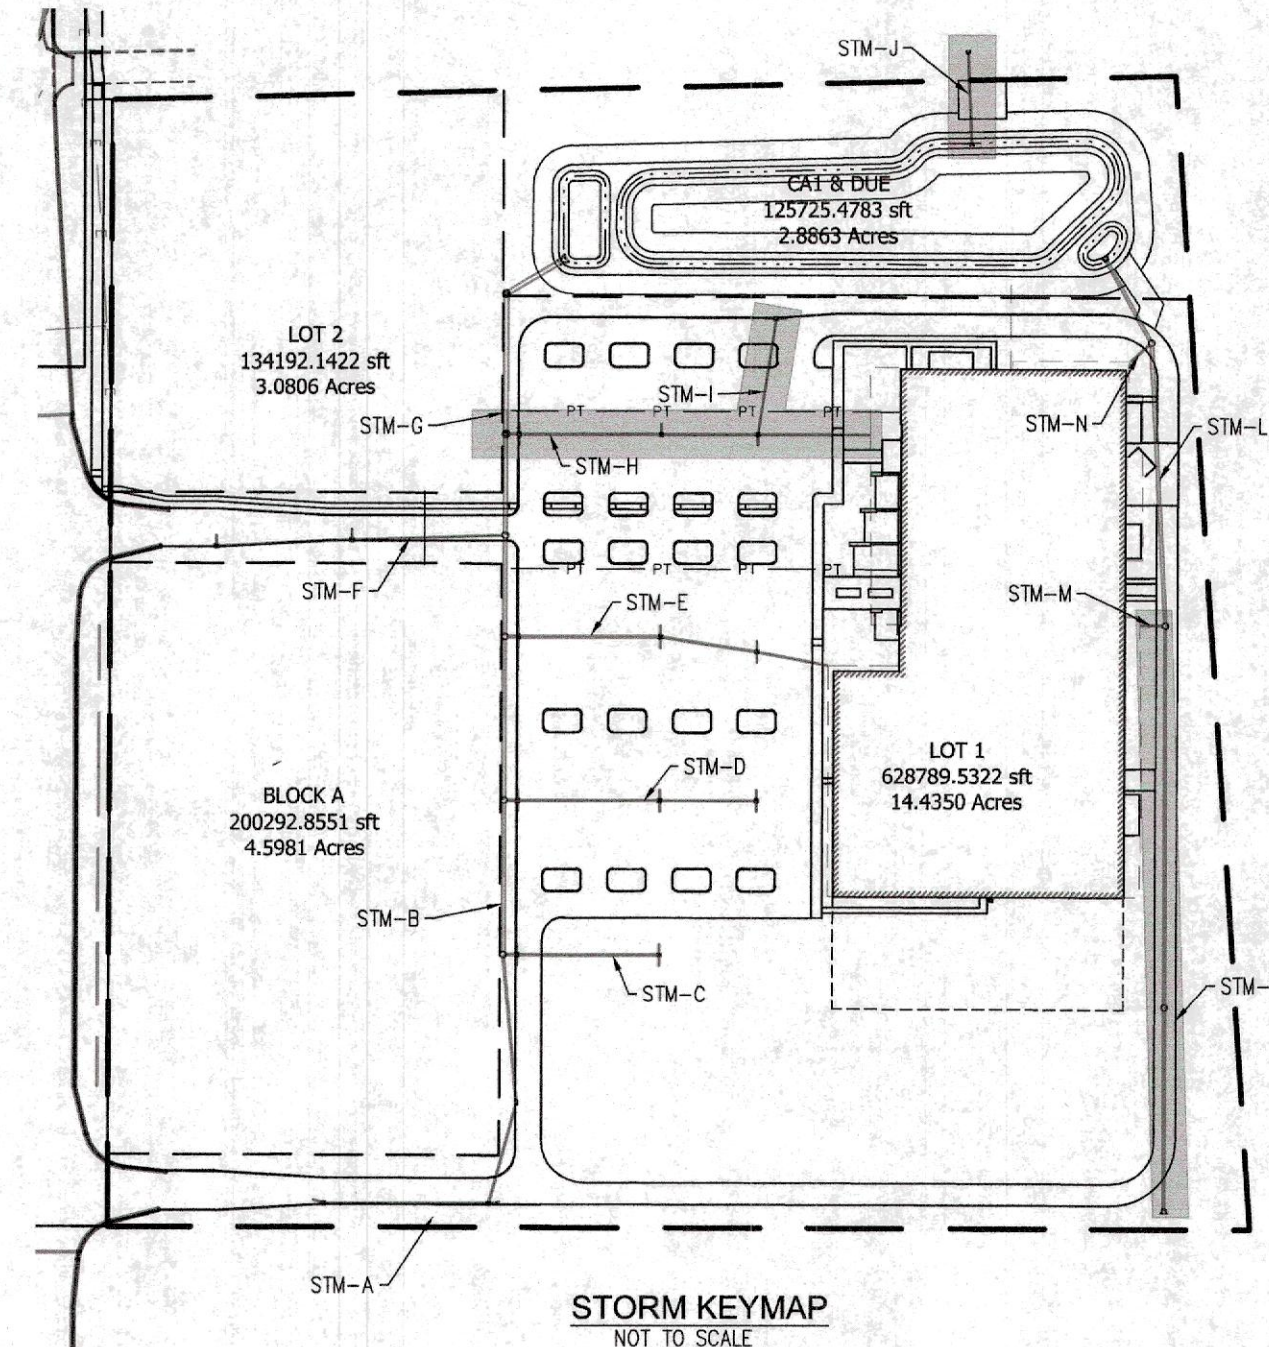
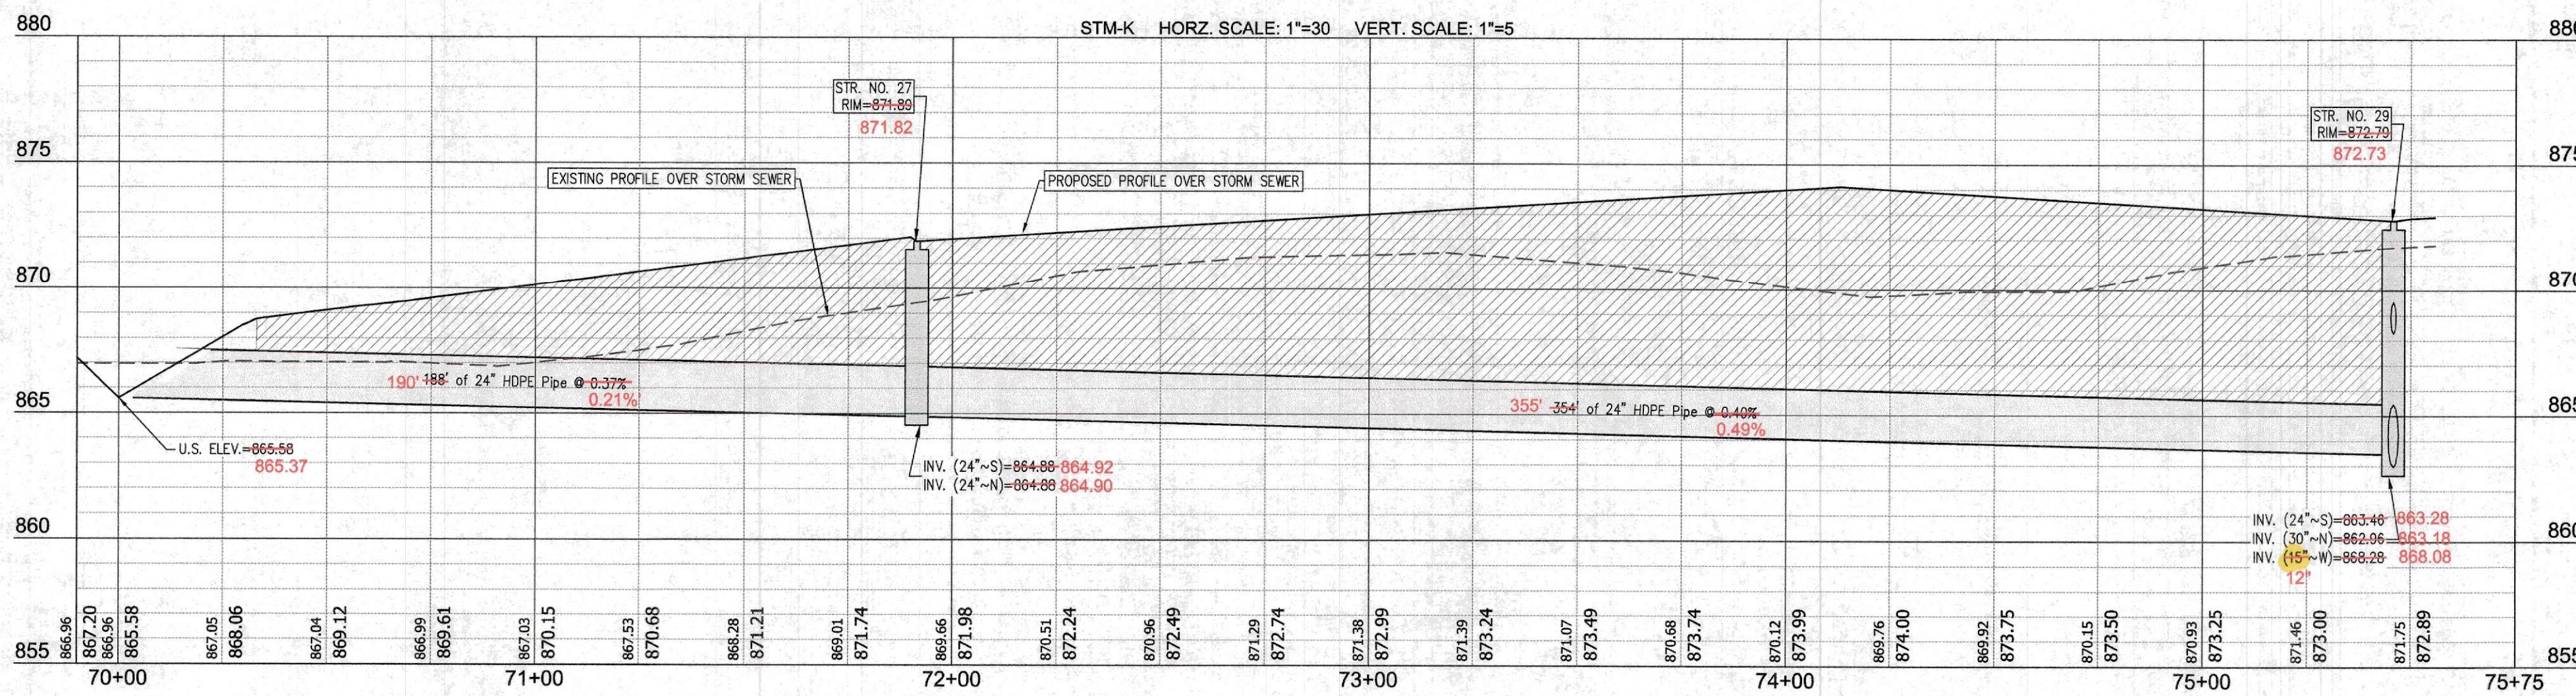
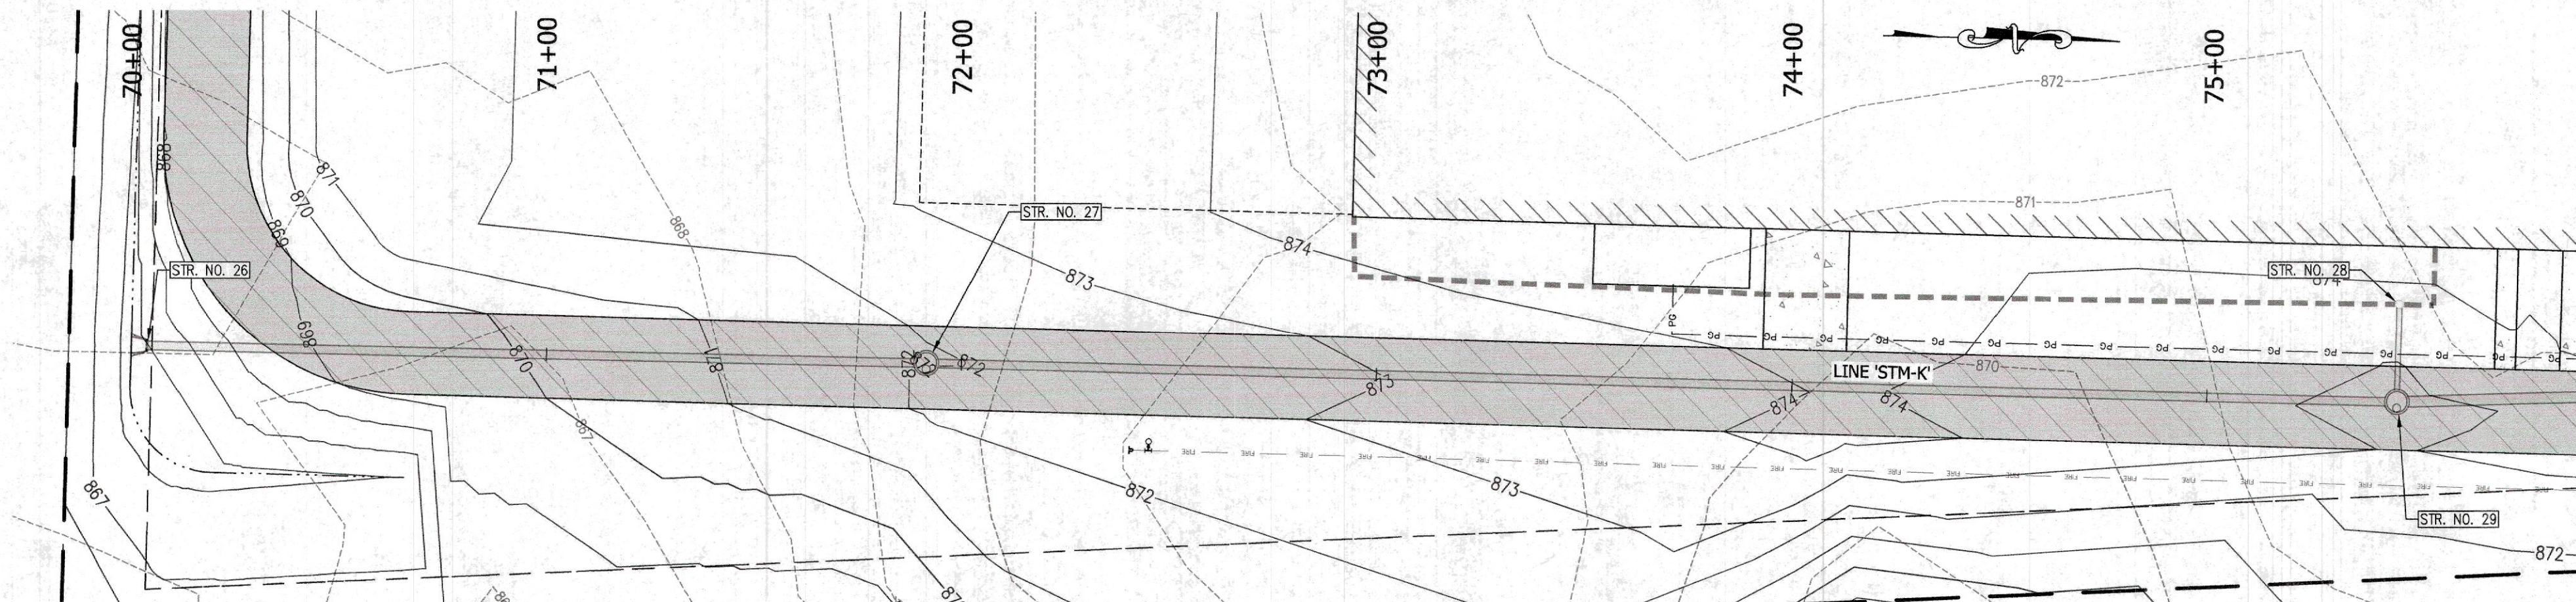
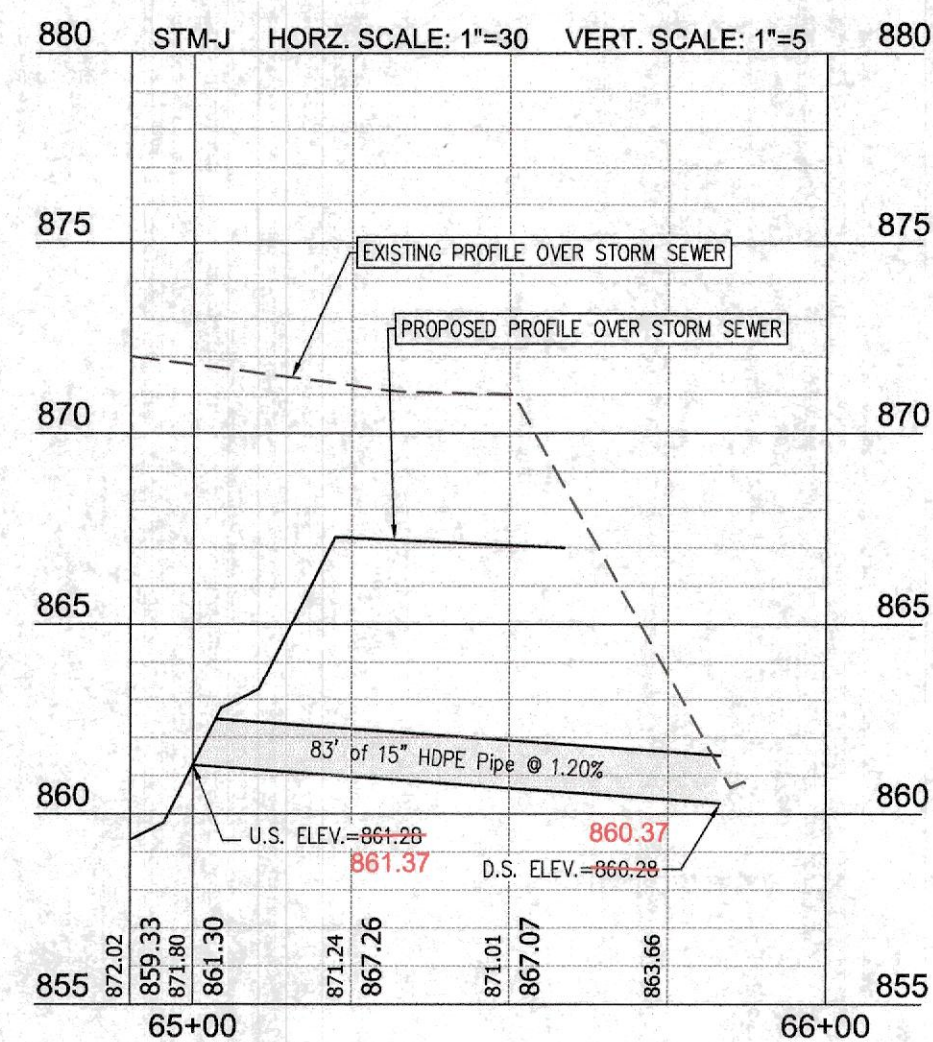
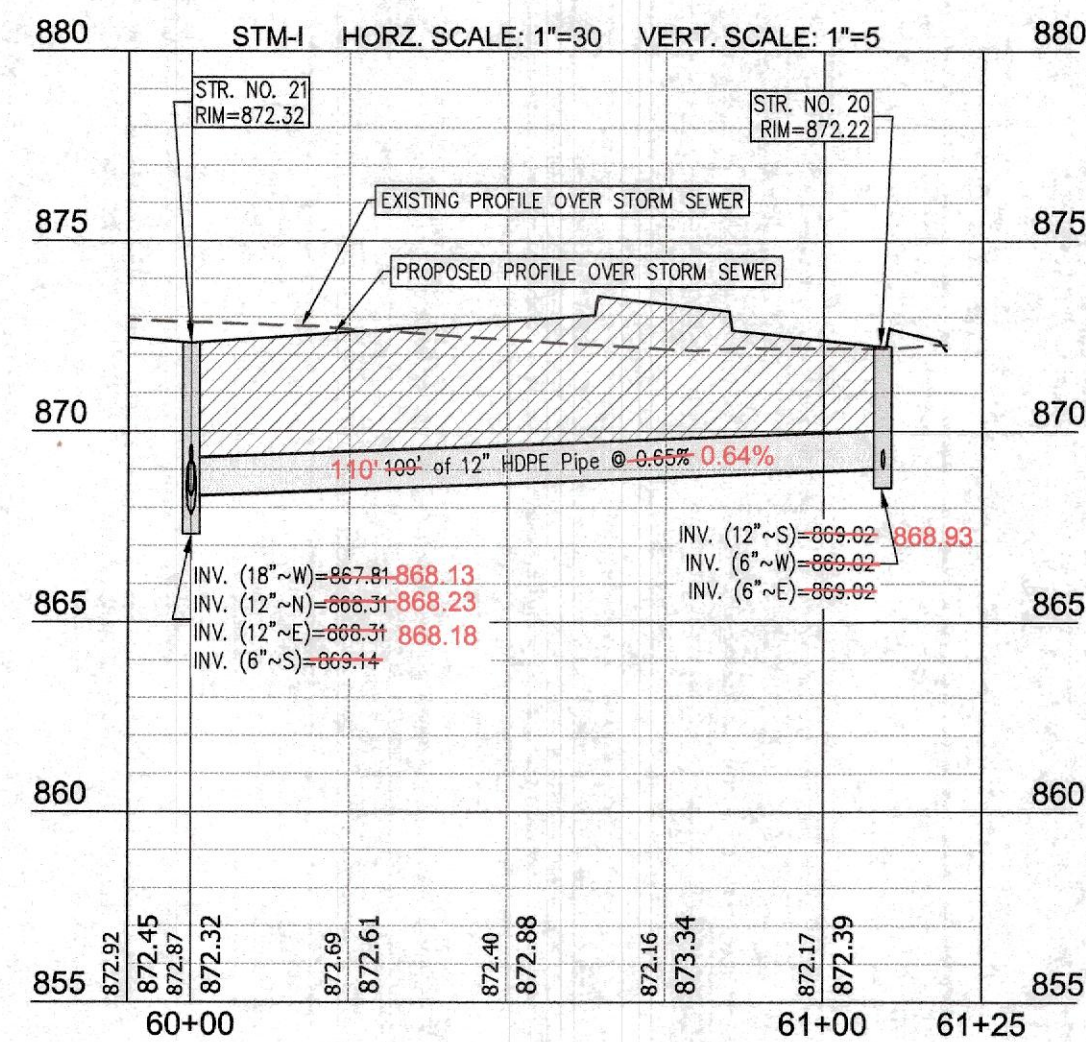
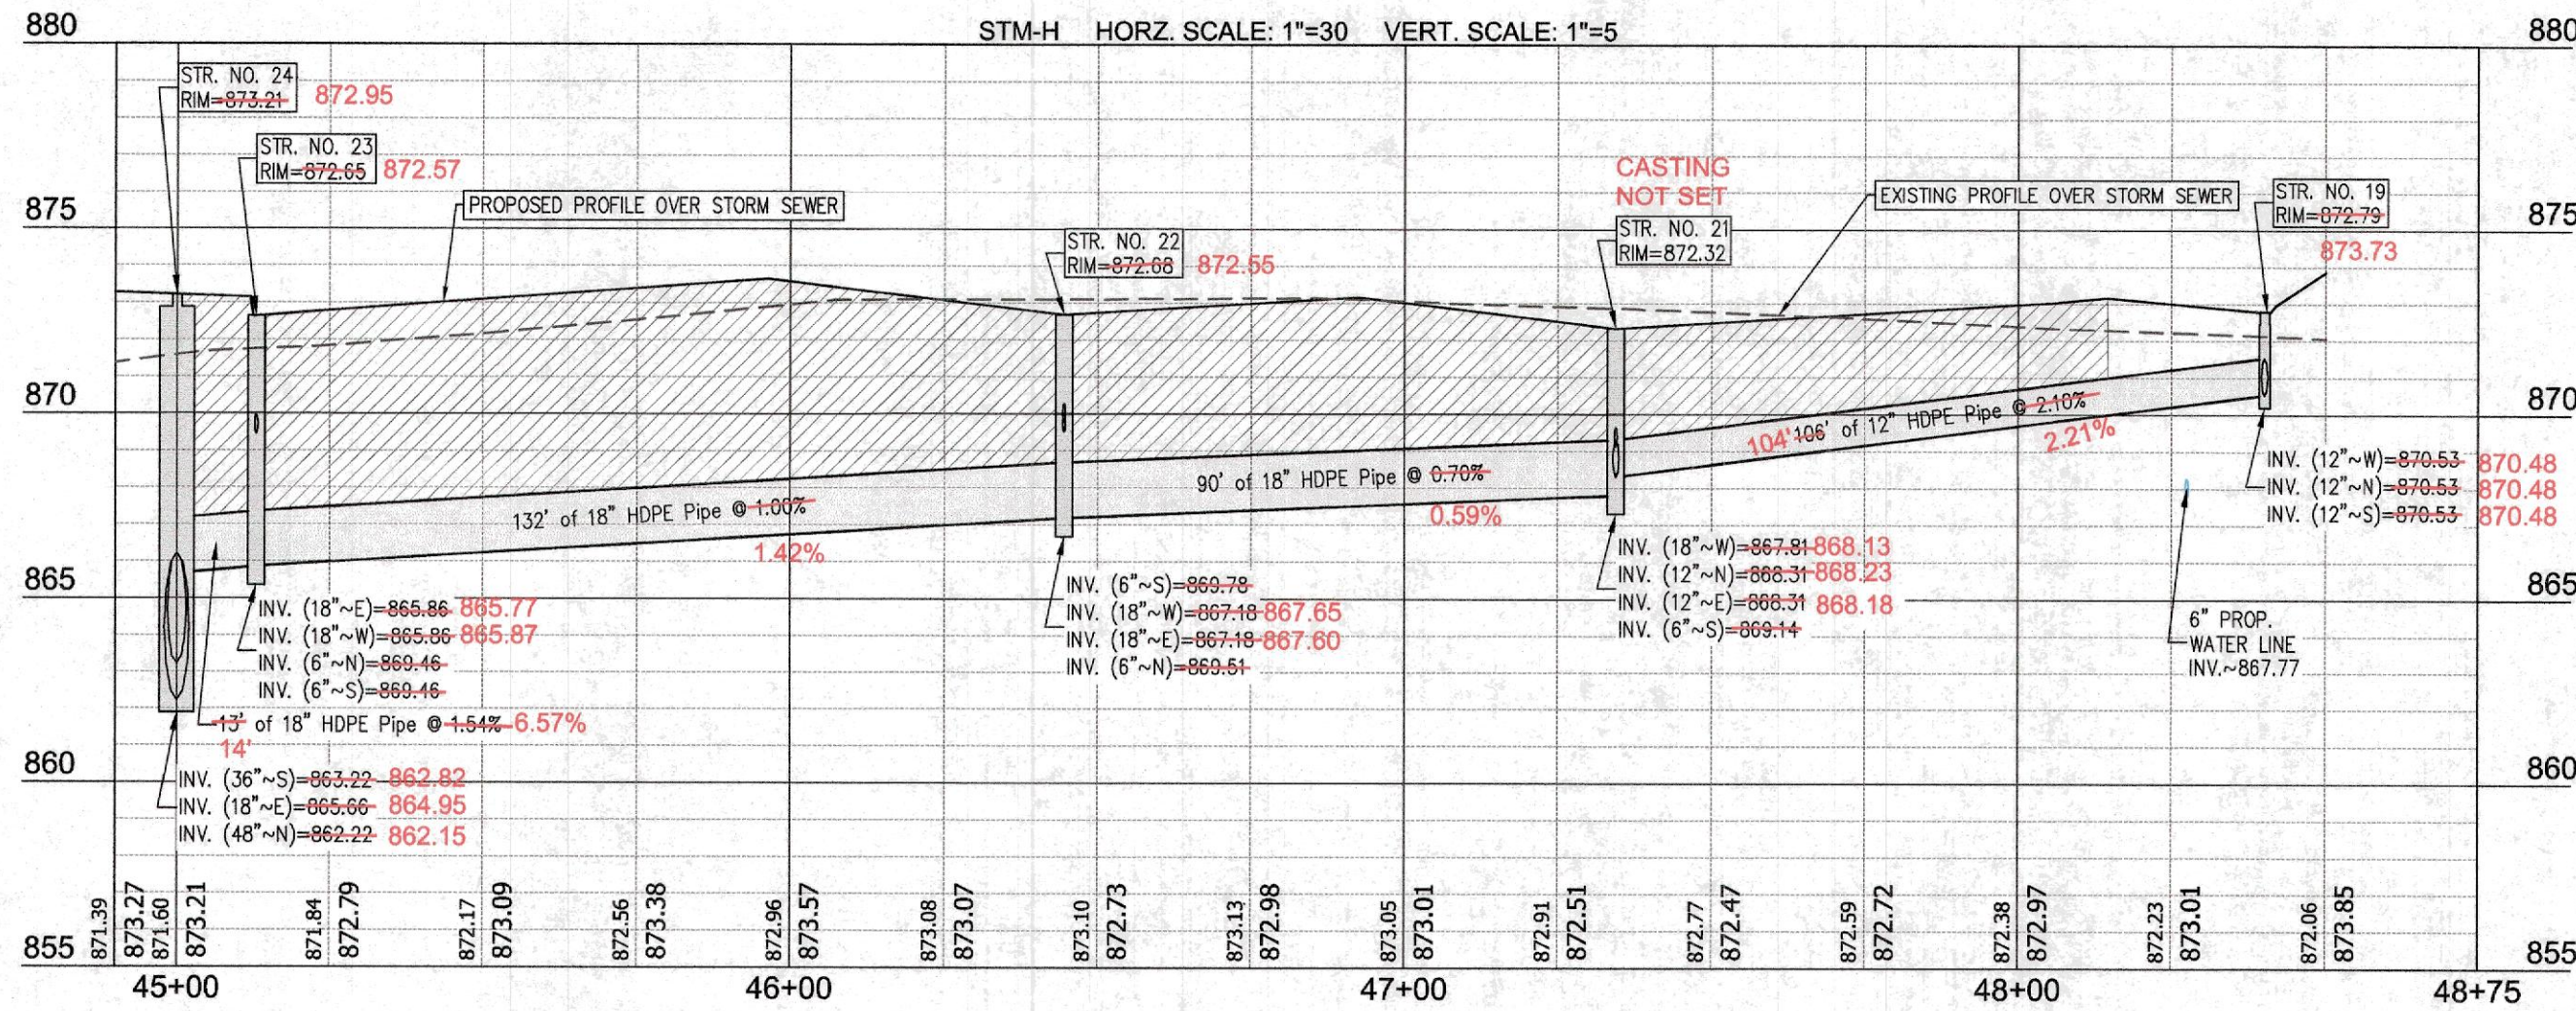
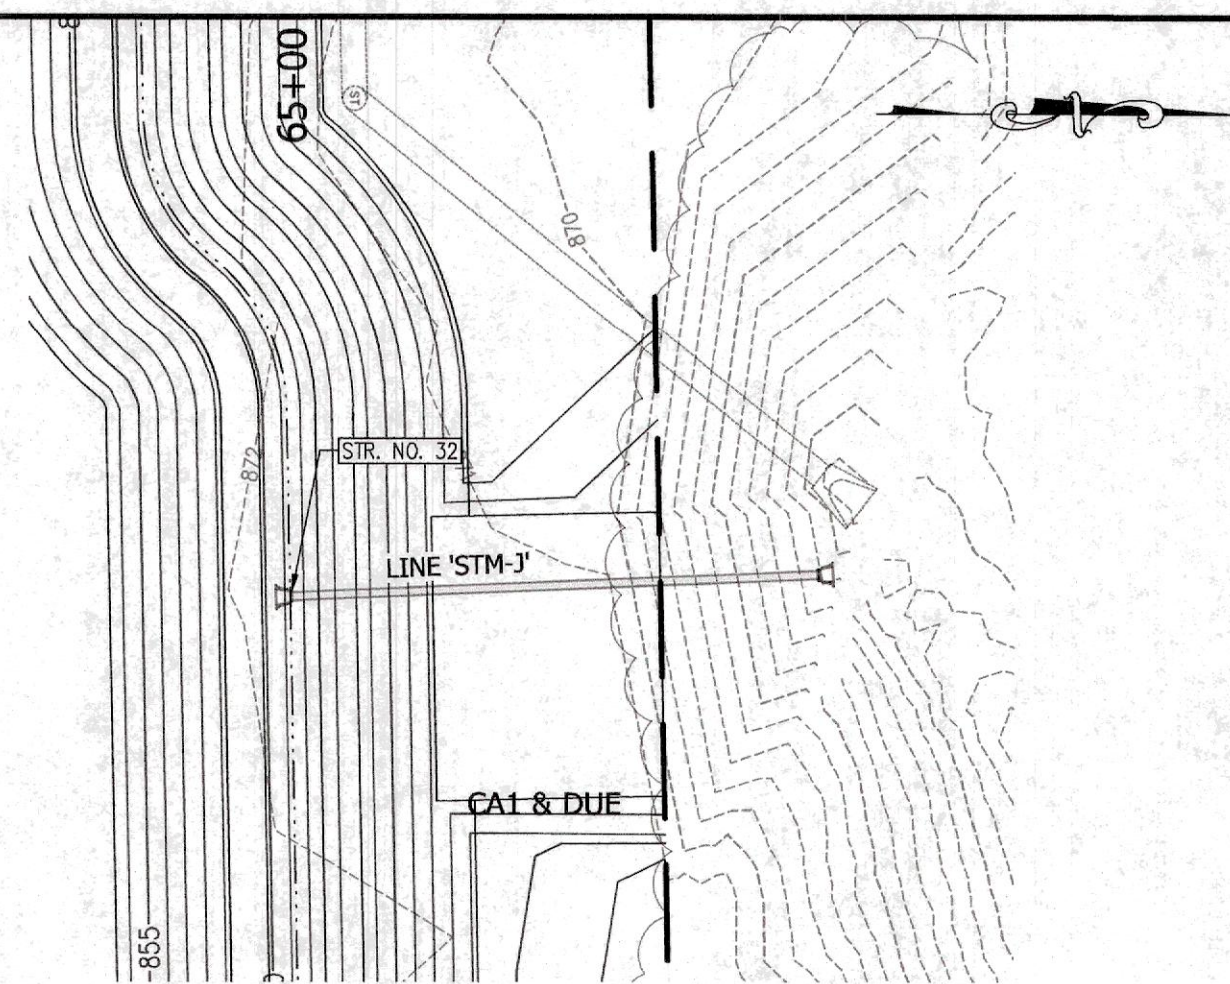


DIRECTORY PATH : P:\Projects\Land\Pendleton Wellness Center\Design\CAD\Plans
FILE NAME : 2025 STORM PLAN AND PROFILE
DATE/USER : 03/2019 11:30 AM / K59

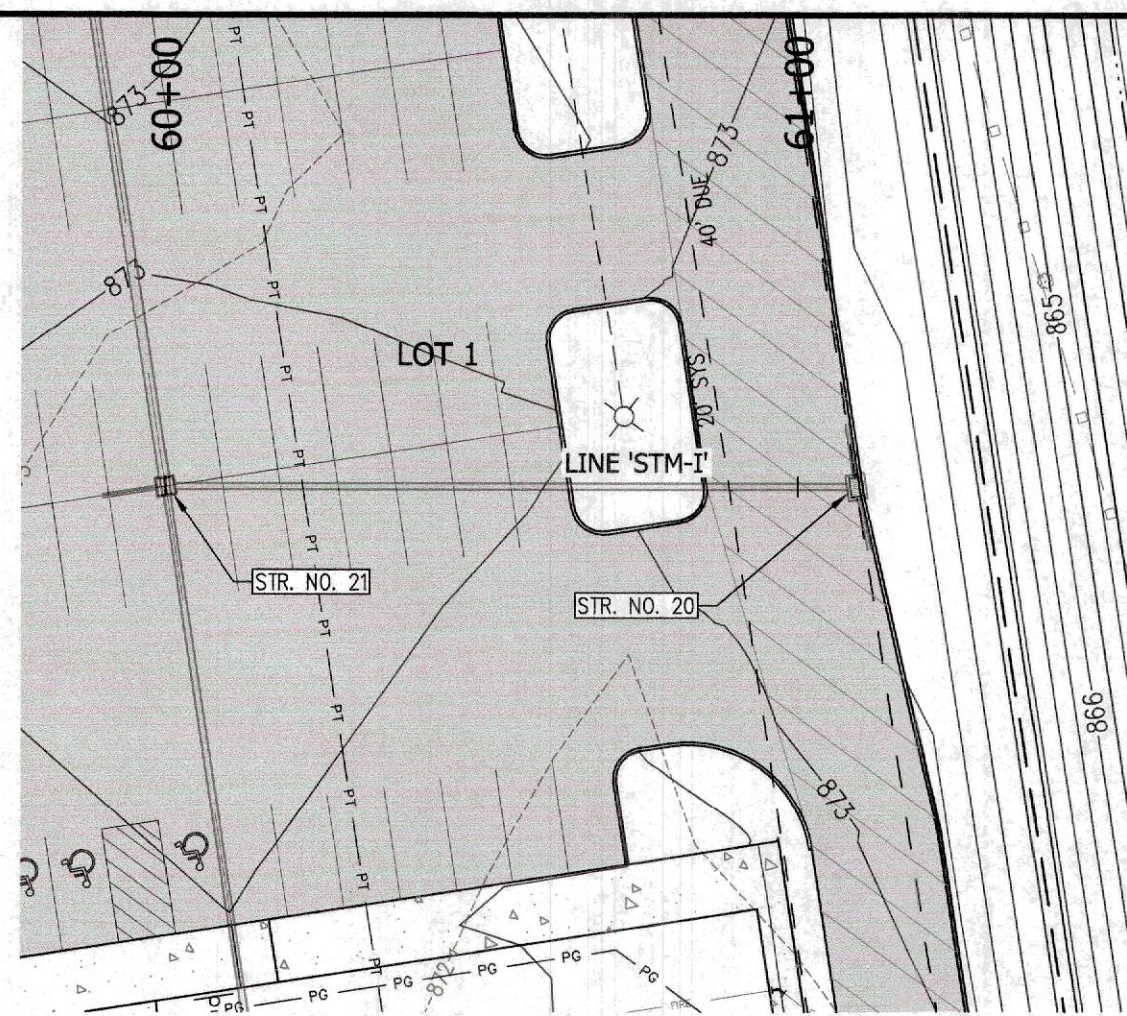

EXISTING UTILITY SIZE AND MATERIAL INFORMATION SHOWN ON THESE PLANS ARE PER THE BEST GRAPHICAL AND VISIBLE INFORMATION AVAILABLE. CONFLICTS MAY EXIST AND IT SHALL BE THE CONTRACTOR'S RESPONSIBILITY TO FIELD VERIFY ALL SIZING AND MATERIAL INFORMATION PROVIDED. IF ACTUAL CONDITIONS DIFFER FROM THAT INFORMATION SHOWN ON THE PLANS, THE CONTRACTOR SHALL, PRIOR TO THE INSTALLATION OF ANY PROPOSED INFRASTRUCTURE, NOTIFY THE DESIGN ENGINEER IMMEDIATELY.

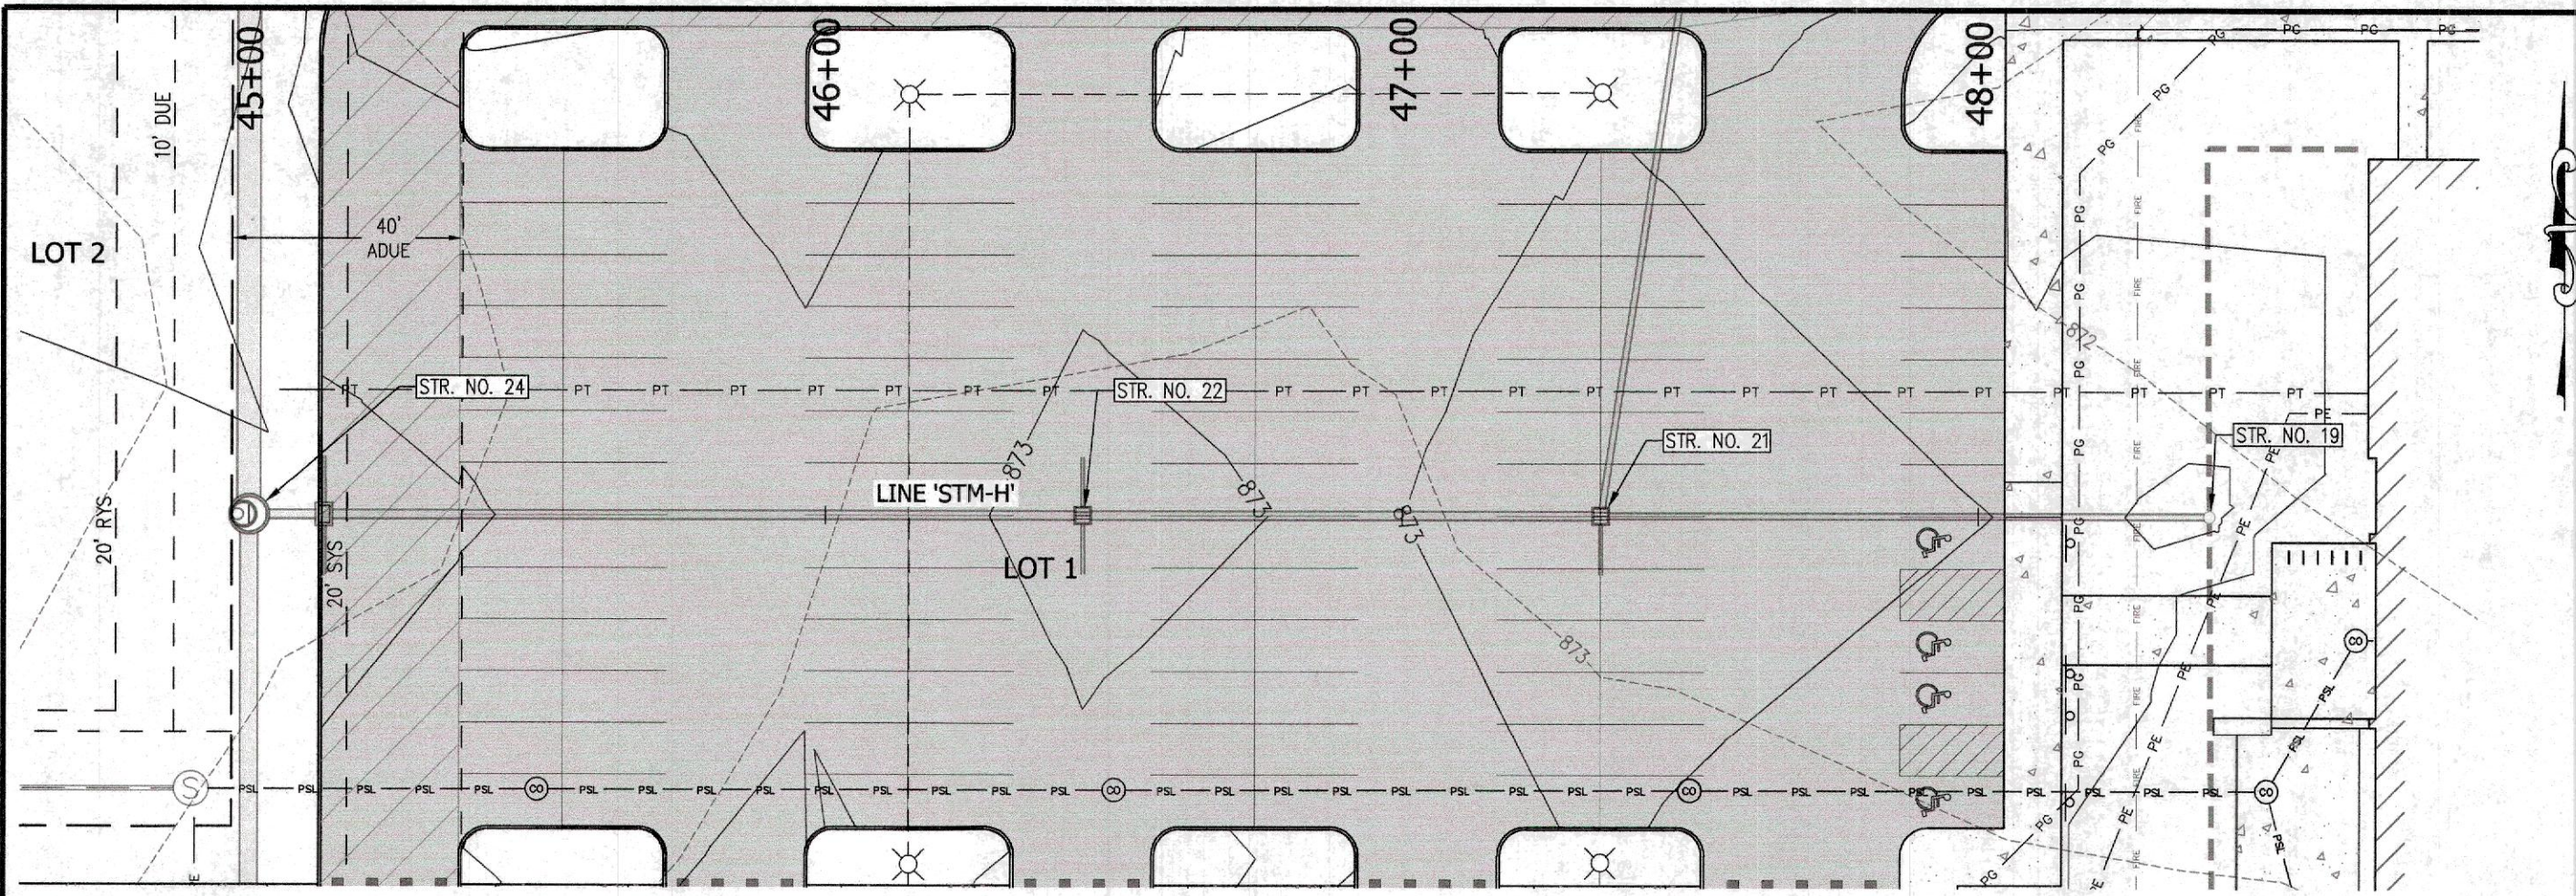

CROSSROAD ENGINEERS, PC
1415 S. 10TH AVE.
MILWAUKEE, WI 53214
TEL: 414.354.0000
FAX: 414.354.0001
WWW.CROSSROAD-PC.COM

STORM PLAN AND PROFILE

PENDLETON HEALTHPLEX

JOB NO.	DRAWN	LMC	CHECKED	TEN
DATE	SEPTEMBER 10, 2018	DESIGNED	DMS	CJ

DEBRA M. SWYDER

REGISTERED

NO. 1120008

STATE OF INDIANA

PROFESSIONAL ENGINEER

Debra M. Swyder

9	08.05.19	REVISIONS PER CLIENT & TOWN OF PENDLETON COORDINATION	DMS	CJ
8	02.12.19	REVISED TO INCLUDE (FOR N-SEAL FLEXIBLE BOOT CONNECTION TO SANITARY MH) STR. # SS-1 & ASPHALT PATH SECTION PER TOWN REQUIREMENTS	DMS	CJ
7	12.10.18	RAISED ENTIRE PROJECT (TOPOGRAPHIC SURVEY AND PROPOSED IMPROVEMENTS) C.S.F. FOR VERTICAL DATUM CORRECTION	DMS	CJ
6	11.26.18	ADDED SANITARY LATERAL STUDS FOR FUTURE CONNECTIONS AT LOT #2 AND BLOCK A	DMS	CJ
5	11.20.18	REVISIONS PER PLAN COMMISSION COMMENTS AND BANNING ENG. ROAD ALIGNMENT & PROFILE AND WATER LAYOUT PER CAD FILE DATED 11.13.18	DMS	CJ
4	10.08.18	REVISIONS PER TOWN OF PENDLETON AND MADISON CO. DRAINAGE BOARD (BANNING ENG.) COMMENTS	DMS	CJ
3	10.01.18	REVISIONS TO SANITARY SEWER PER F.C.R.I.D. COMMENTS	DMS	CJ
2	09.20.18	REVISIONS PER INTERNAL AND OWNER REVIEWS	DMS	CJ
1		REVISIONS	BY	APPR.

SHEET

702