

Notes:

All sewers, manholes, and castings shall be per Fall Creek Regional Waste District specifications. All sewers plans comply with the Town of Pendleton Stormwater Management Ordinance and the Stormwater Design Manual.

It shall be the responsibility of contractor to verify existing utility locations and conditions. It shall also be the contractor's responsibility to contact the various utilities for proper staking and locations for each prior to construction.

All disturbed areas to be restored to existing or better condition.

It shall be the contractor/installer responsibility for contacting all permit issuing agencies within the time frame specified by that agency prior to any construction.

All open cut shall be in compliance with AWWA C605.

All construction activity on this site are to be performed in compliance with OSHA standards.

There is to be a minimum of 10 feet horizontal separation and 18 inches vertical separation between the sanitary sewer and the water line.

Any sanitary sewer and storm sewer crossings with less than 2 feet of vertical separation shall be concrete encased.

All sanitary sewer mains 15 feet and deeper use SDR-26 pipe. All other sanitary sewer mains use SDR-35 pipe. Unless otherwise noted.

All mechanical joints to be restrained joints.

Symbols are not to scale. Location shown for graphical purposes only.

COMMITMENT: Developer Shall Provide Lift Station Access Internal to the Development Prior to the Extension of N Heritage Way and Removal of Temporary Access Drive. (Not Part of This Phase)

EXISTING

X FENCE LINE

S SANITARY SEWER

E ELECTRIC UNDERGROUND

T TELEPHONE LINE

OHU OVERHEAD UTILITIES

OHE OVERHEAD ELECTRIC

G GAS LINE

W WATER LINE

ST STORM SEWER

ST STORM STRUCTURES

SM SANITARY MANHOLE

FOM FIBER OPTIC MARKER

ET ELECTRIC TRANSFORMER

LEGEND

EM ELECTRIC METER

FH FIRE HYDRANT

WV WATER VALVE

GV GAS VALVE

GV GAS VENT / MARKER

LP LIGHT POLE

SG SIGN

UP UTILITY POLE

DG DOWN GUY

MB MAILBOX

TS TELEPHONE STRUCTURE

TS TREES / SHRUBS

TL TREELINE

PROPOSED

E ELECTRIC SERVICES



X WOOD FENCE

F SANITARY FORCE MAIN

S SANITARY SEWER

AV AIR RELEASE VALVE

SM SANITARY MANHOLE

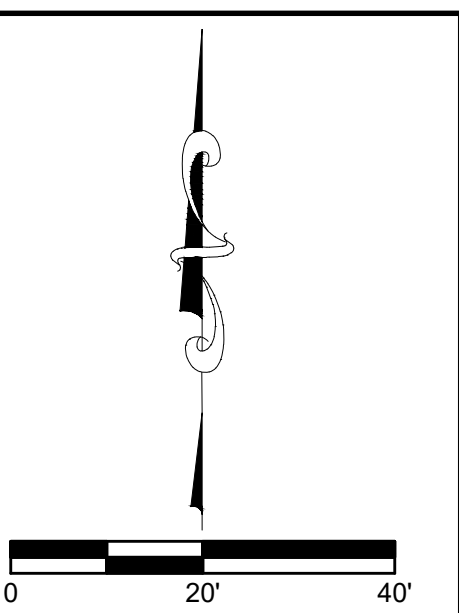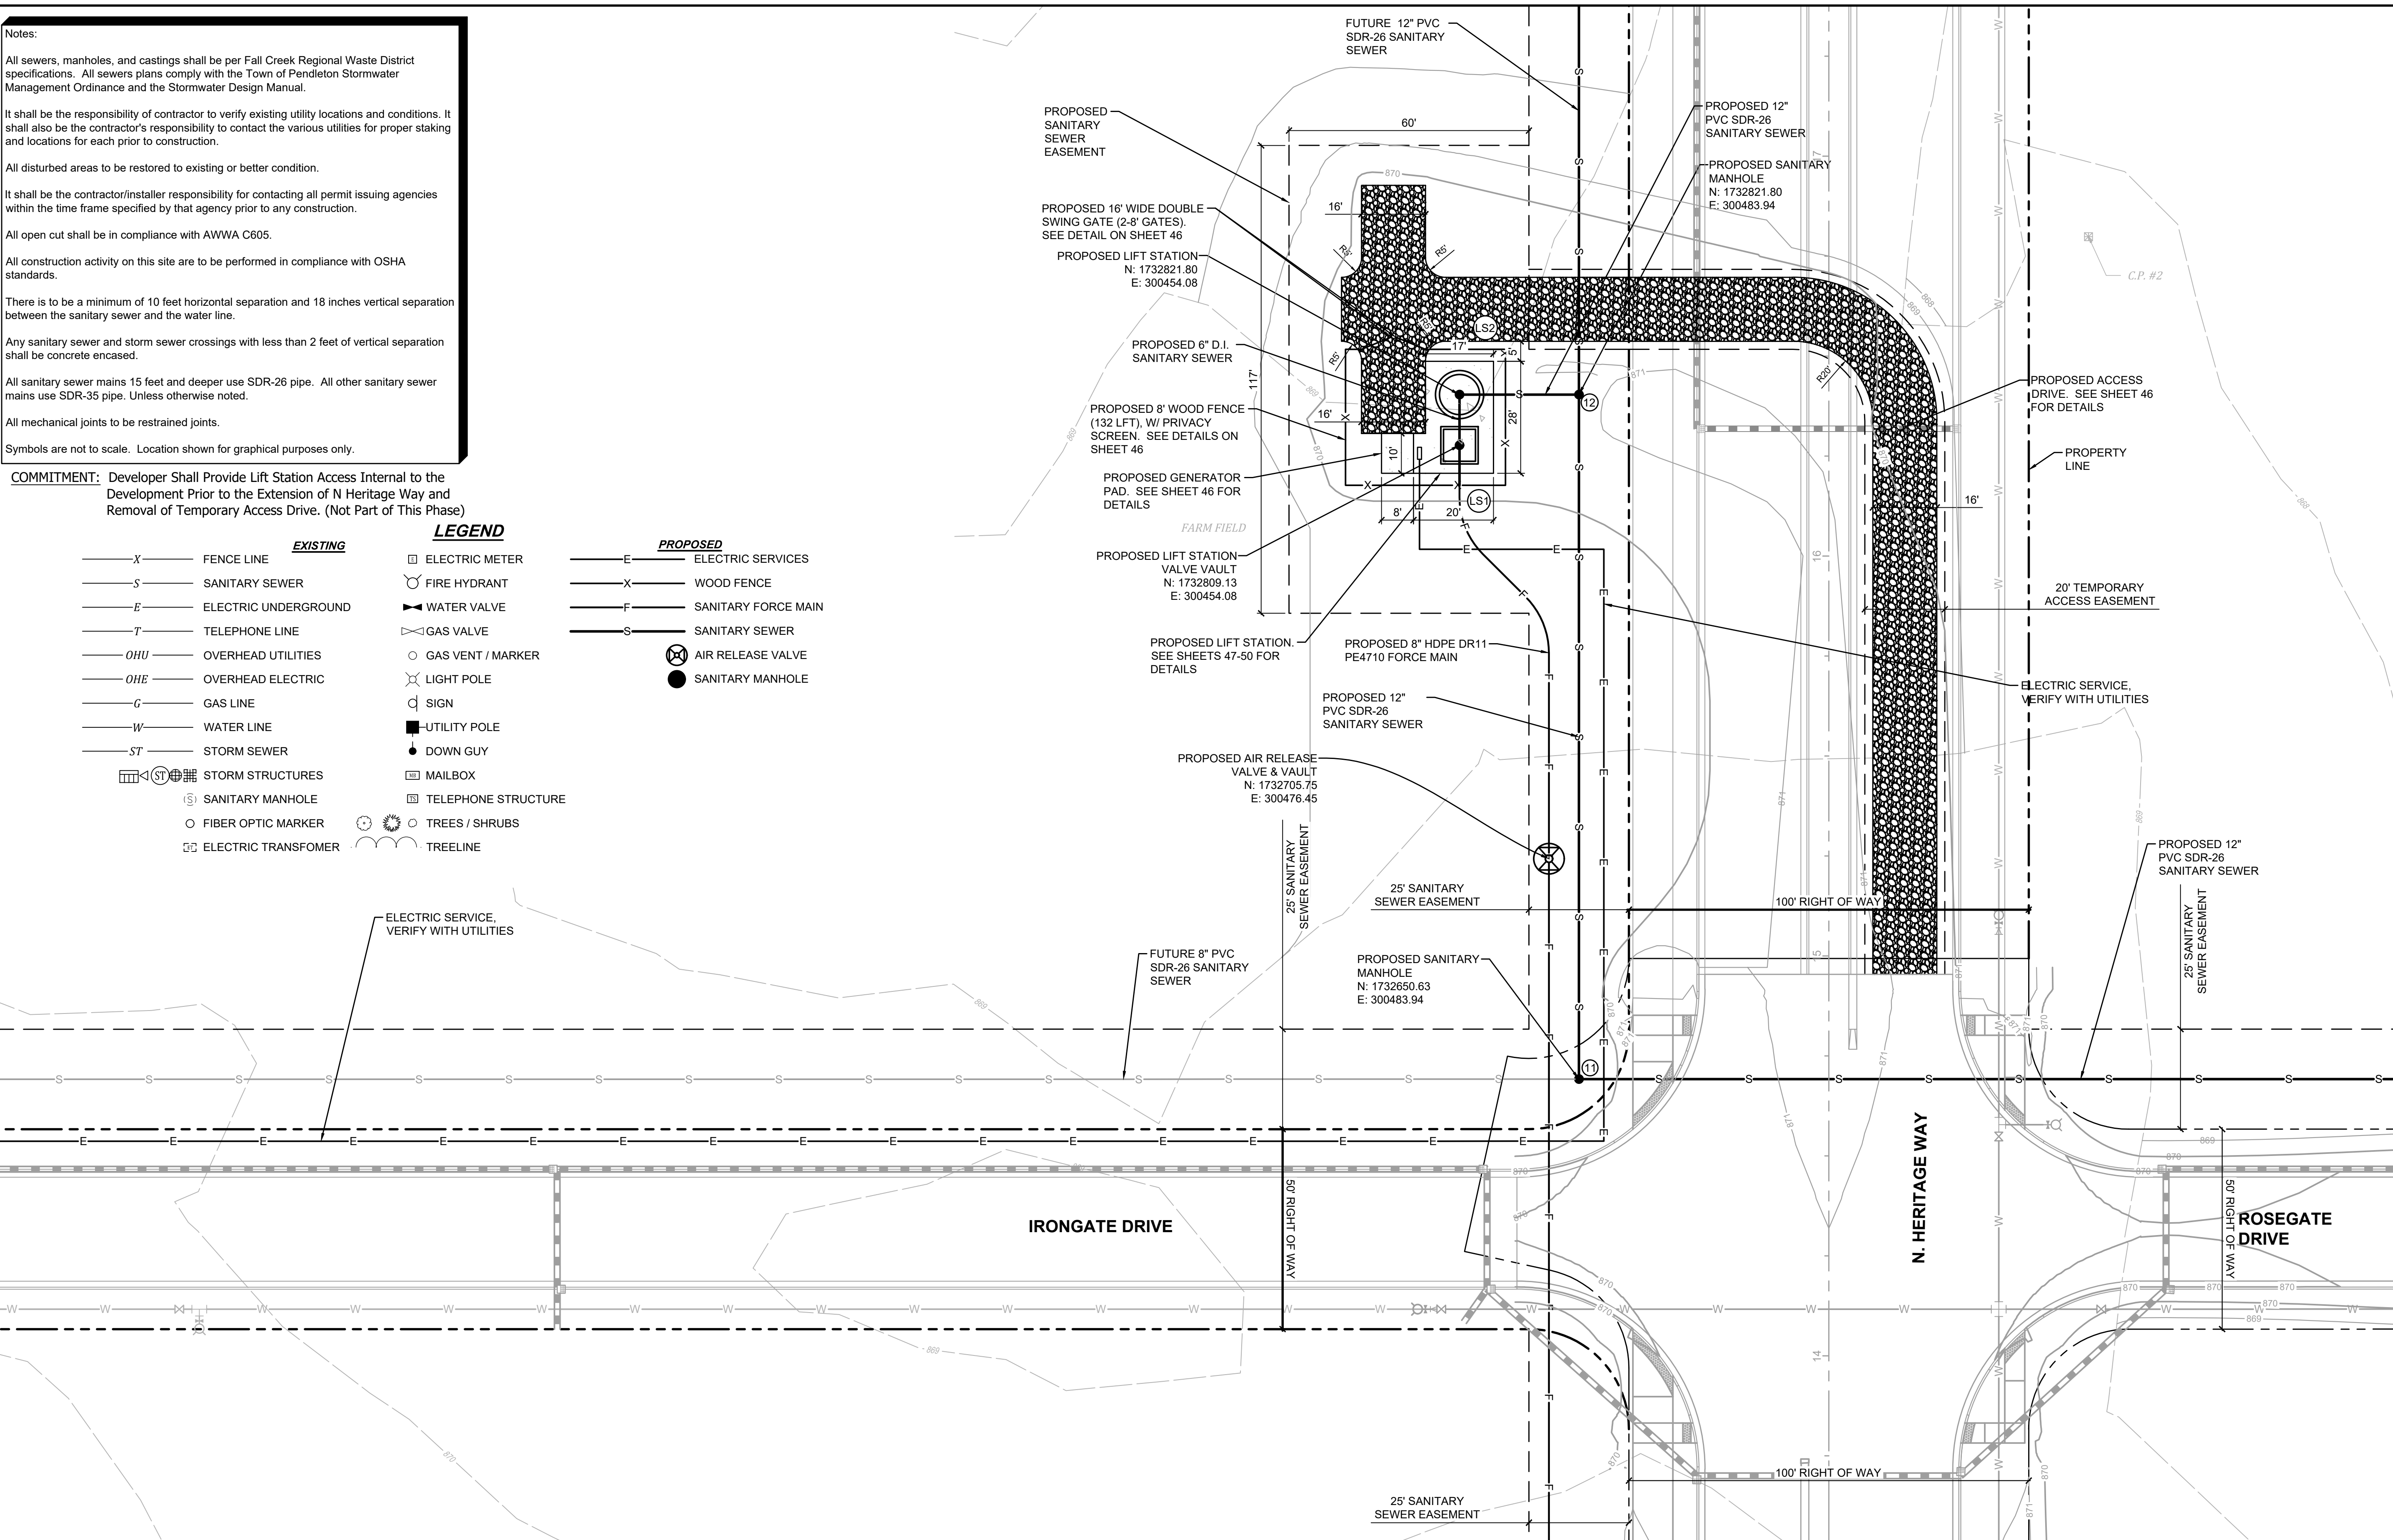

BANNING
ENGINEERING

853 COLUMBIA ROAD, SUITE #101
PLAINFIELD, IN 46168

BUS: (317) 707-3700, FAX: (317) 707-3800
E-MAIL: Banning@BanningEngineering.com
WEB: www.BanningEngineering.com

NOT FOR
CONSTRUCTION

RECOMMENDED FOR APPROVAL _____ DESIGN ENGINEER	
DESIGNED: _____	DRAWN: _____
CHECKED: _____	CHECKED: _____

KULKARNI PROPERTIES	
LIFT STATION SITE PLAN	

HORIZONTAL SCALE	BRIDGE FILE
1" = 20'	N/A
VERTICAL SCALE	DESIGNATION
NONE	N/A
SURVEY BOOK	SHEET
N/A	39 of 51
CONTRACT	PROJECT
N/A	24073