


HOOSIER HILLS REGIONAL WATER DISTRICT
DIVISION "F" WATERWORKS SYSTEM IMPROVEMENTS
CONTRACT "F-2":
SUPPLY METERS, PUMP STATIONS / INSTALL TELEMETRY

SITE VICINITY MAP

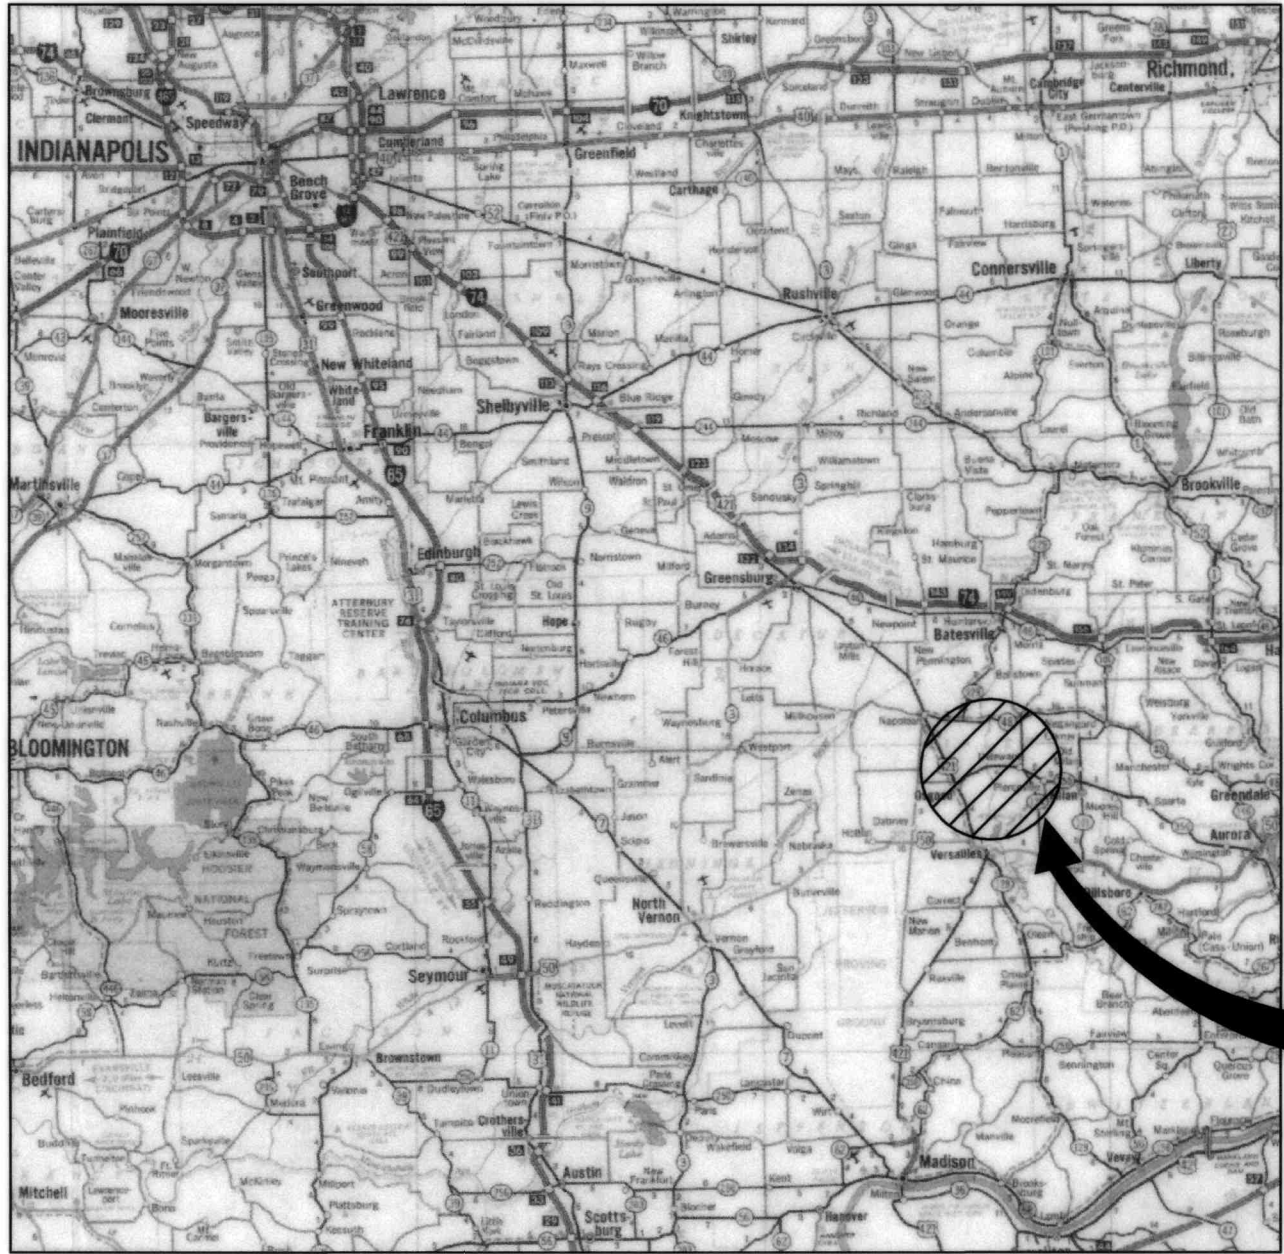


PROJECT LOCATION

RECORD DRAWING

This drawing has been revised from the original contract drawings to show minor / major changes made during construction. This drawing is not warranted to be complete and accurate in all respects.

GRW Engineers, Inc.


Date: GCR By: 5/2004

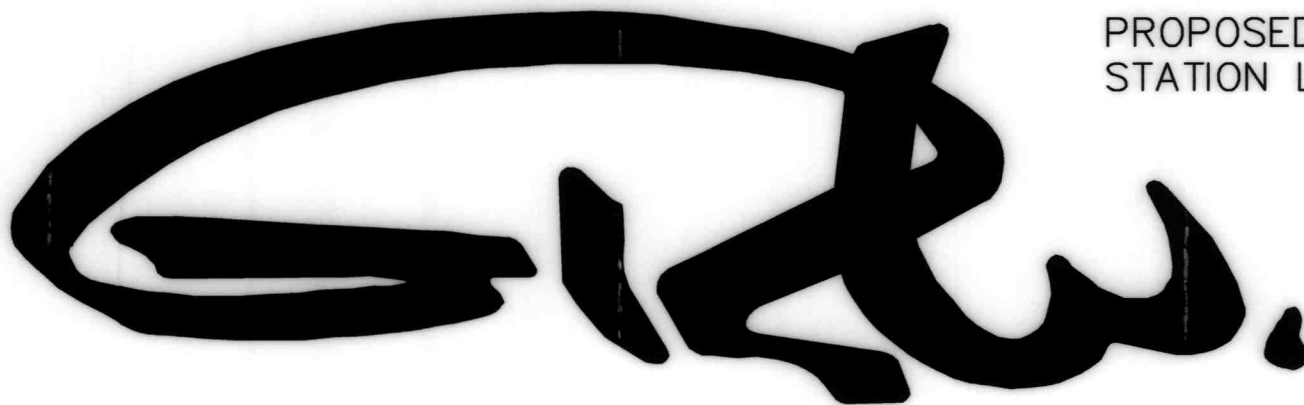

GRW Engineers, Inc.
7112 WALDEMAR DRIVE
INDIANAPOLIS, IN. 46268
(317) 347-3650

INDIANAPOLIS, INDIANA
LEXINGTON & LOUISVILLE, KENTUCKY
NASHVILLE, TENNESSEE
ARLINGTON, TEXAS
CINCINNATI, OHIO
JULY 2002

SITE LOCATION MAP

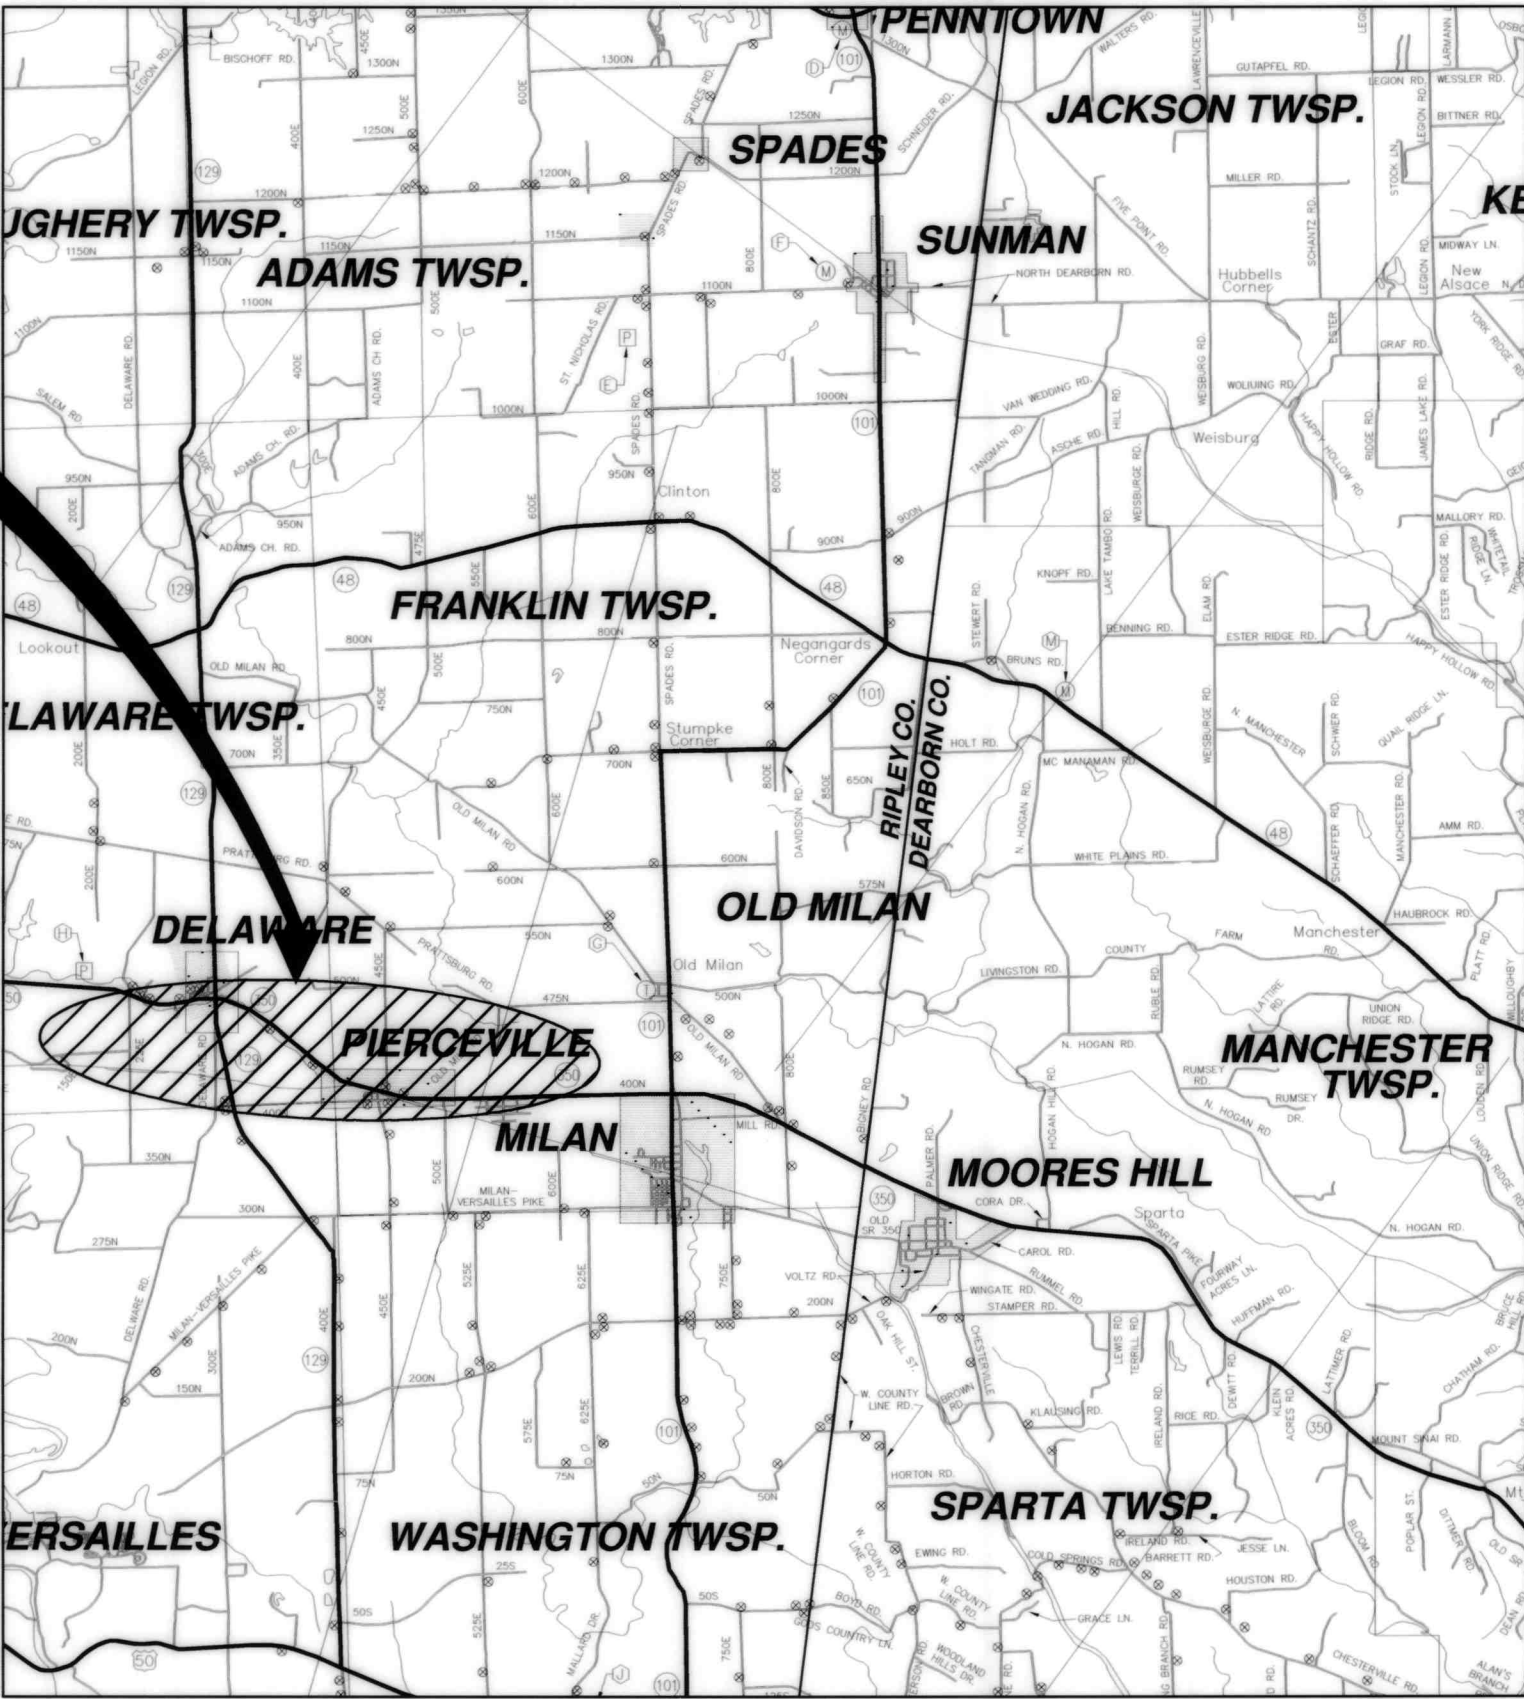

PROPOSED PUMP
STATION LOCATIONS


INDEX OF DRAWINGS

SHEET NO.	DESCRIPTION	E-3/584	ELEC. 1/C PLAN WATER TREATMENT PLANT IMPROVEMENTS
---	COVER SHEET	E-4/585	WATER TREATMENT PLANT INSTRUMENTATION/CONTROL DETAILS
576	PIERCEVILLE PUMP STATION PLAN AND SECTIONS (DELETED)	E-5/586	PIERCEVILLE PUMP STATION 1/C SITE PLAN
577	PIERCEVILLE PUMP STATION DETAILS (DELETED)	E-6/587	OSGOOD MASTER METER AND PUMP STATION ELEC. SITE PLAN (DELETED)
578	OSGOOD METER/PUMP STATION PLAN (DELETED)	E-7/588	ELROD TANK 1/C SITE PLAN/MILAN MASTER METER 1/C SITE PLAN
579	MILAN MASTER METER VAULT PLAN AND DETAILS	E-8/589	SPADES ROAD 1/C SITE PLAN AND DETAILS
580	ELROD ALTITUDE VALVE STATION	E-9/590	SOUTH MILAN TANK 1/C SITE PLAN
581	SPADES ROAD PUMP STATION REHAB (DELETED)	E-10/591	METAMORA TANK 1/C SITE PLAN AND DETAILS
604	SPADES ROAD PUMP STATION PLAN	E-11/592	TYPICAL WATER STORAGE TANK RTU PANEL DETAILS
605	SPADES ROAD PUMP STATION PLAN	E-12/593	TYPICAL PUMP STATION RTU PANEL DETAILS
E-1/582	SCADA SYSTEM OVERVIEW	E-13/594	WELLFIELD RTU PANEL DETAILS
E-2/583	OFFICE SCADA SYSTEM FLOOR PLAN WATER TREATMENT PLANT IMPROVEMENTS	E-14/595	OLD MILAN TANK 1/C SITE PLAN AND DETAILS

HOOSIER HILLS REGIONAL WATER
DISTRICT BOARD OF DIRECTORS

GREGORY DOLE - PRESIDENT
ANDREW WEISENBACH - VICE PRESIDENT
HELEN GRIGSBY - TREASURER
ALREENA HORTON - SECRETARY & ASST. TREASURER
CHUCK FOLZ - BOARD MEMBER
TED MEER - BOARD MEMBER
WILLIAM SHECKLES - BOARD MEMBER
JOHN J. AMBERGER - BOARD MEMBER
WILLIAM BLYSHAK - BOARD MEMBER
SCOTT STIRN - GENERAL MANAGER

GREGORY A. WRIGHT, P.E.
INDIANA REG. NO. 19300607
DATE 5/2004

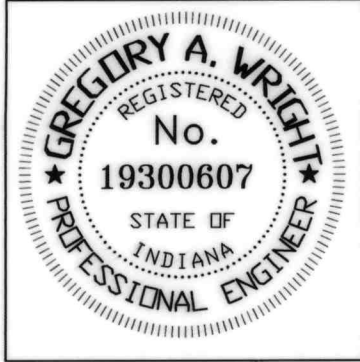

GRW PROJECT NO. 2745-04