

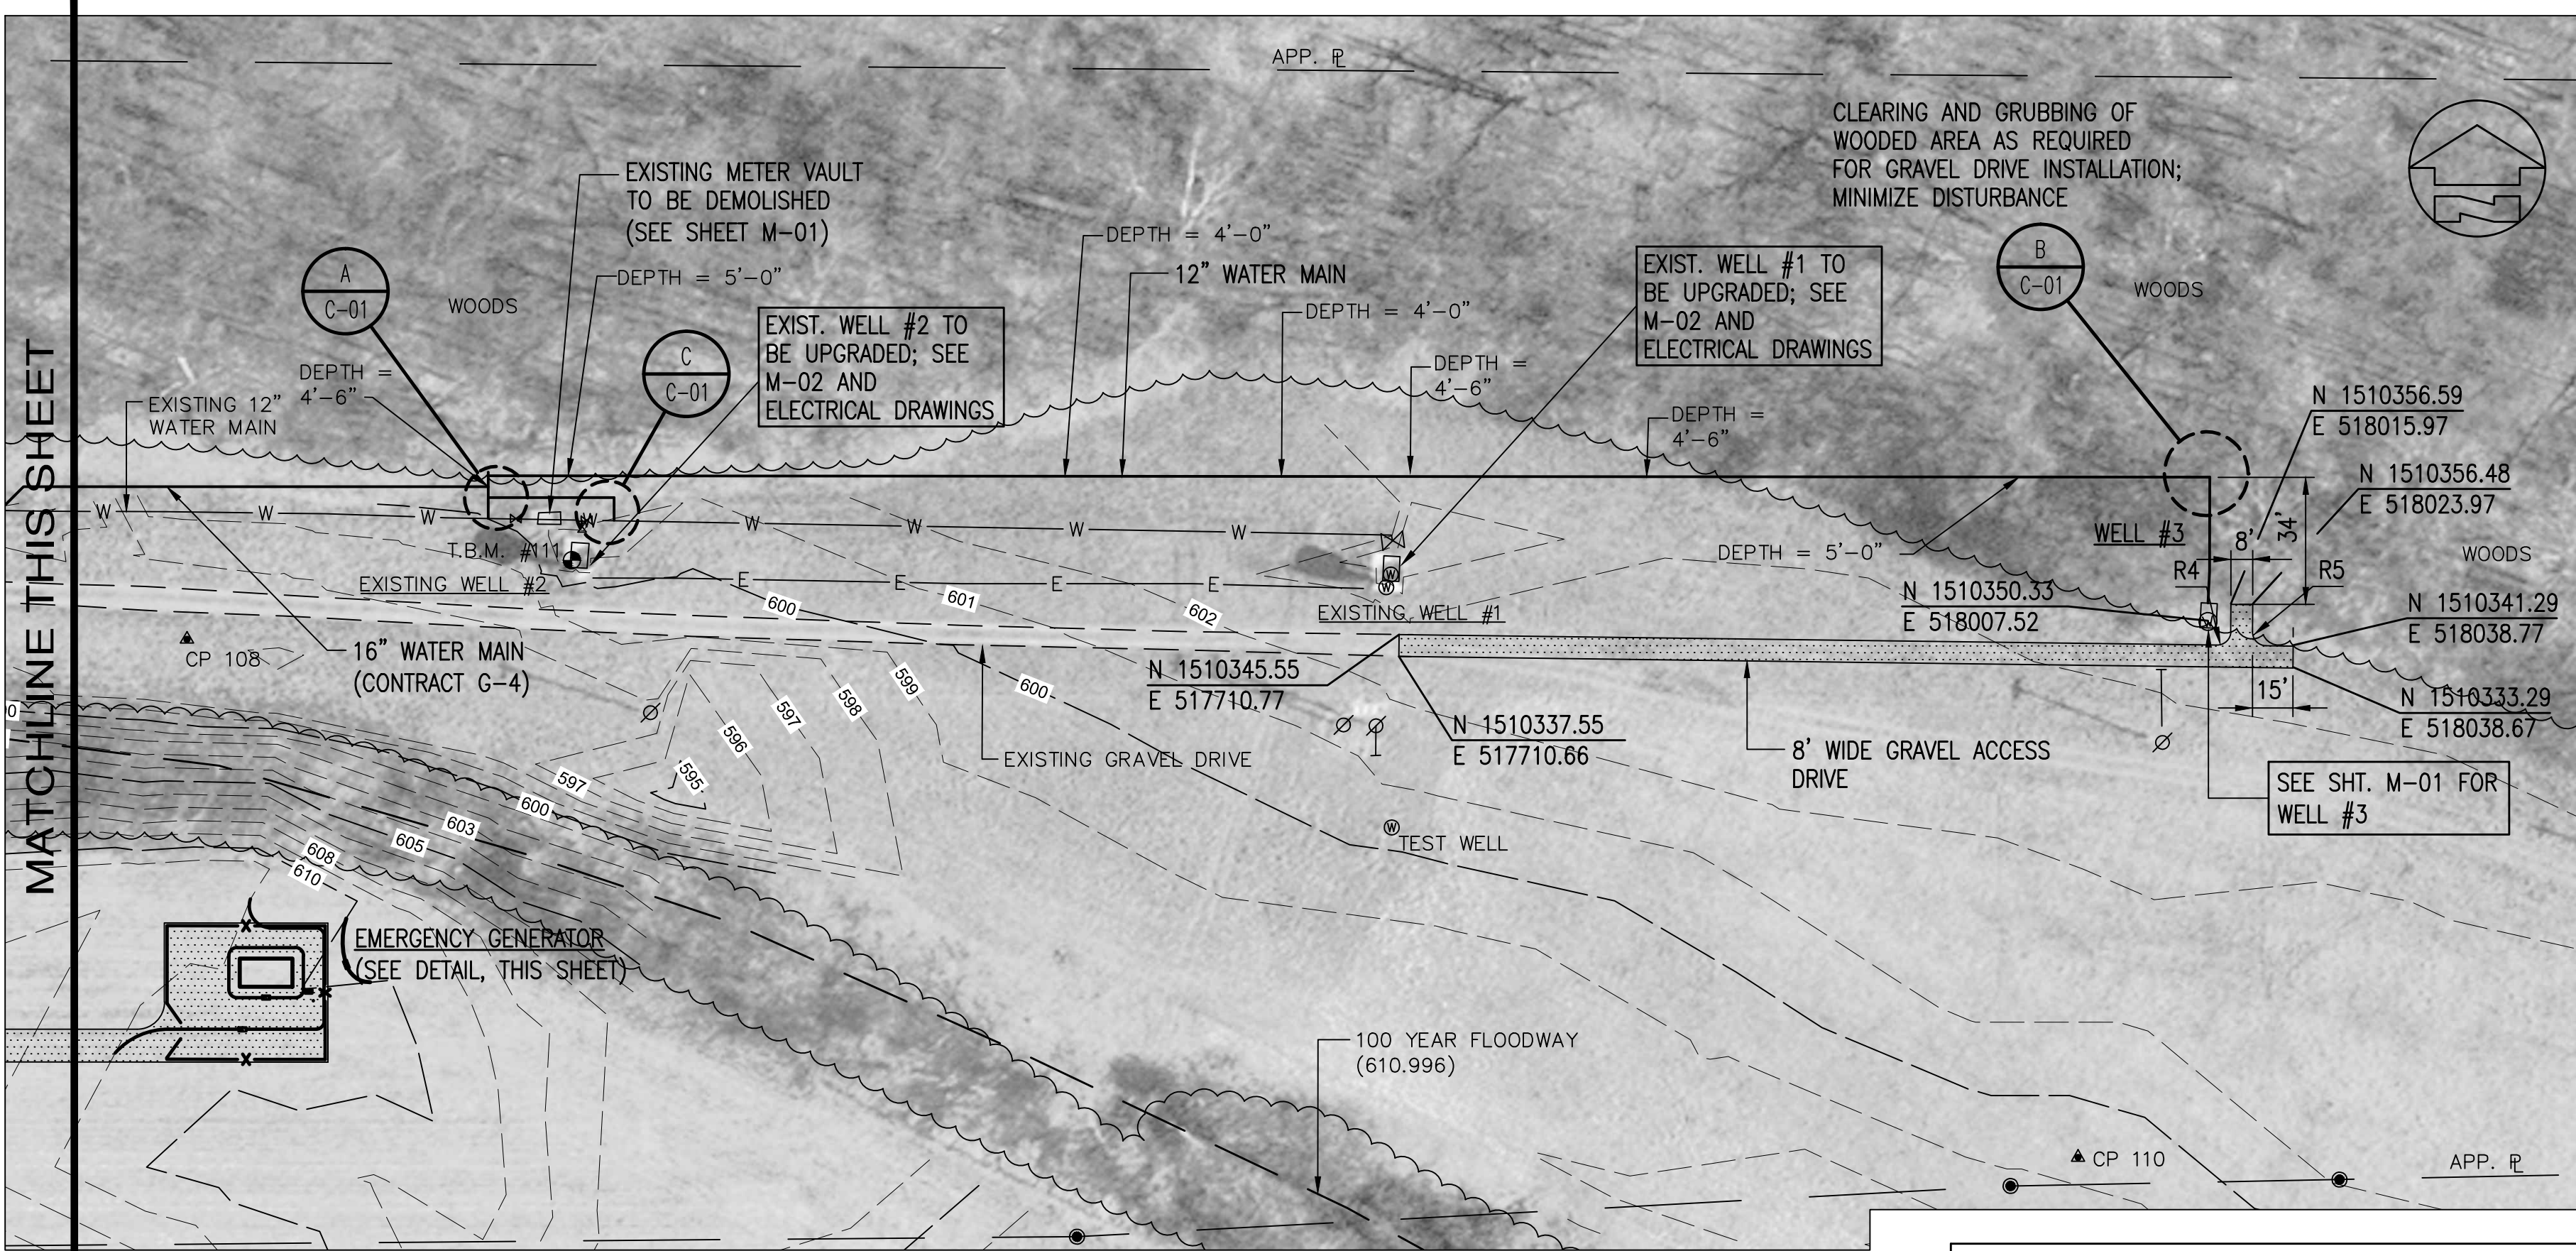
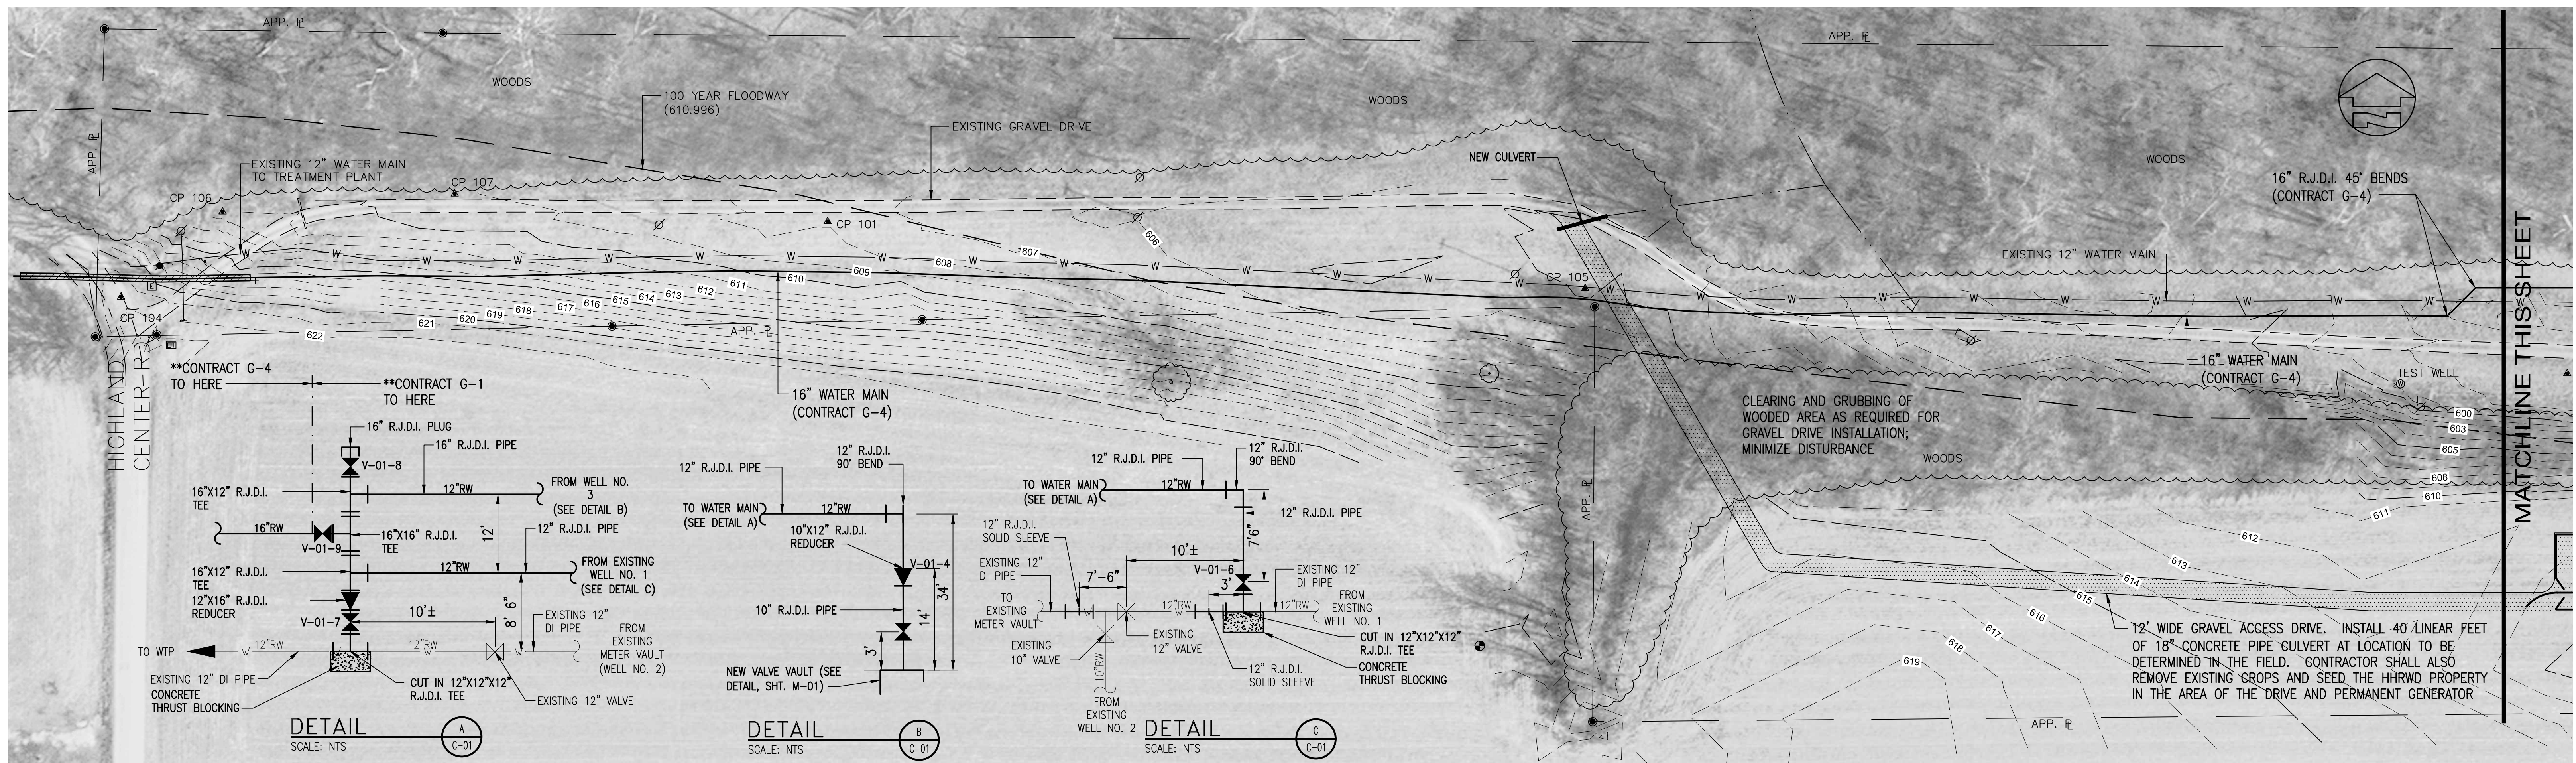


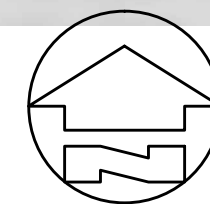

SHEET NOTES:

1. REFER TO SPECIFICATIONS SECTION 01125 REGARDING REQUIREMENTS TO MAINTAIN EXISTING WELLFIELD OPERATIONS, CONSTRUCTION SEQUENCING, AND TIE-INS. PROCESS CHANGE OVERS OR TIE-INS SHALL BE APPROVED BY OWNER IN WRITING 72 HOURS IN ADVANCE.
2. ALL WELLFIELD YARD PIPING, FITTINGS, AND APPURTENANCES SHALL BE RESTRAINED JOINT DUCTILE IRON PER SPECS, UNLESS OTHERWISE NOTED, REGARDLESS OF PIPE ORIENTATION, LOCATION, OR SERVICE TYPE. CONCRETE THRUST BLOCKING SHALL BE PROHIBITED UNLESS OTHERWISE NOTED ON DRAWINGS. ALSO SEE NOTE 3 BELOW.
3. CONTRACTOR SHALL CONFIRM CLEARANCE AT ALL PIPE INTERSECTIONS PRIOR TO LINE EXCAVATION.
4. EXISTING ELECTRICAL NOT SHOWN FOR CLARITY. REFER TO ELECTRICAL DRAWINGS.
5. ALL PROPOSED FITTINGS, VALVES AND PIPE IN WELLFIELD AREA SHALL BE PRESSURE CLASS 350.
6. REFER TO ELECTRICAL DRAWINGS FOR PROPOSED EMERGENCY GENERATOR REQUIREMENTS.
7. REFER TO SHT. M-00 FOR PROCESS VALVE SCHEDULE (V-XX-X).
8. EXIST. WELL PUMPS AND MOTORS REPLACEMENTS SHALL BE PART OF ADDITIVE BID ALTERNATE 1 SCOPE.

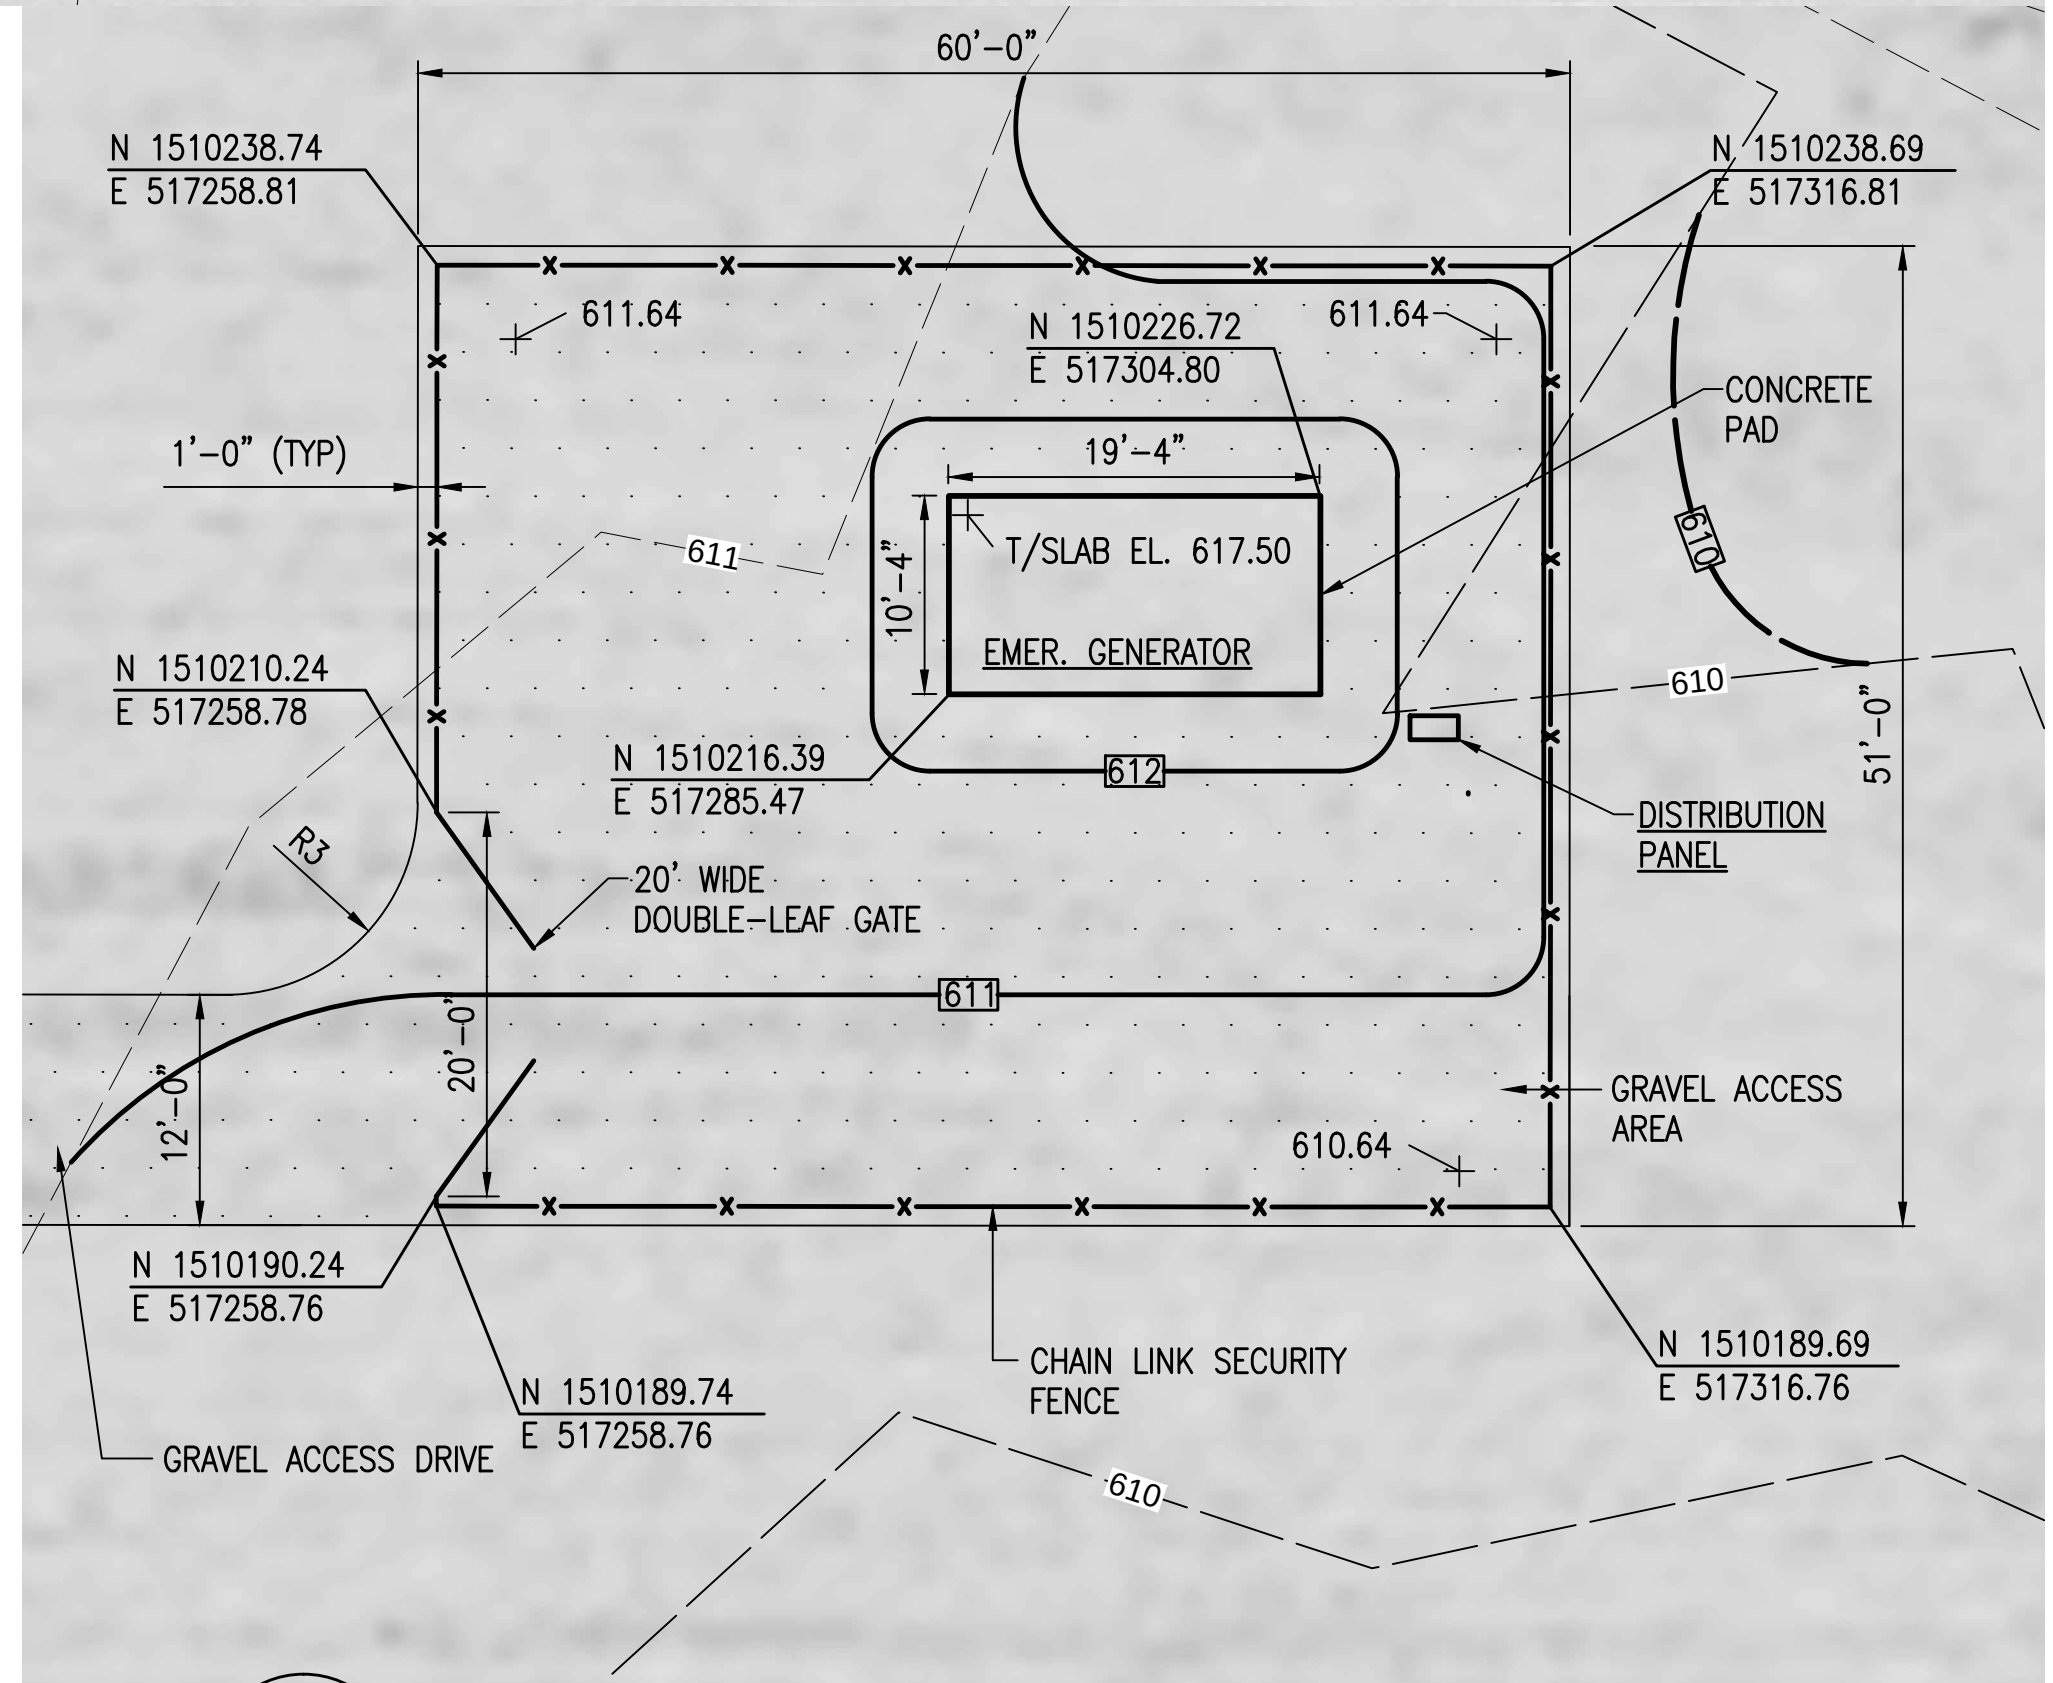

DETAIL - GENERATOR @ WELLFIELD

SCALE: 1"=10'-0"

WELLFIELD - SITE PLAN

SCALE: 1"=50'-0"

NOTES:

1. ALL ELEVATIONS ON THESE PLANS BASED ON NAVD 88 UNLESS OTHERWISE NOTED.
2. 100 YR. FLOOD ELEV. = 610.996

THIS RECORD DOCUMENT HAS BEEN PREPARED BASED ON INFORMATION PROVIDED BY THE CONSTRUCTION CONTRACTOR. GRW ENGINEERS, INC. HAS ATTEMPTED TO VERIFY THE ACCURACY AND/OR COMPLETENESS OF THIS INFORMATION BUT SHALL NOT BE RESPONSIBLE FOR ANY ERRORS OR OMISSIONS WHICH MAY BE INCORPORATED HEREIN AS A RESULT.

GRW
engineering | architecture | geospatial
ENGINEER/ARCHITECT: Darren S. Wells
CONSTRUCTION COMPANY: Mitchell & Stark Const. Co., Inc.
DATE: FEBRUARY 2014

ACCESS DRIVE LOCATION COORDINATES

MARK	NORTHING (N)	EASTING (E)	RADIUS
R3	1510210.75	517247.78	10'
R4	1510346.65	518010.84	5'
R5	1510346.42	518028.83	5'

WELLFIELD SITE PLAN

HOOSIER HILLS REGIONAL WATER DISTRICT CONTRACTS G-1 & G-5

GRW
engineering | architecture | geospatial

CLIENT CONTRACT NO. G-1/G-5 GRW PROJECT NO. 3235-04

DRAWING SCALE CHECK: THIS MARK SHOULD MEASURE EXACTLY 1" WHEN PLOTTED

ALL RIGHTS RESERVED:
THIS DOCUMENT IS THE PROPERTY OF GRW, INC. AND SHALL NOT BE REPRODUCED IN WHOLE OR IN PART OR USED FOR CONSTRUCTION OF OTHER THAN THIS SPECIFIC PROJECT WITHOUT WRITTEN PERMISSION OF GRW, INC.

1	AS-BUILTS	2/14	JAJ
NO.	DESCRIPTION	DATE	BY
REVISIONS			

This document, originally issued, sealed, and signed by Darren S. Wells, Indiana Professional Engineer, No. 10100200, on March 26, 2012, shall not be used in lieu of a certified document.

DESIGNED: ALW	DATE: FEBRUARY 2012
DRAWN: JAJ	SCALE: AS SHOWN
REVIEWED: DRC	SHEET NO.
APPROVED: ALW	C-01