



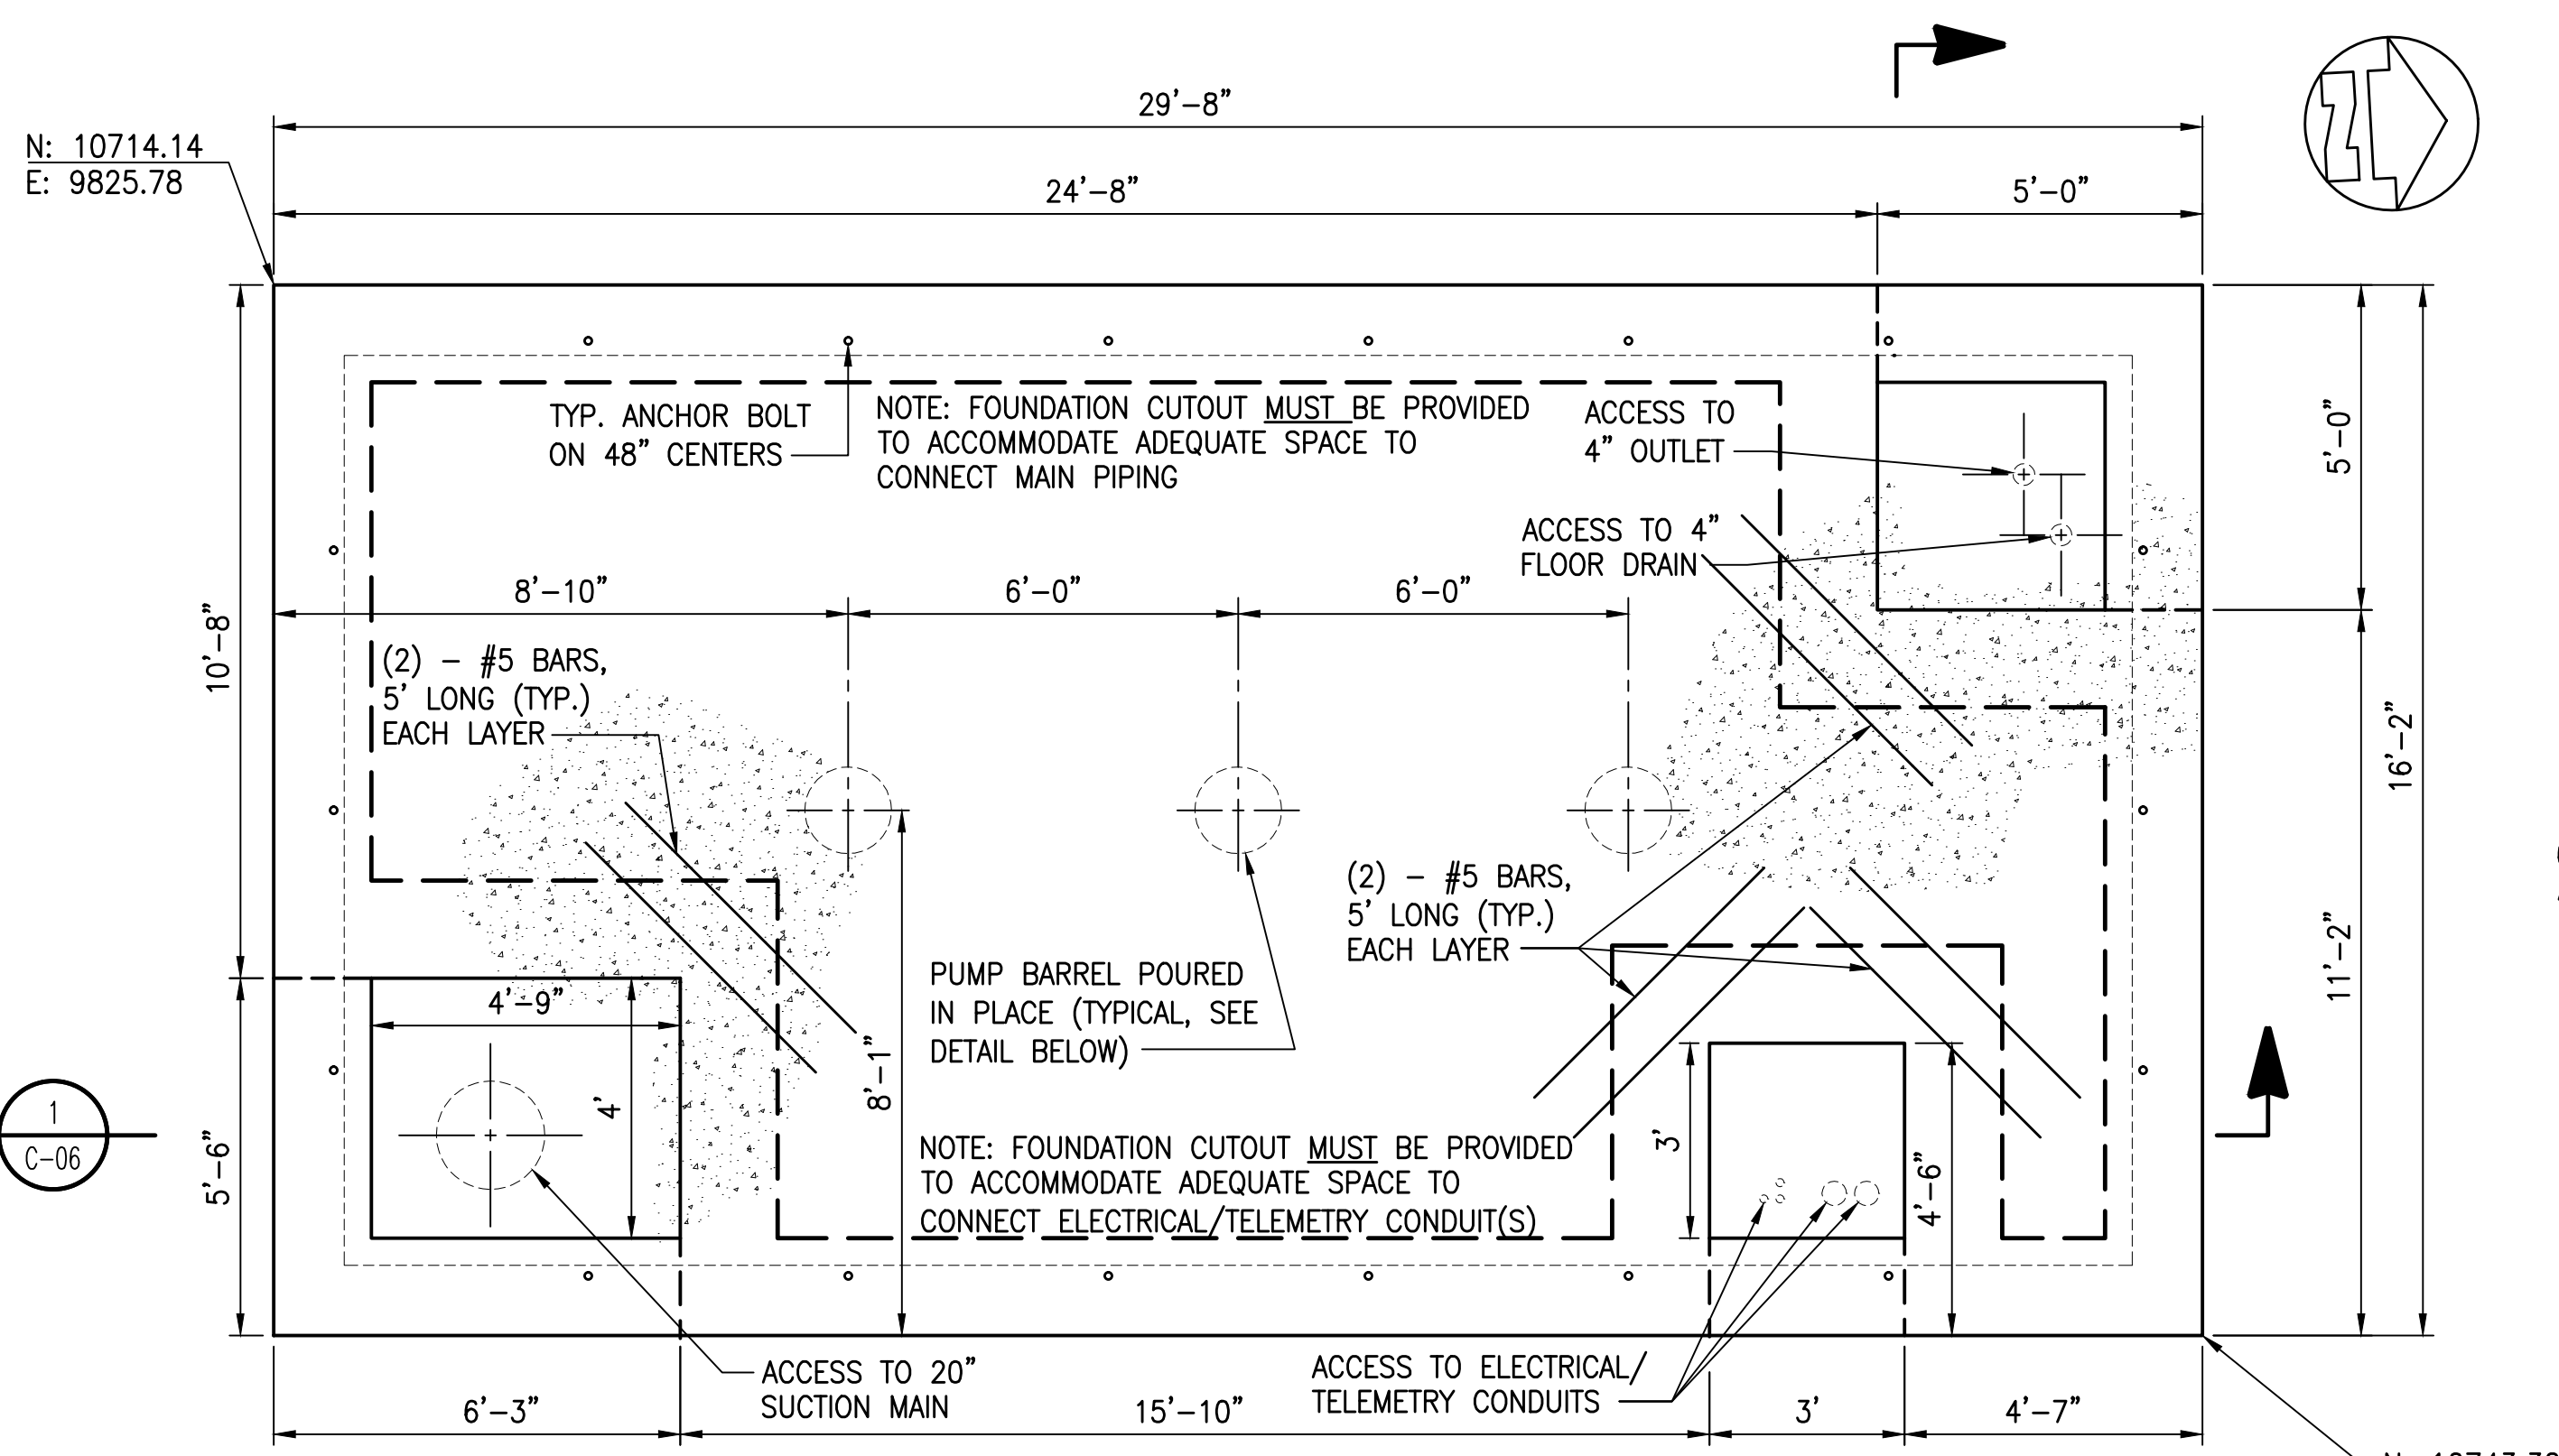


TYPICAL FOUNDATION LAYOUT

SCALE: 3/8" = 1'-0"

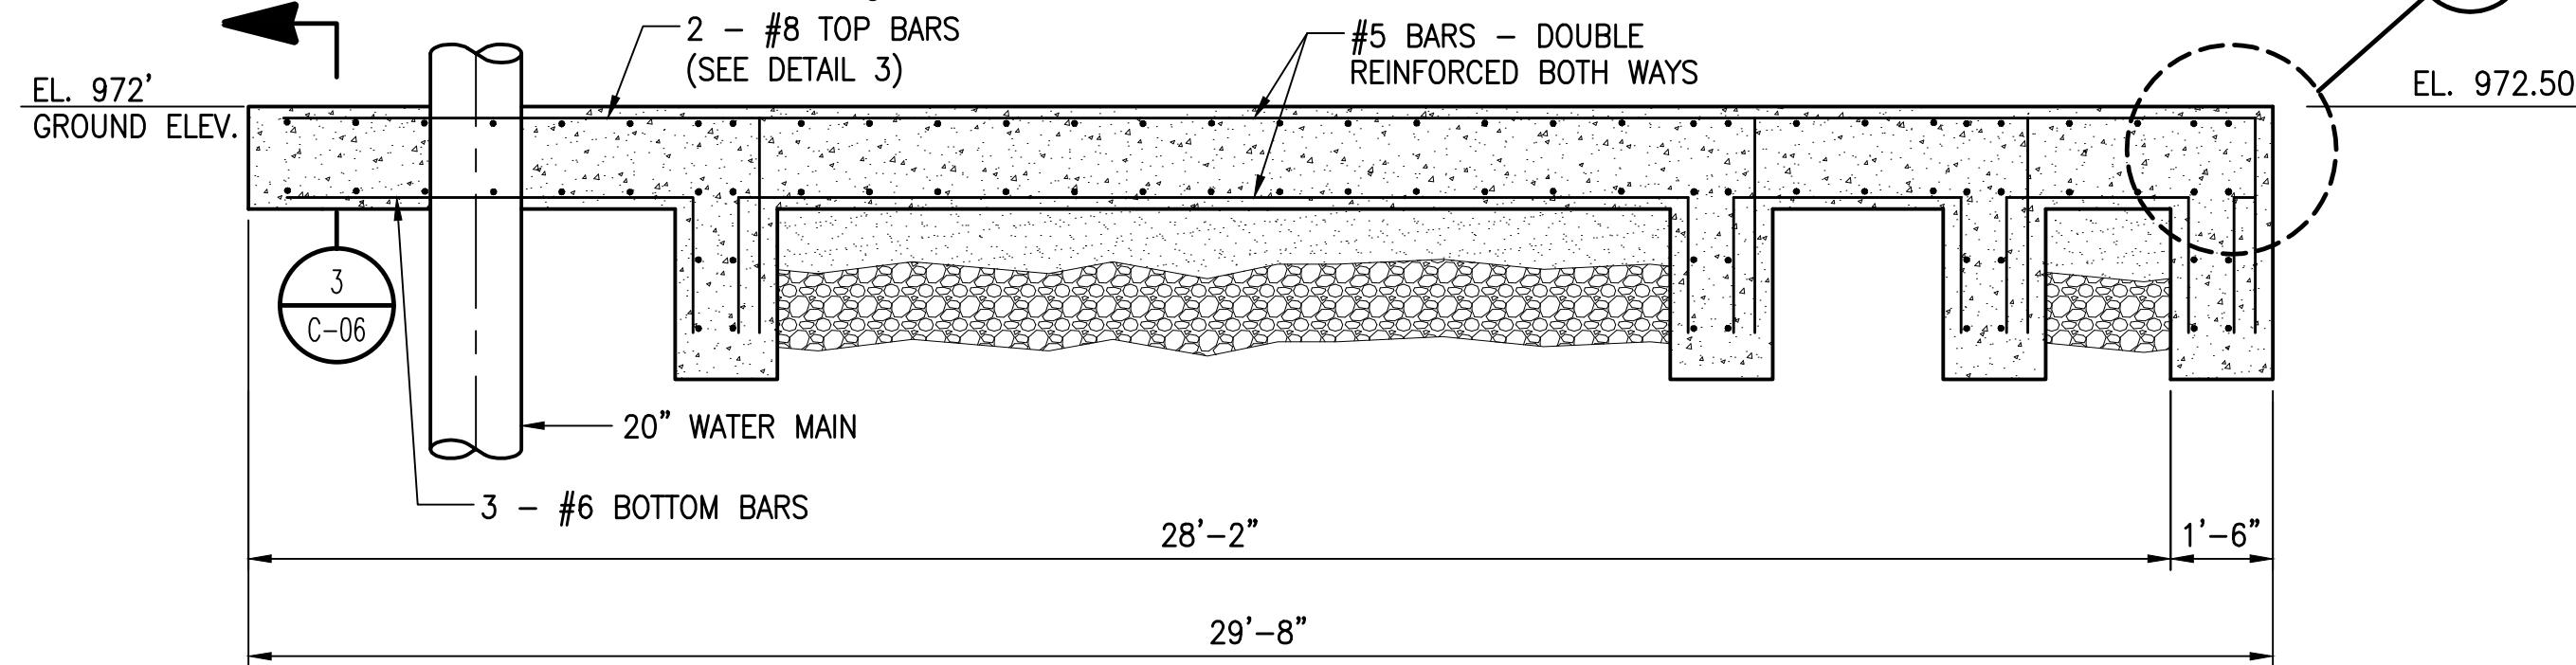


SECTION 1

SCALE: 3/8" = 1'-0"

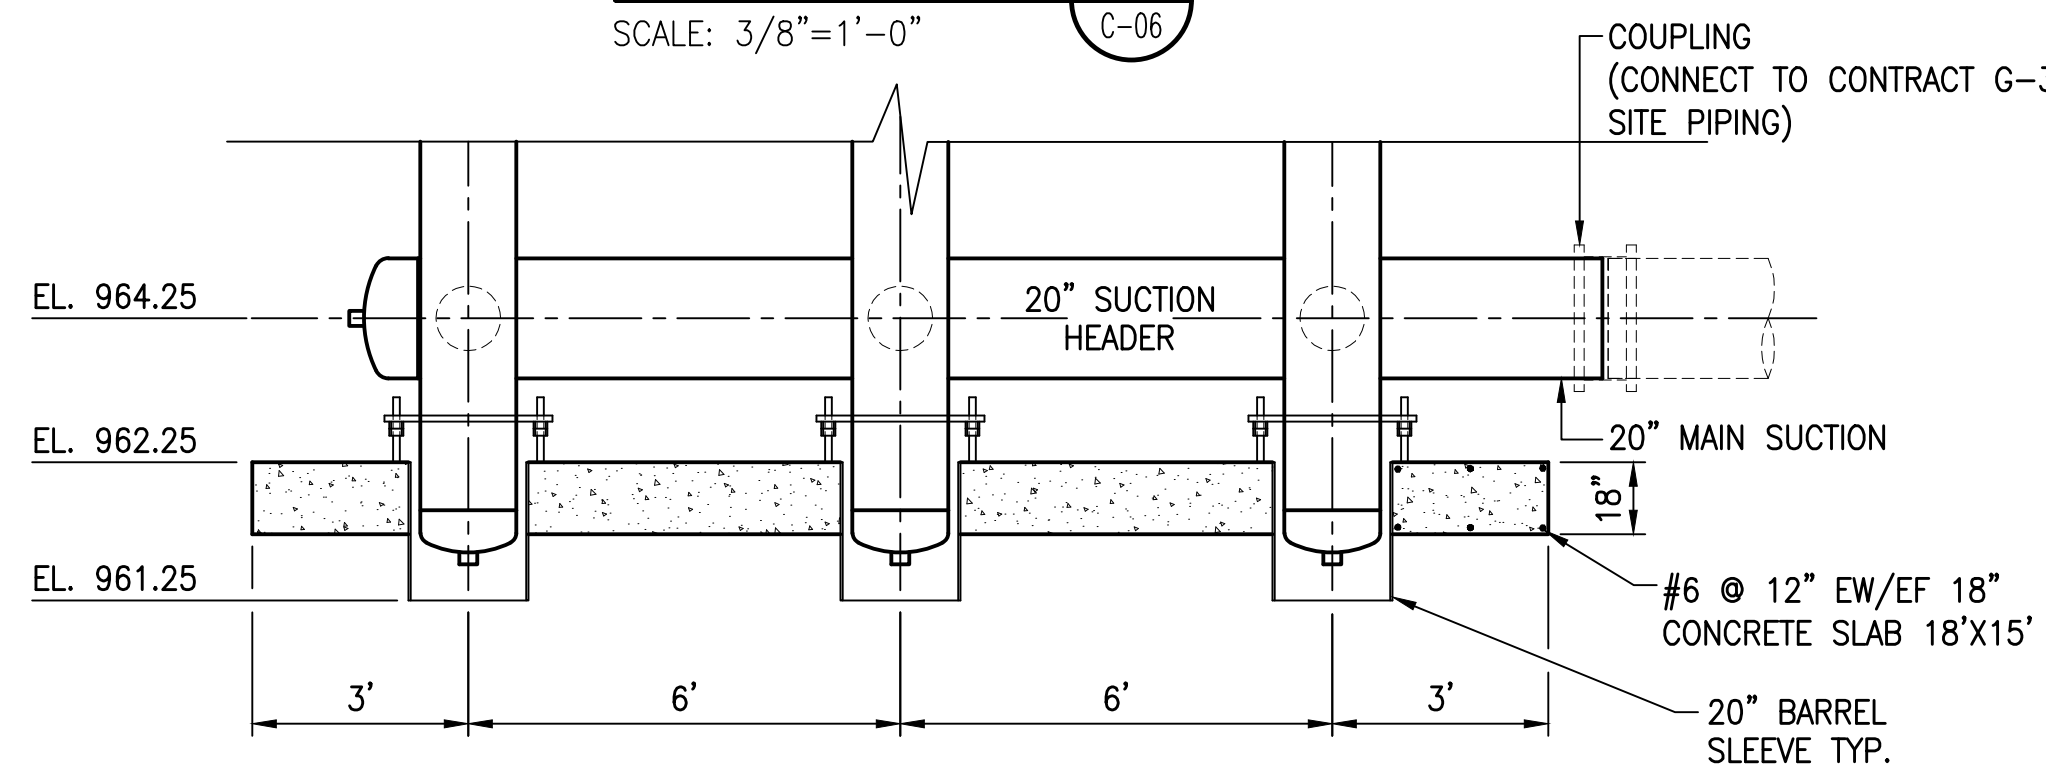


LOWER SLAB - DETAIL

SCALE: N.T.S.

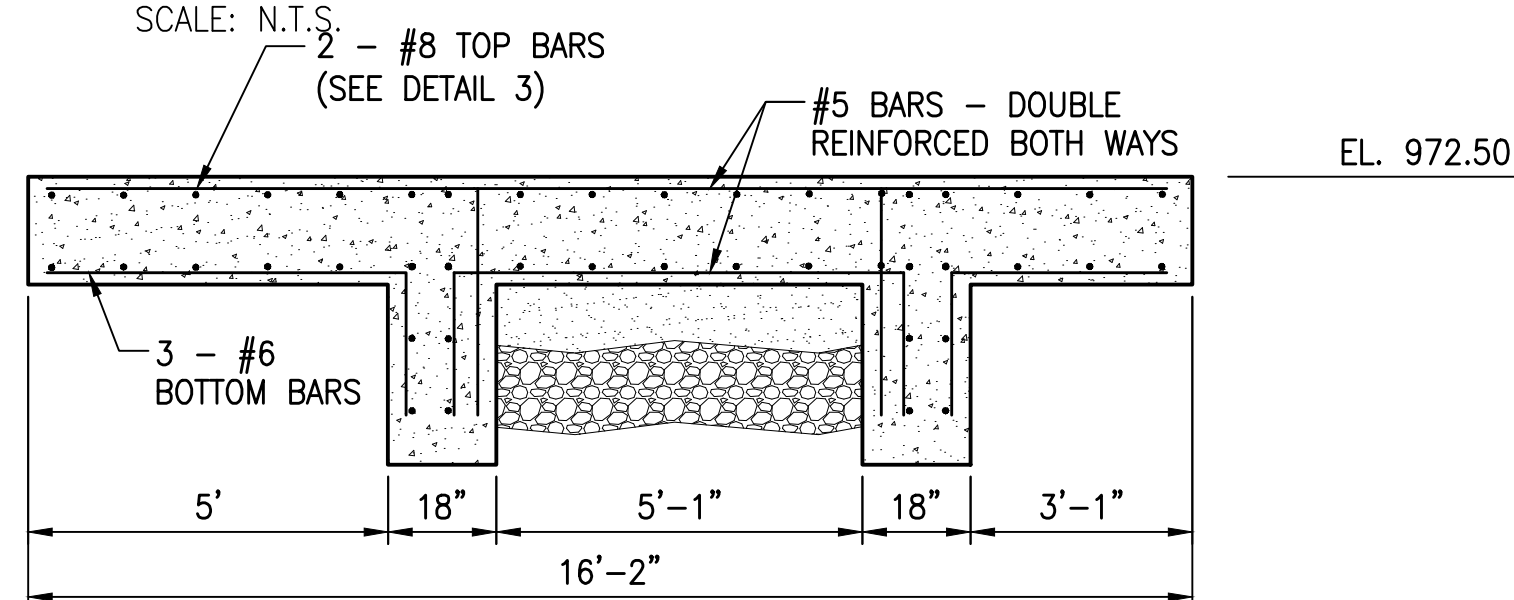


SECTION 4

SCALE: N.T.S.

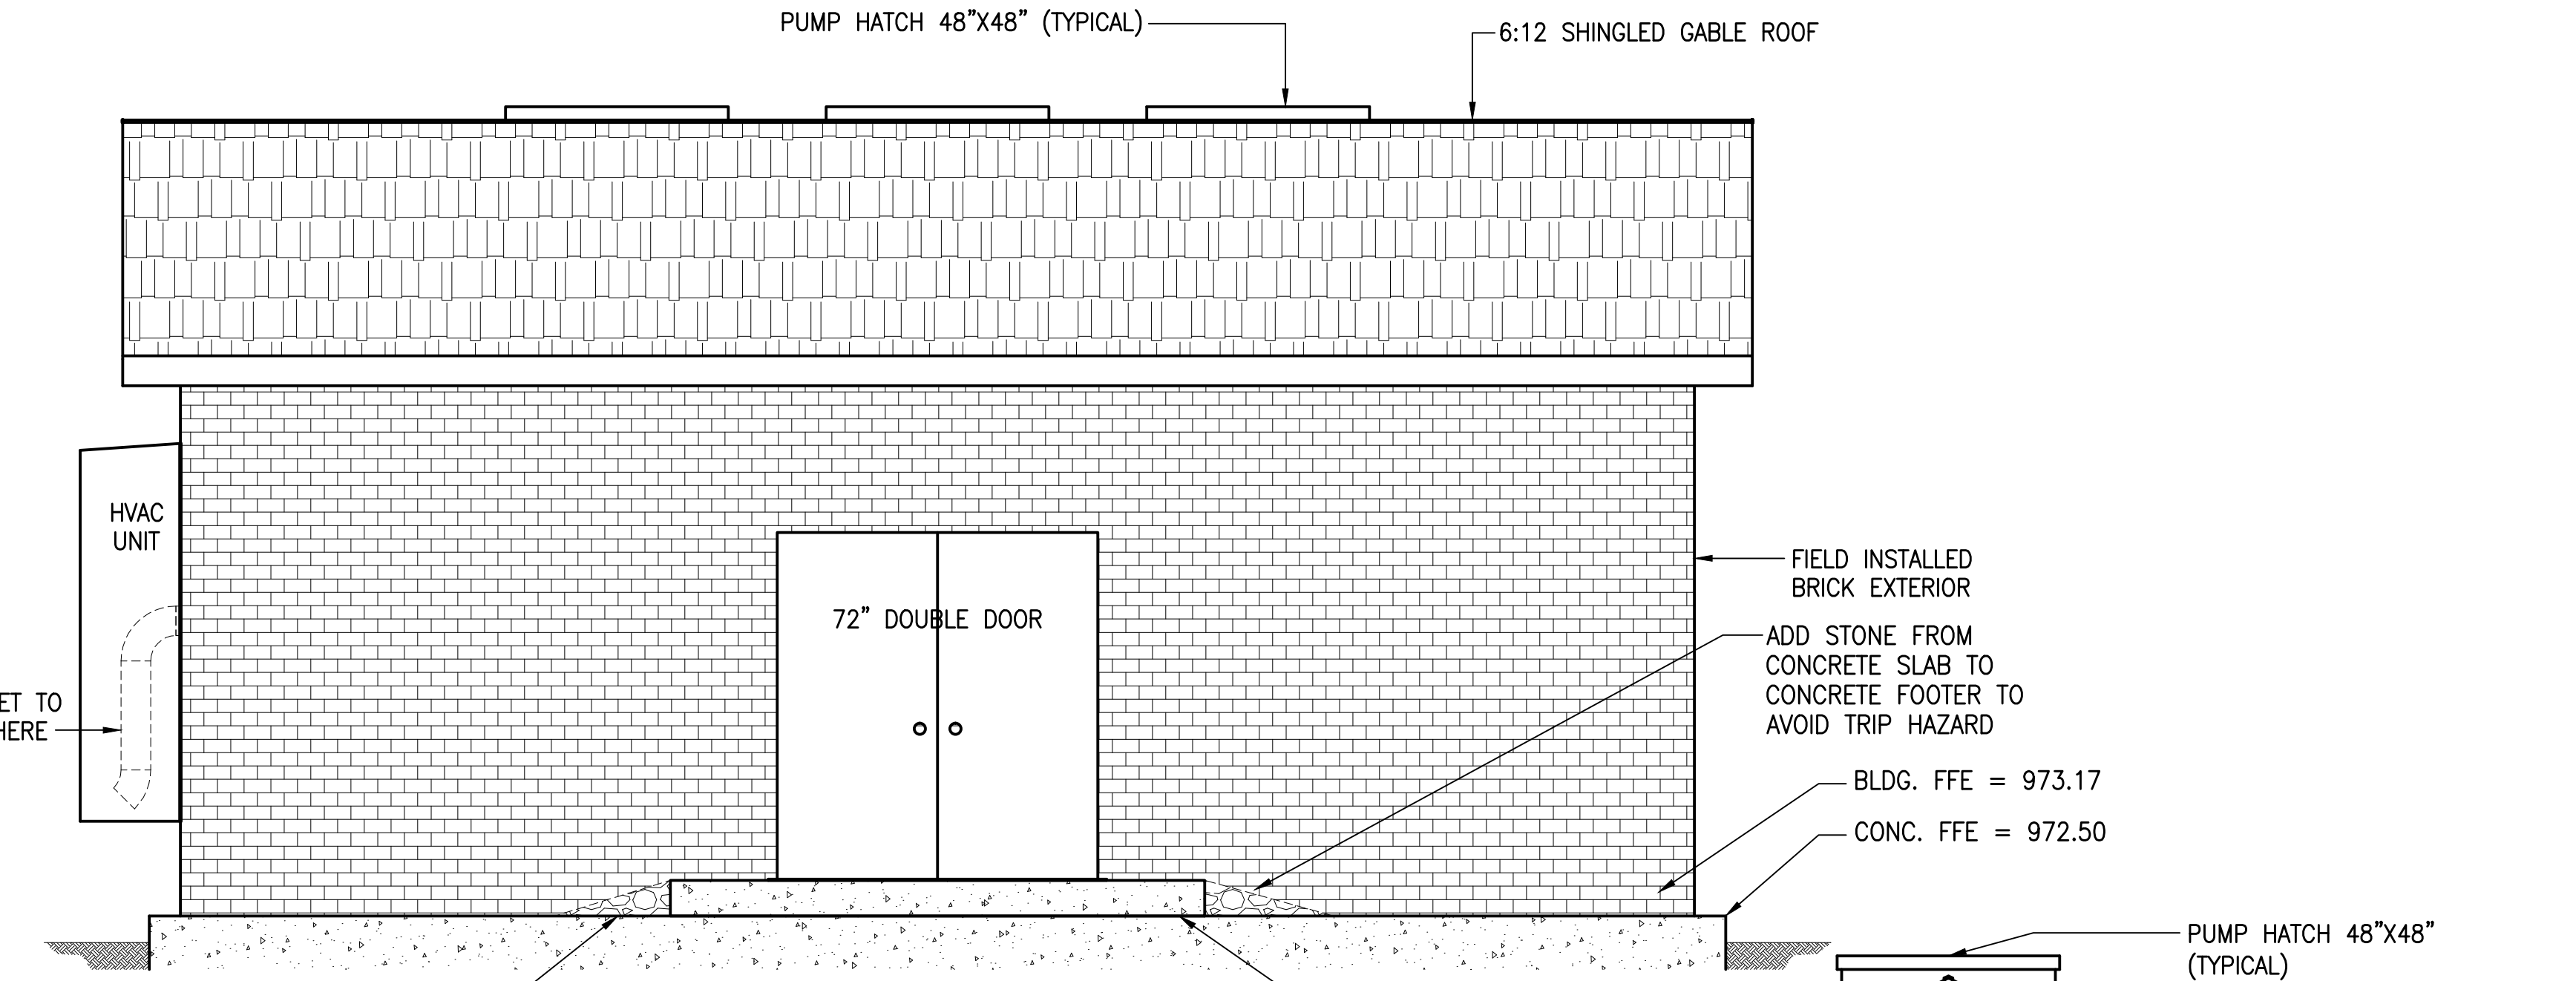


FRONT ELEVATION

SCALE: 3/8" = 1'-0"

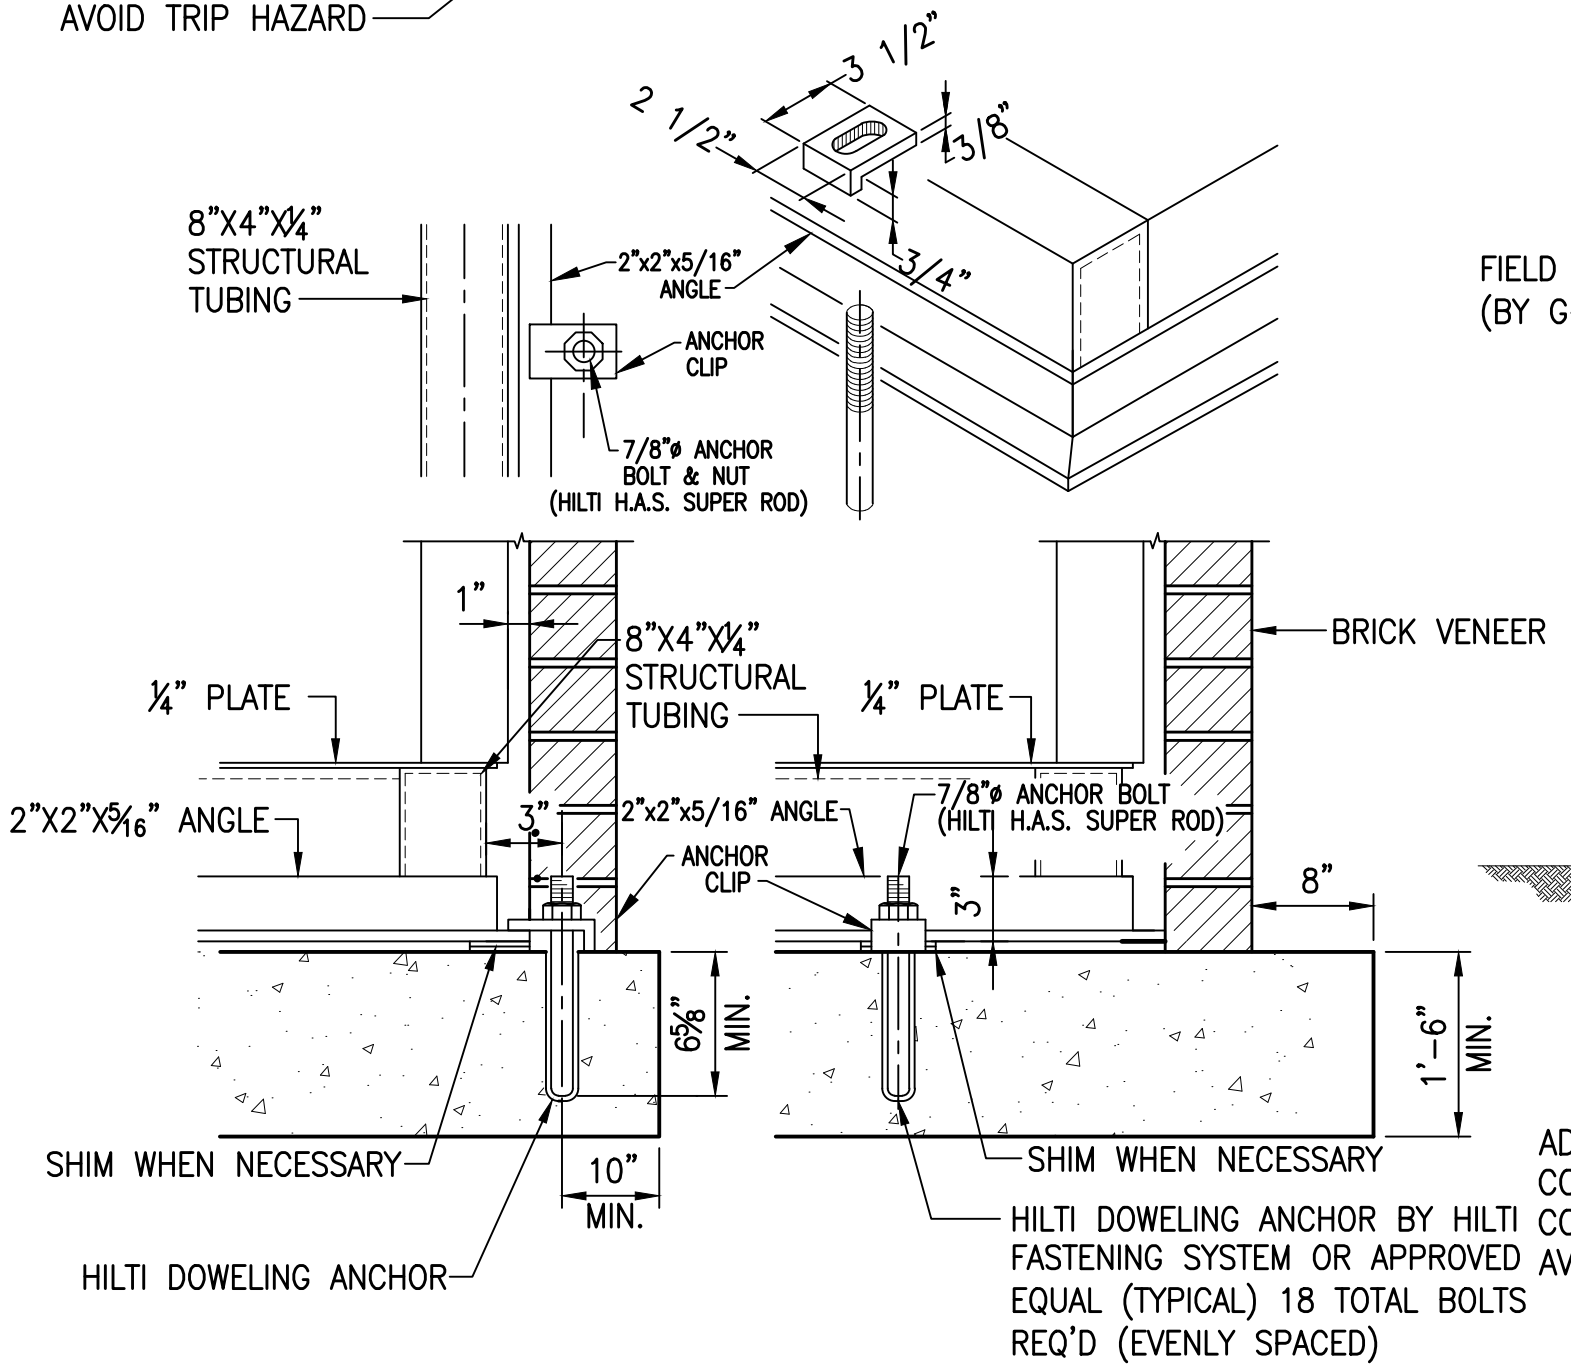


TYPICAL LEDGE - DETAIL

SCALE: N.T.S.

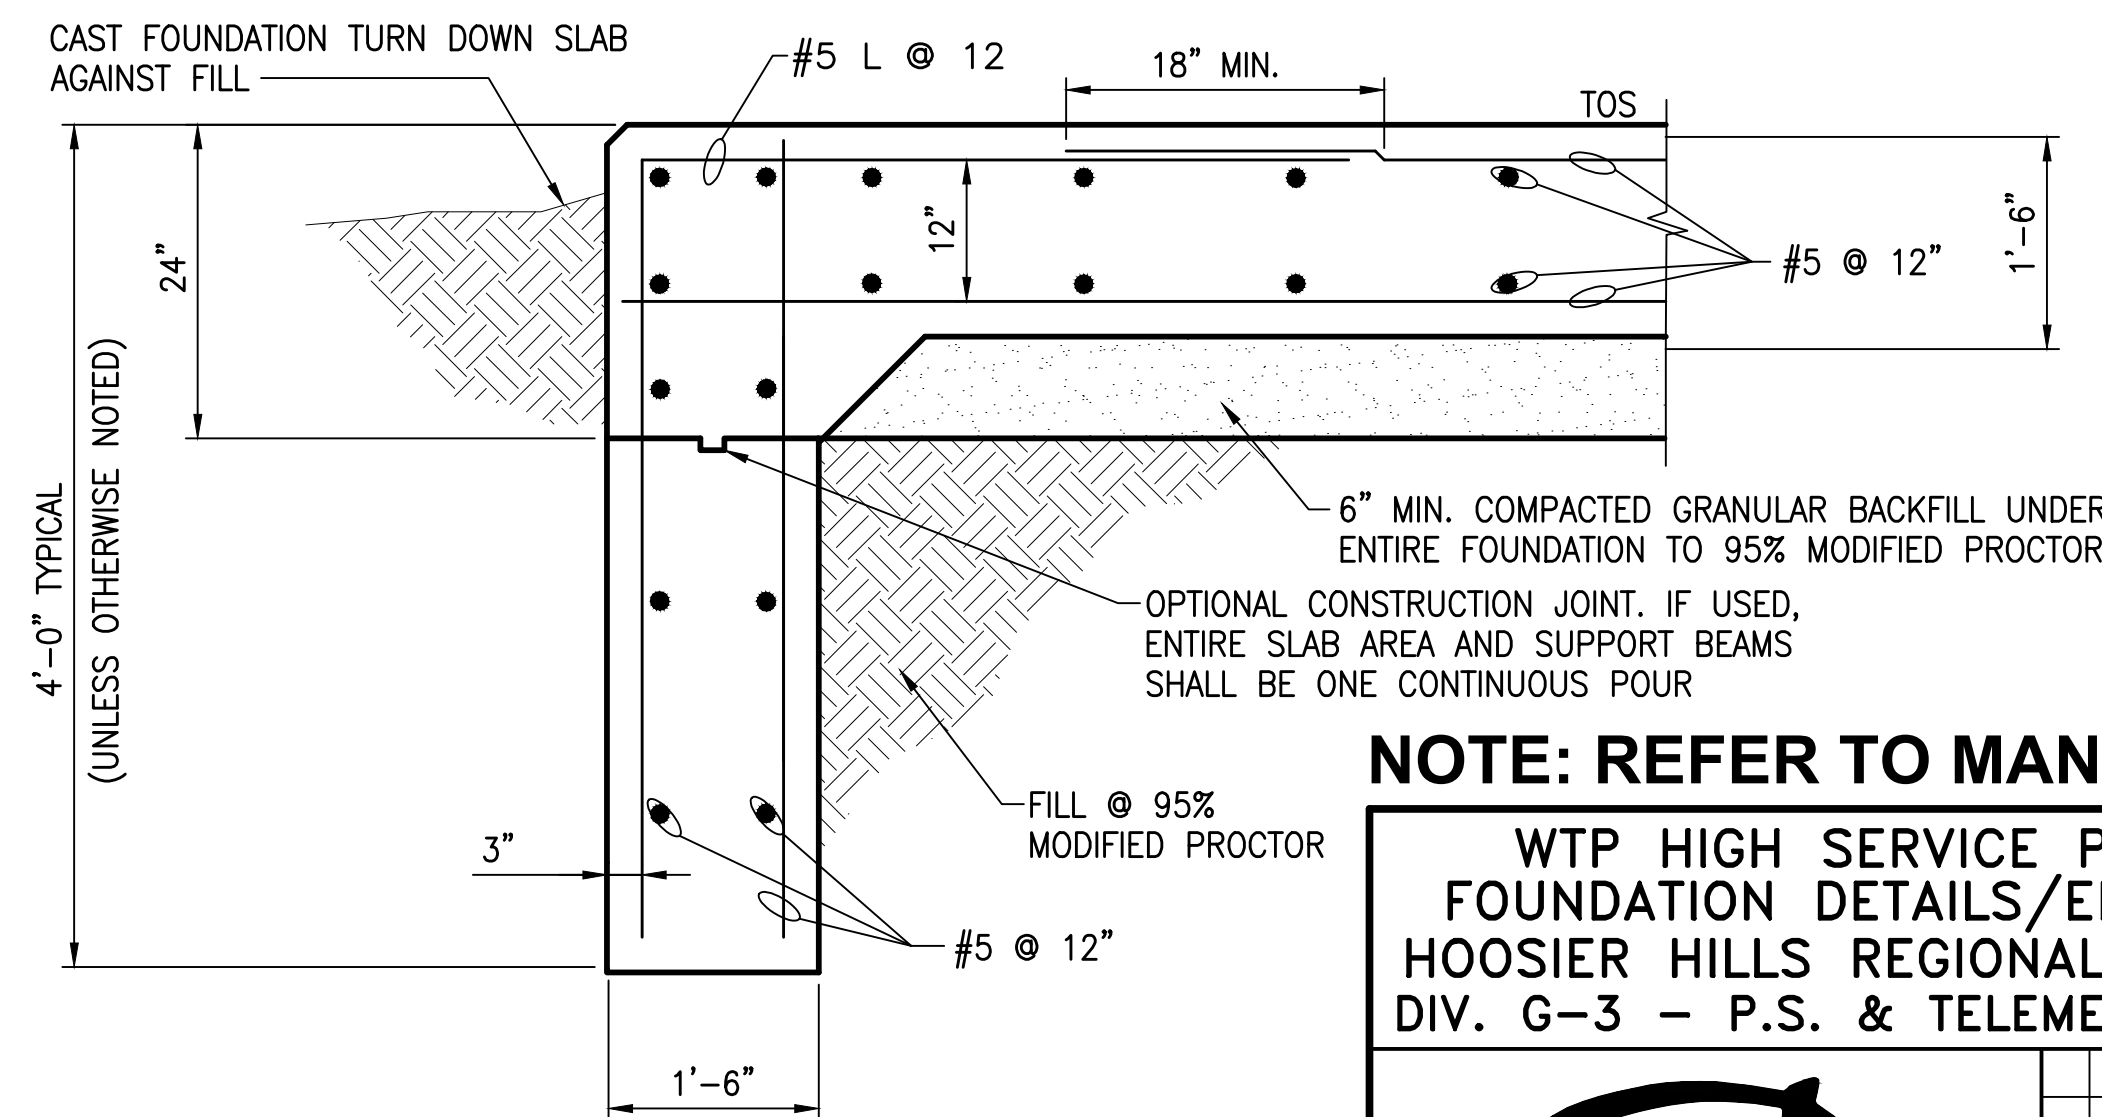


DETAIL 2

SCALE: N.T.S.

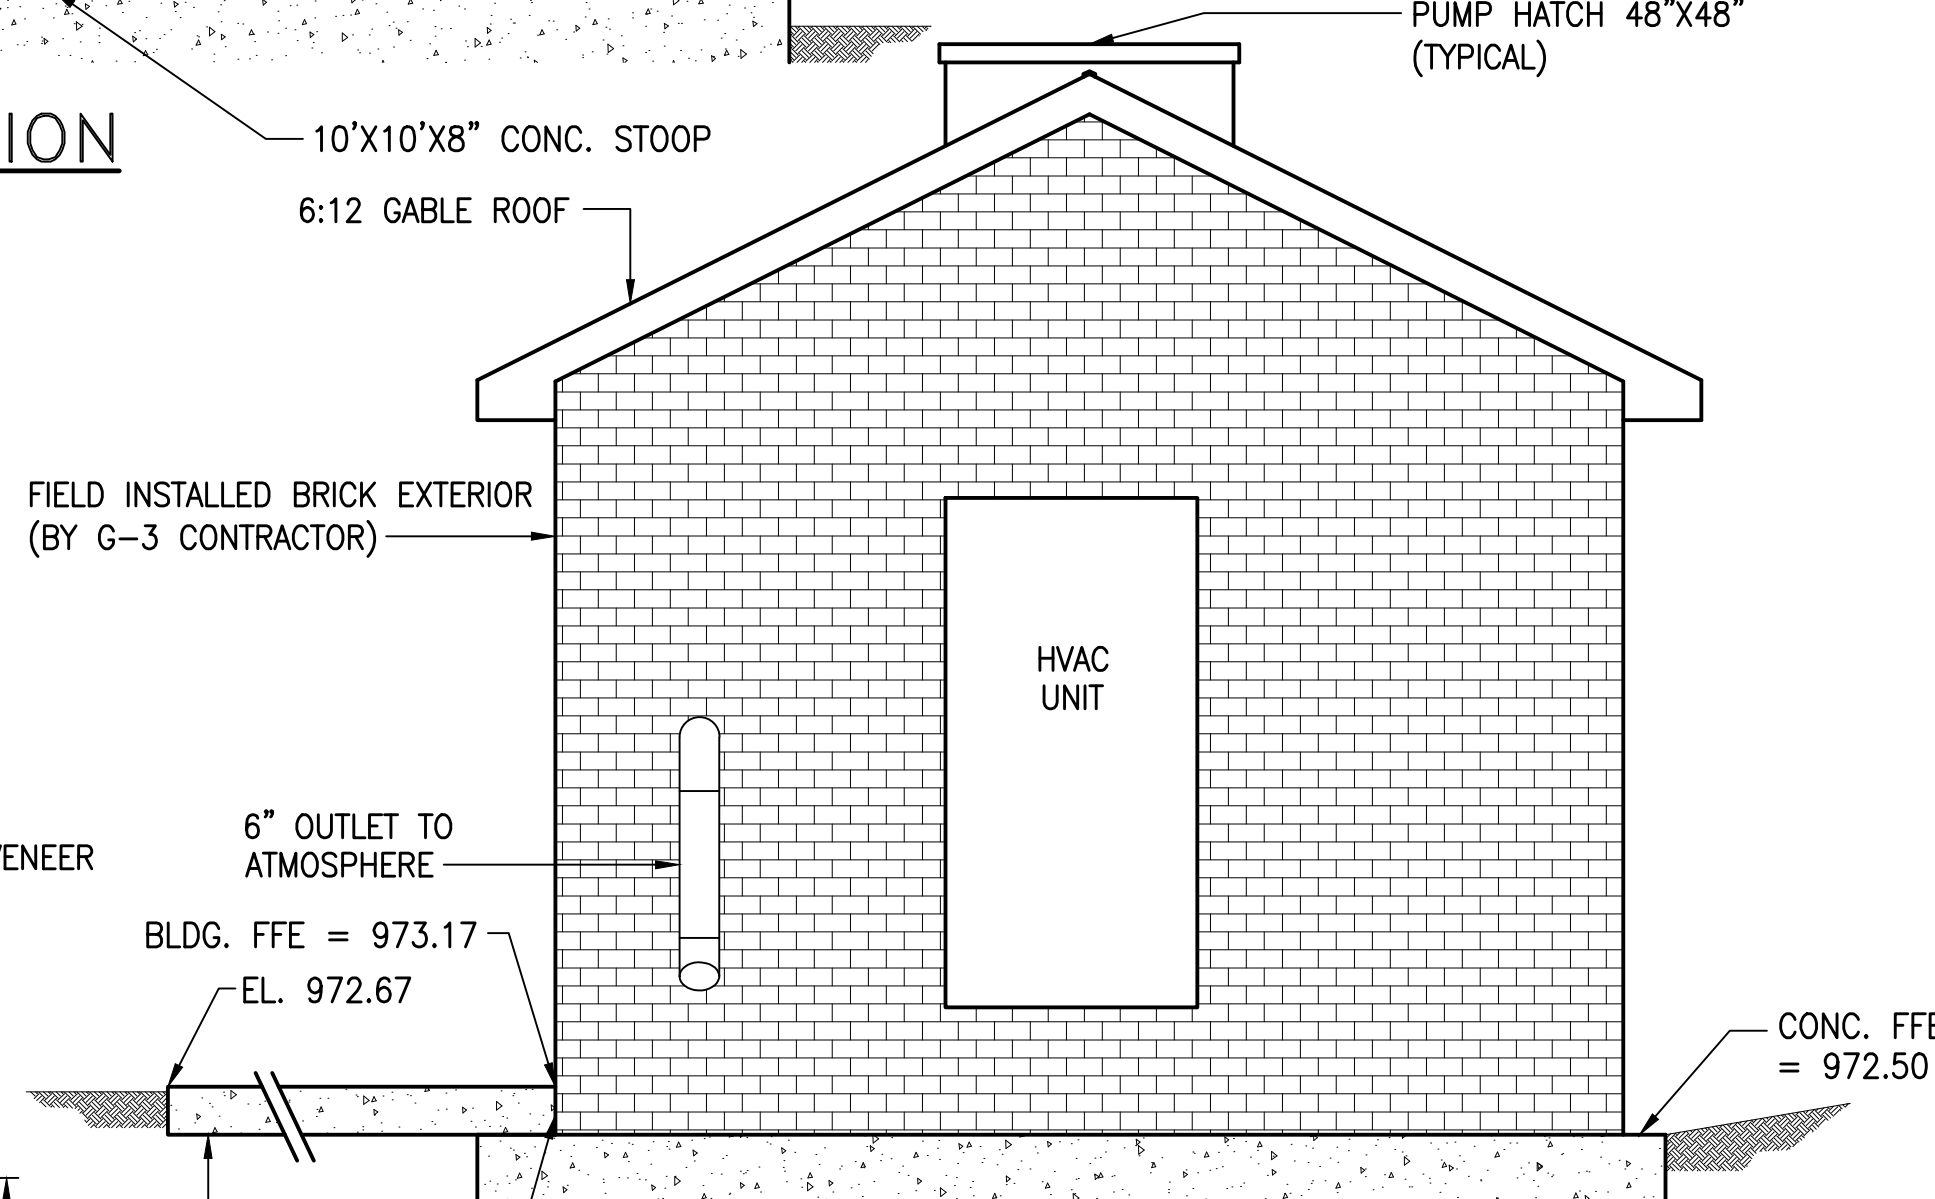

LEFT SIDE ELEVATION

SCALE: 3/8" = 1'-0"

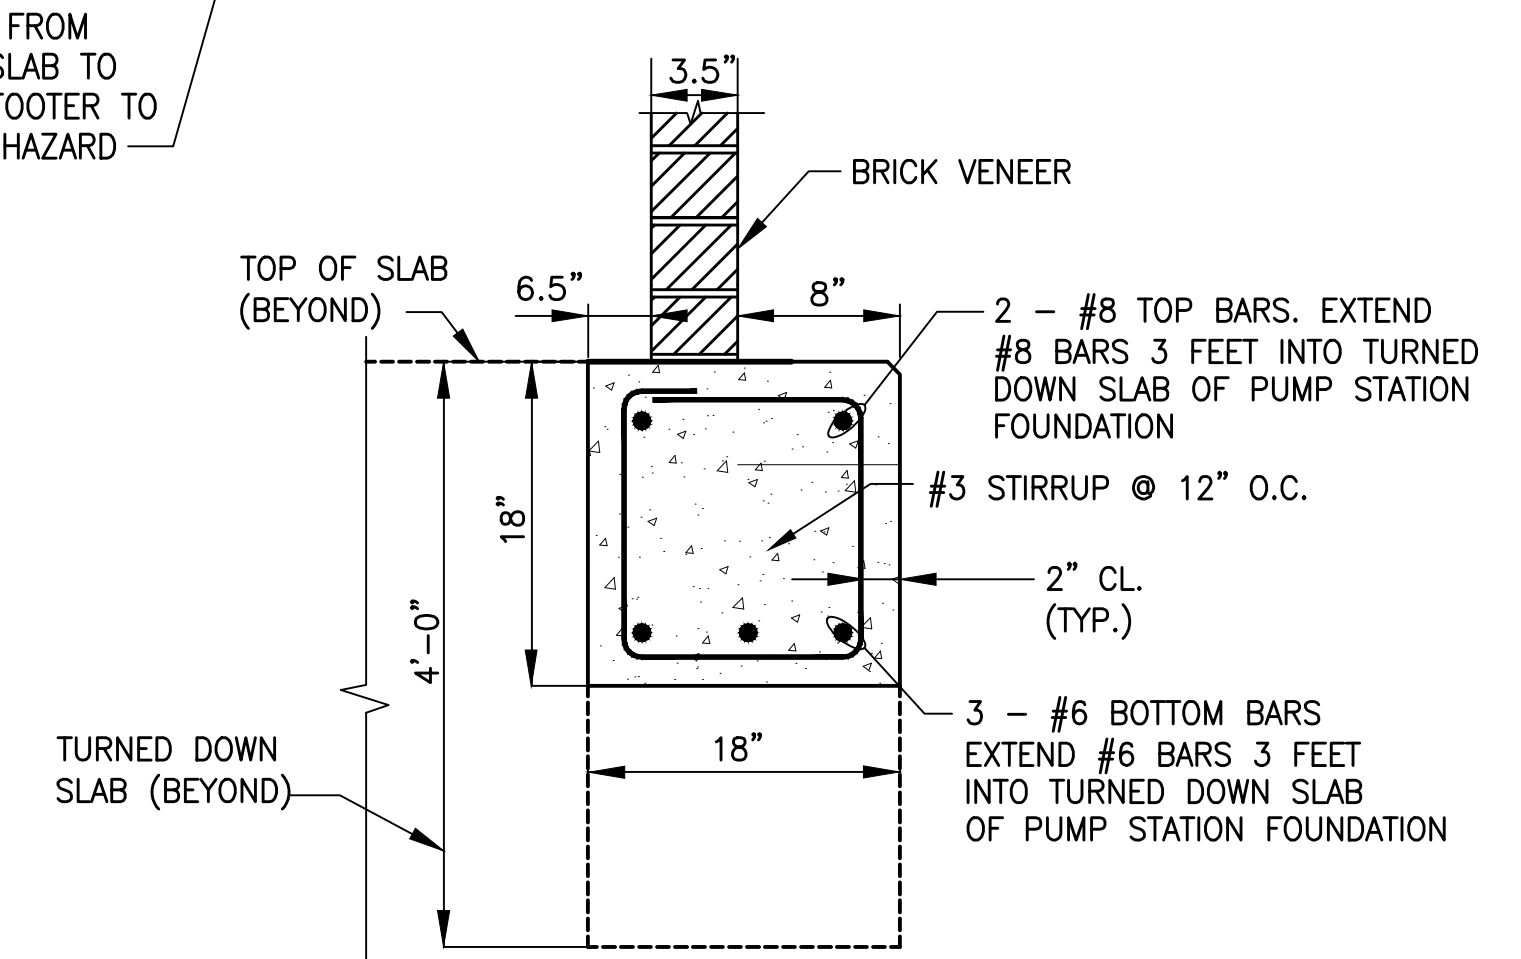

DETAIL 3

SCALE: N.T.S.

NOTE: REFER TO MANUFACTURER'S AS-BUILTS FOR MORE INFORMATION.

WTP HIGH SERVICE PUMP STATION FOUNDATION DETAILS/ELEVATION VIEWS HOOSIER HILLS REGIONAL WATER DISTRICT DIV. G-3 - P.S. & TELEMETRY IMPROVEMENTS		CLIENT CONTRACT NO. G-3	GRW PROJECT NO. 3235
DRAWING SCALE CHECK: 1" = 1'-0"		THIS MARK SHOULD MEASURE EXACTLY 1" WHEN PLOTTED	
ALL RIGHTS RESERVED: THIS DOCUMENT IS THE PROPERTY OF GRW, INC. AND SHALL NOT BE REPRODUCED IN WHOLE OR IN PART OR USED FOR CONSTRUCTION OF OTHER THAN THIS SPECIFIC PROJECT WITHOUT WRITTEN PERMISSION OF GRW, INC.		DESIGNED: ALW DATE: MARCH 2012 DRAWN: GCR SCALE: 3/8" = 1'-0" REVIEWED: DRC SHEET NO. C-06 APPROVED: ALW	

THIS RECORD DOCUMENT HAS BEEN PREPARED BASED ON INFORMATION PROVIDED BY THE CONSTRUCTION CONTRACTOR. GRW ENGINEERS, INC. HAS ATTEMPTED TO VERIFY THE ACCURACY AND/OR COMPLETENESS OF THIS INFORMATION BUT SHALL NOT BE RESPONSIBLE FOR ANY ERRORS OR OMISSIONS WHICH MAY BE INCORPORATED HEREIN AS A RESULT.

GRW
engineering | architecture | geospatial
ENGINEER/ARCHITECT: ALEX L. WHITE
CONSTRUCTION COMPANY: ENGINEERED FLUID, INC.
DATE: FEBRUARY 2014

GRW
engineering | architecture | geospatial
www.grwinc.com

1	AS-BUILTS	2/14	CJF
REVISIONS			