

CITY of ST. ALBANS
MUNICIPAL UTILITY COMMISSION
KANAWHA COUNTY, WEST VIRGINIA
WASTEWATER SYSTEM IMPROVEMENTS
E.P.A. Project No. C-540618-01
CONTRACT No. 1
WASTEWATER TREATMENT PLANT IMPROVEMENTS

INDEX TO DRAWINGS

- 1 SITE PLAN
- 2-1 YARD PIPING AND ELECTRICAL SITE PLAN
- 3 PLANT LIFT STATION - EXISTING PLANS AND SECTIONS
- 4 PLANT LIFT STATION - PROPOSED PLANS AND SECTIONS
- 5 PLANT LIFT STATION - SECTIONS AND DETAILS
- 6 NEW SLUDGE THICKENER - PLAN AND SECTIONS
- 7-1 THICKENED SLUDGE PUMPS - EXISTING AND PROPOSED PLANS AND SECTIONS
- 8 PRIMARY AND SECONDARY DIGESTERS - EXISTING ROOF PLAN AND SECTIONS
- 9 PRIMARY AND SECONDARY DIGESTERS - PROPOSED ROOF PLAN AND SECTIONS
- 10 PRIMARY AND SECONDARY DIGESTERS - EXISTING PIPING PLANS AND SECTIONS
- 11 PRIMARY AND SECONDARY DIGESTERS - PROPOSED PIPING PLANS AND SECTIONS
- 12 PRIMARY AND SECONDARY DIGESTERS - MISCELLANEOUS DETAILS AND SECTIONS
- 13 NEW CHLORINE FACILITY - PROPOSED PLAN, SECTIONS AND DETAILS
- 14 MISCELLANEOUS DETAILS
- 15 PLANT LIFT STATION - MECHANICAL AND ELECTRICAL PLANS
- 16-1 THICKENED SLUDGE PUMPS - ELECTRICAL PLANS
- 17 PRIMARY AND SECONDARY DIGESTER CONTROL ROOM ELECTRICAL/MECHANICAL PLANS
- 18-1 NEW CHLORINE FACILITY - MECHANICAL AND ELECTRICAL PLANS AND MISCELLANEOUS SCHEDULES
- 19 ELECTRICAL RISER SCHEMATIC AND PANELBOARD SCHEDULES
- 19 SPLITTER BOX & PIPING


CITY of ST. ALBANS, MUNICIPAL UTILITY COMMISSION

APPROVED: A. Eddie Bassitt 3/15/90
A. EDDIE BASSITT, MAYOR & CHAIRMAN DATE

CHAPMAN TECHNICAL GROUP, CONSULTING ENGINEERS

APPROVED: Harvey R. Chapman 3/15/90
HARVEY R. CHAPMAN, P.E., OWNER DATE

RECORD DRAWINGS

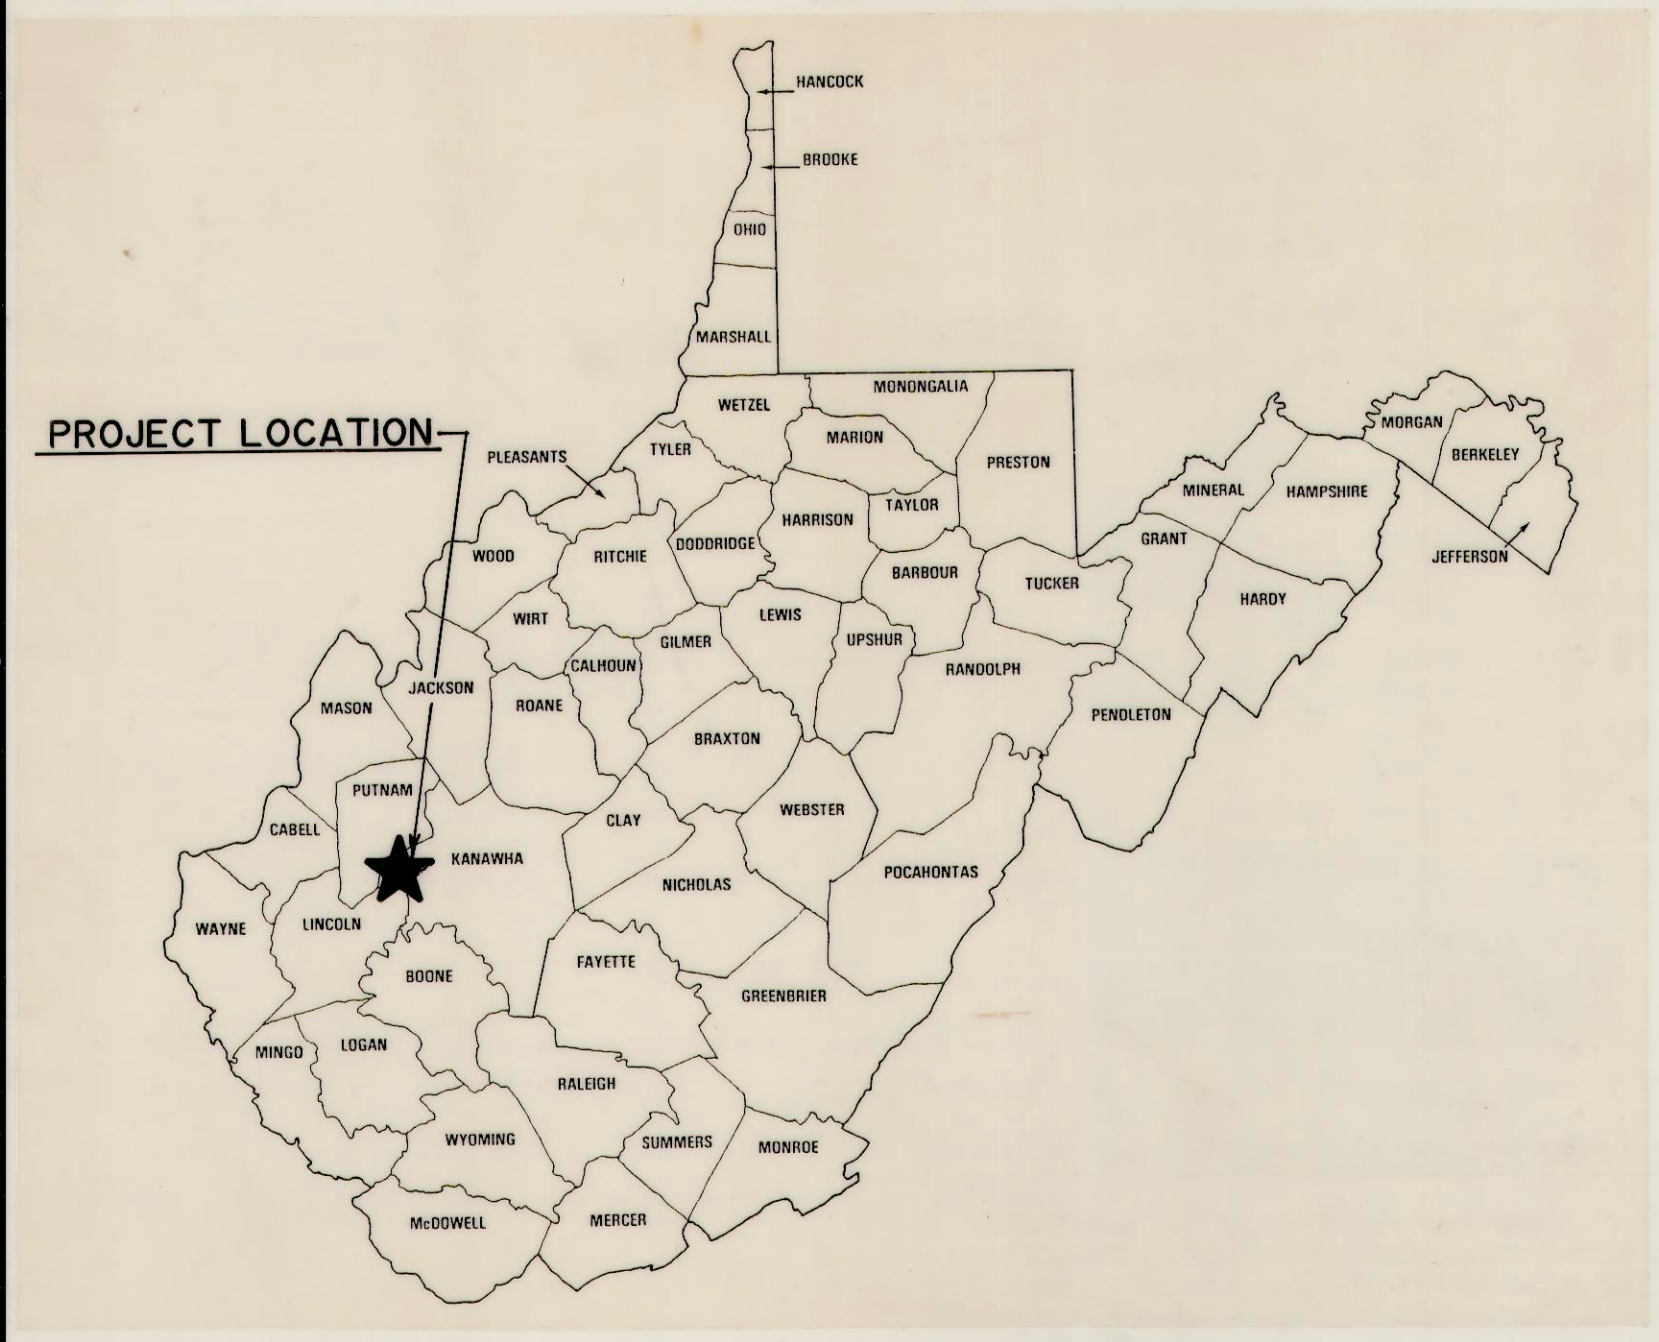

PROJECT INFORMATION

CITY of ST. ALBANS
MUNICIPAL UTILITY COMMISSION
KANAWHA COUNTY, WEST VIRGINIA
WASTEWATER SYSTEM IMPROVEMENTS
EPA PROJECT No. C-540618-01

CONTRACT No. 1

Chapman Technical Group

DRAWING TITLE

TITLE SHEET

DRAWN: R. OSBORNE
CHECKED: G. BELCHER
DATE: AUGUST, 1989
SCALE:
PROJECT NUMBER: 87016
DRAWING NUMBER: