




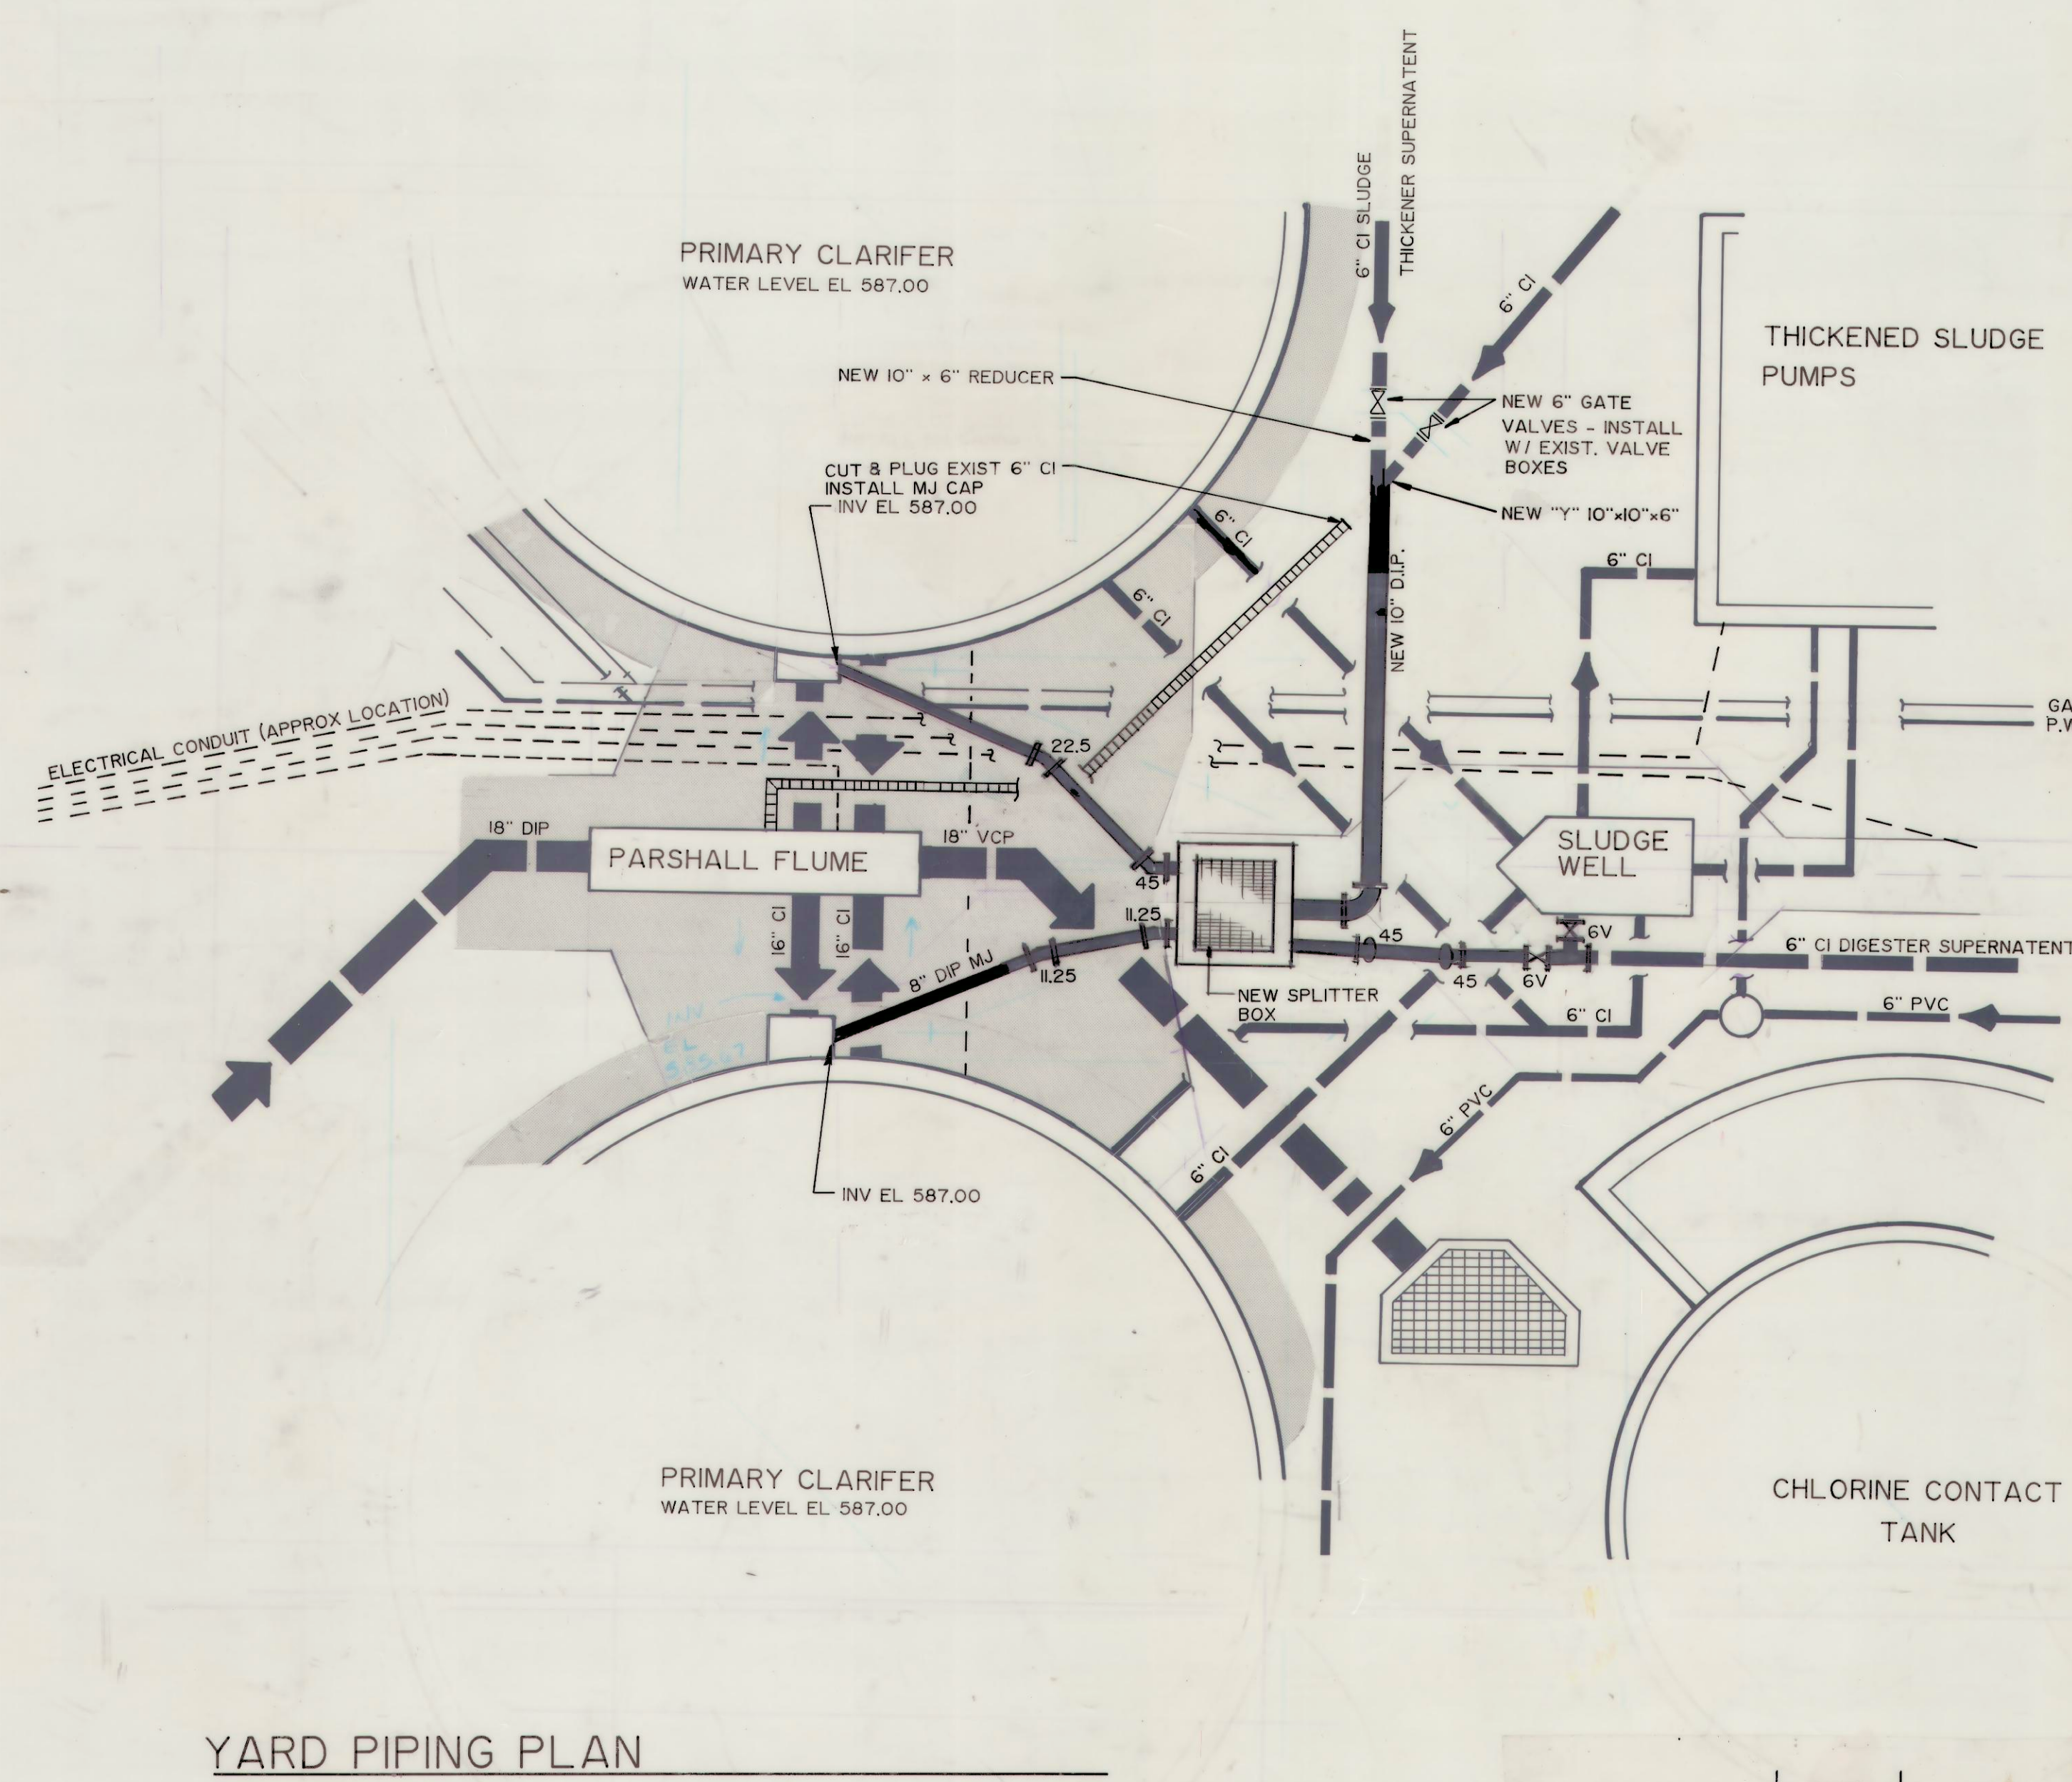


YARD PIPING PLAN
 SCALE: NONE

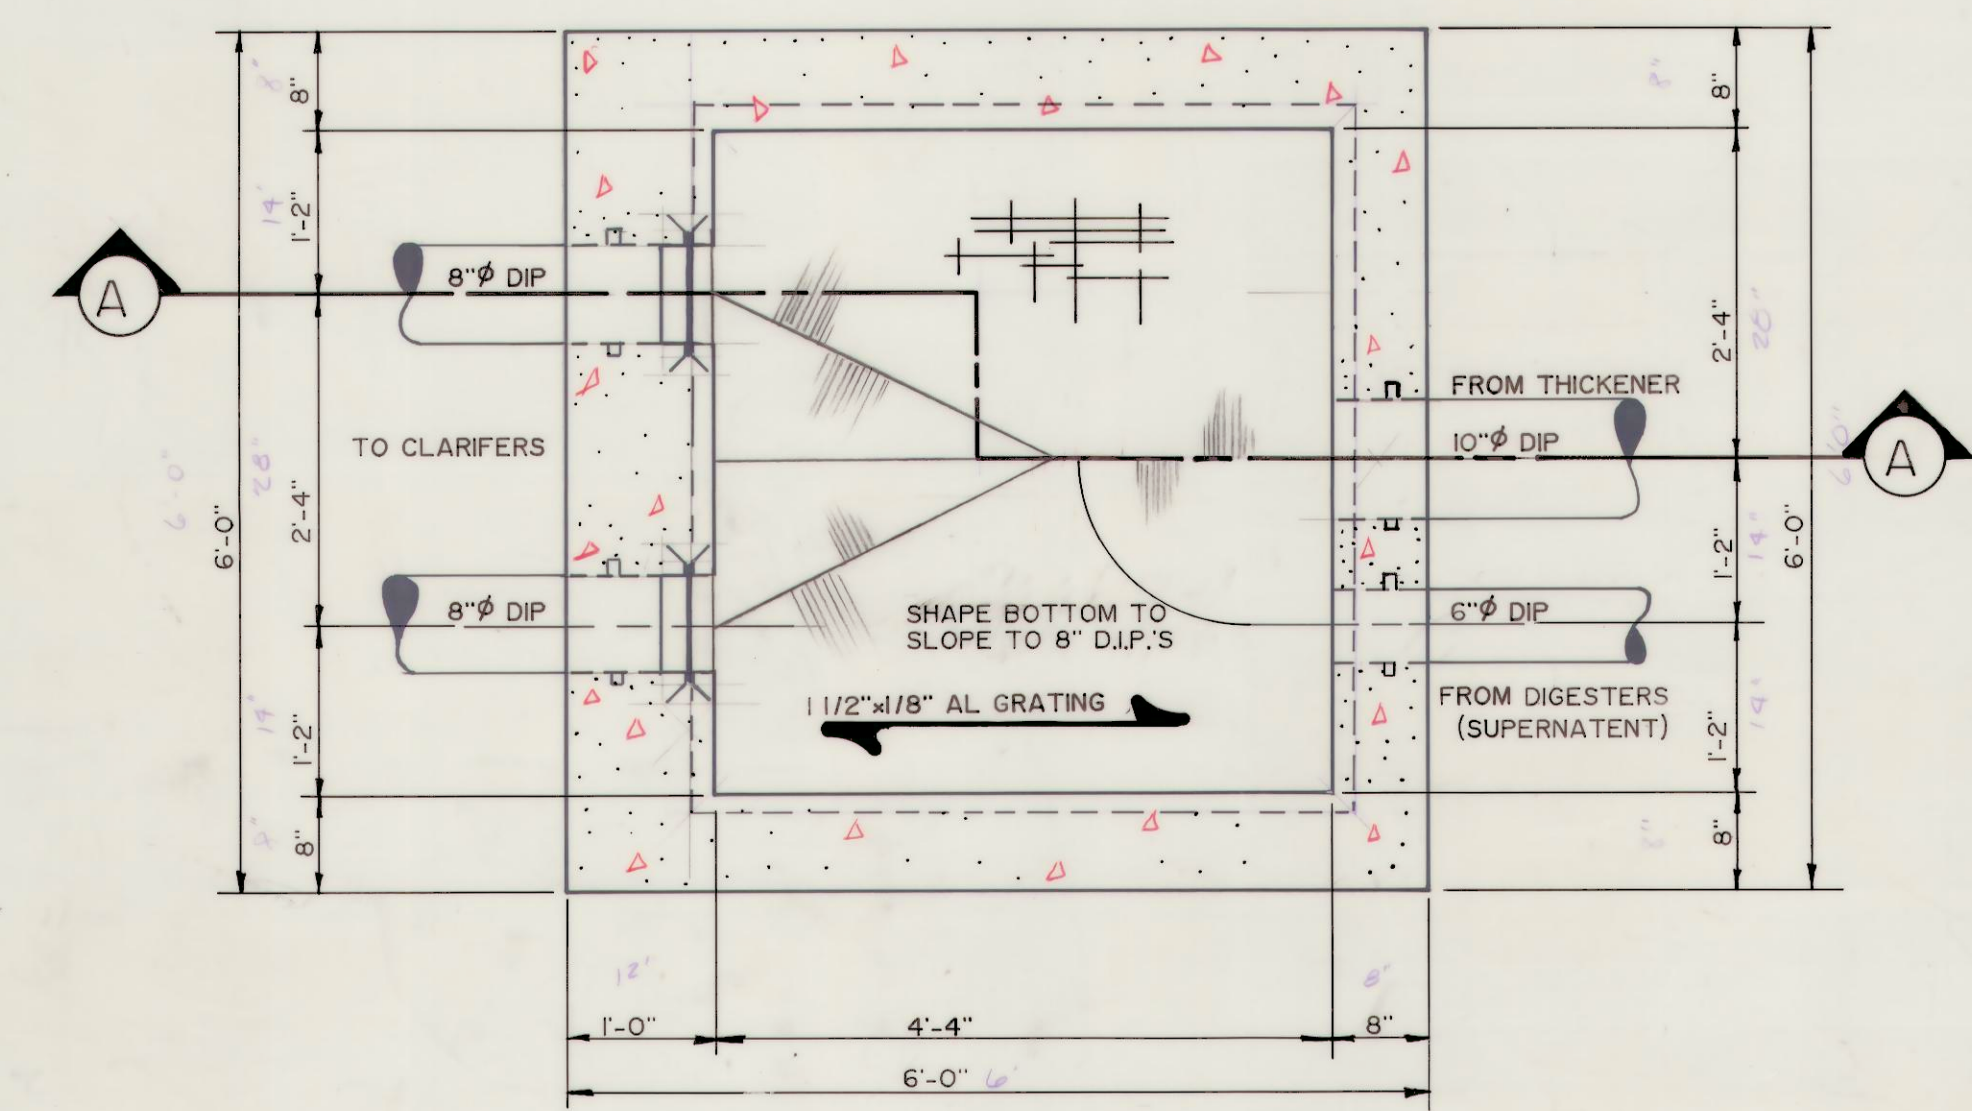


SPLITTER BOX PLAN
 SCALE: 3/4" = 1'-0"

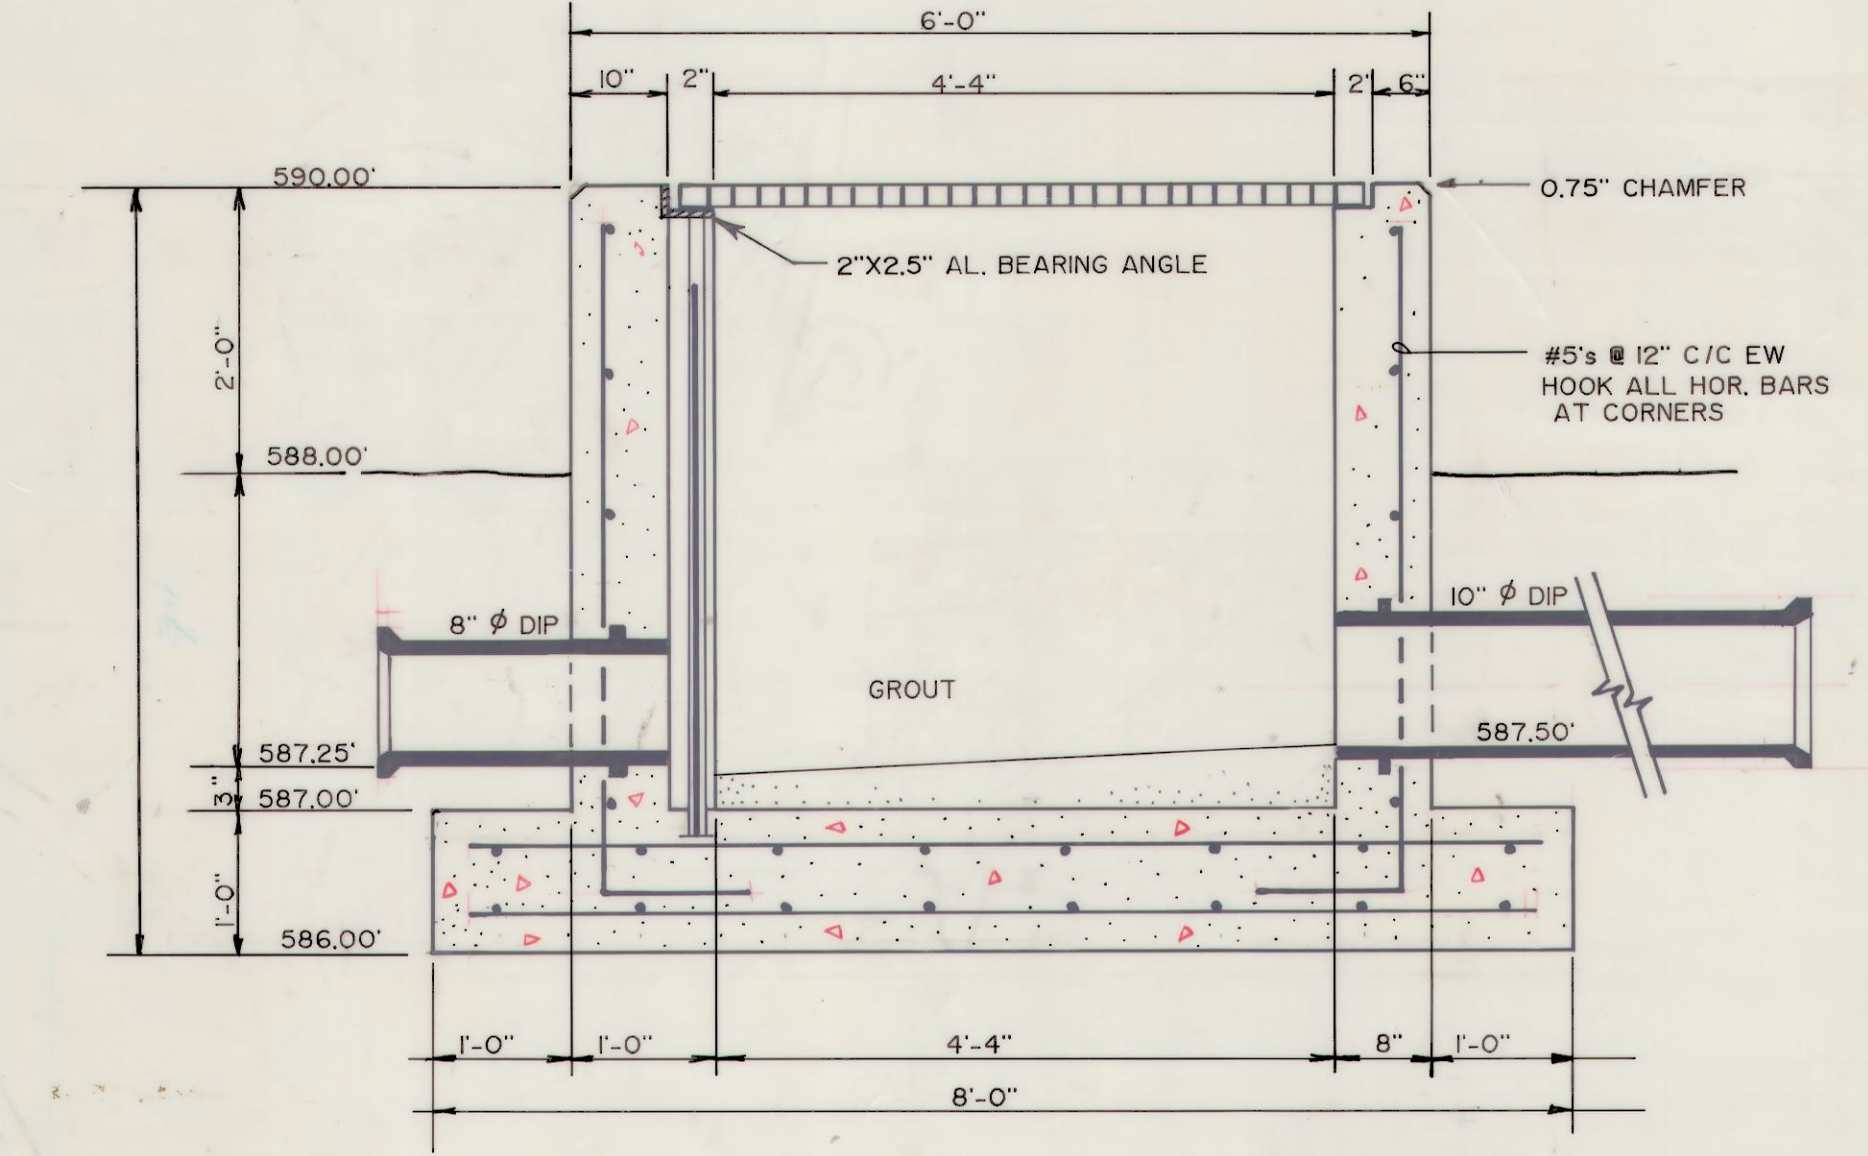

SECTION A-A

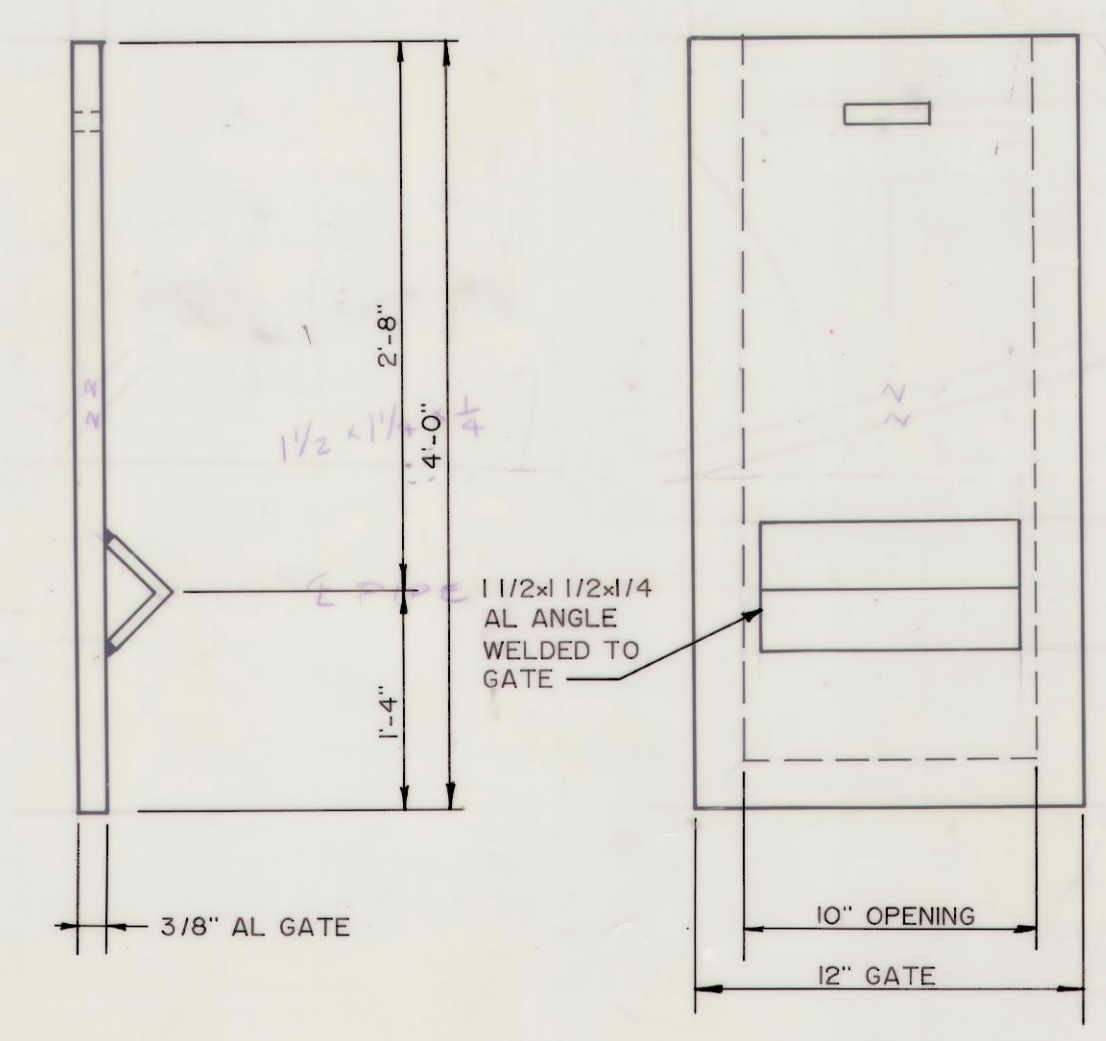

STOP GATE DETAIL
 SCALE: NONE

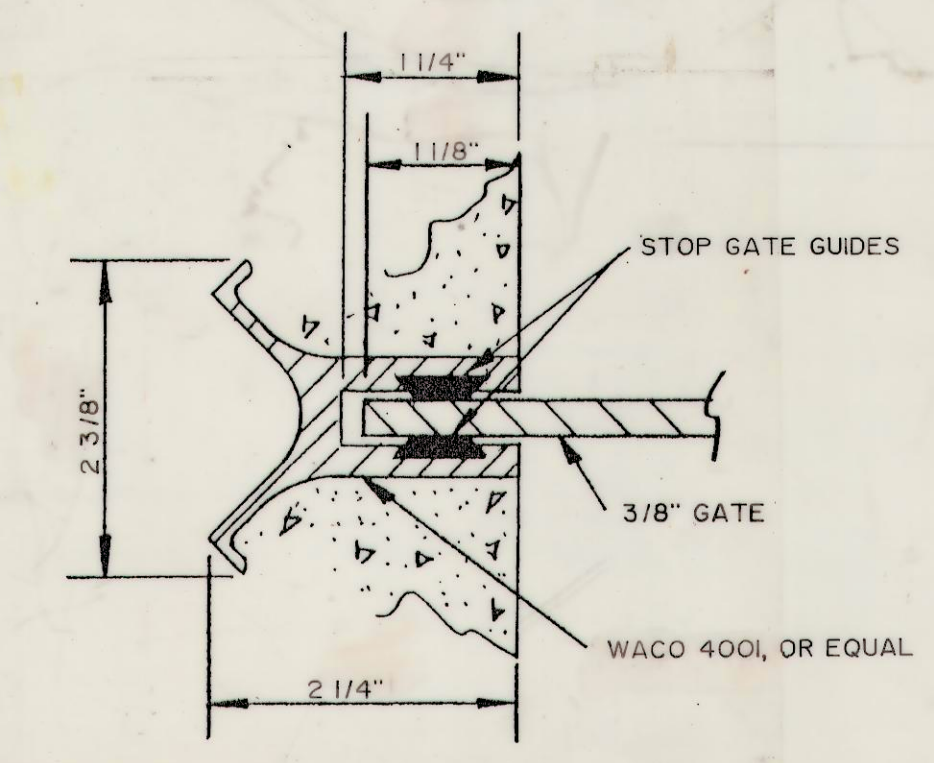

STOP GATE GUIDE DETAIL
 SCALE: NONE