


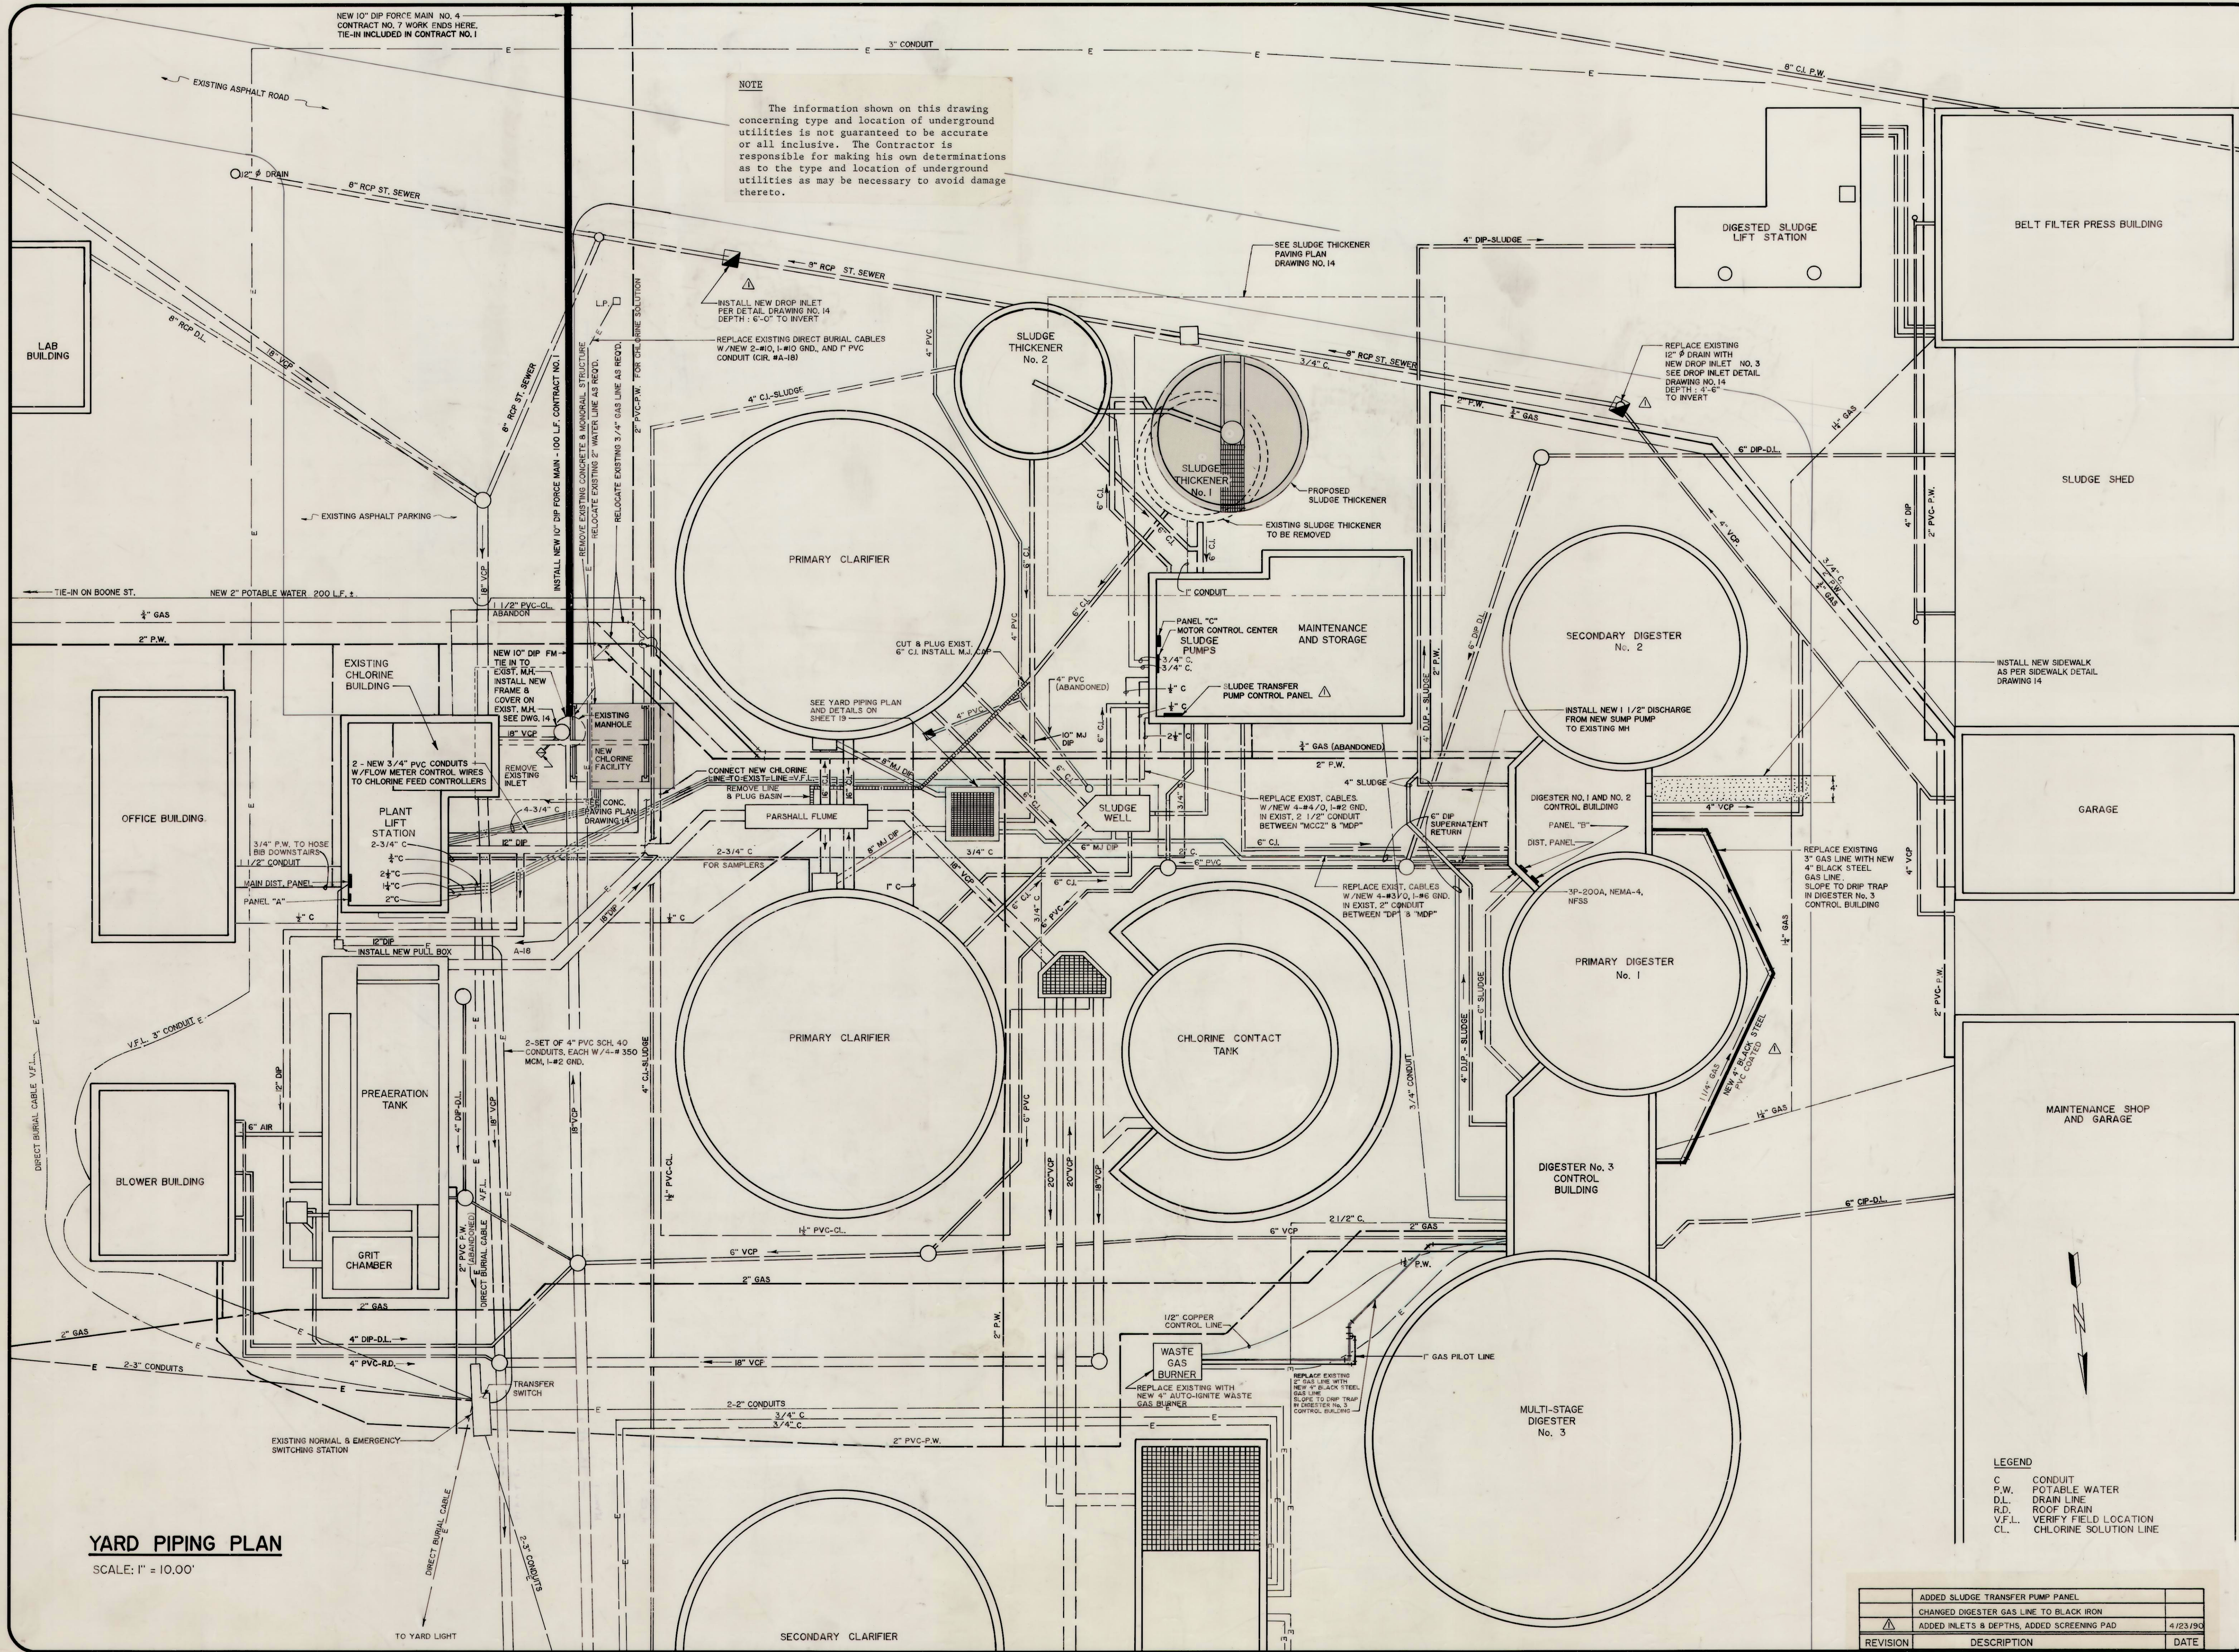

YARD PIPING PLAN
SCALE: 1" = 10.00'

REGISTERED
NO. 6850
STATE OF
WEST VIRGINIA
PROFESSIONAL ENGINEER

CITY OF ST. ALBANS
MUNICIPAL UTILITY COMMISSION
KANAWHA COUNTY, WEST VIRGINIA
WASTEWATER SYSTEM IMPROVEMENTS
EPA PROJECT NO. C-3408B-01

CONTRACT NO. 1

PROJECT INFORMATION

CHAPMAN
TECHNICAL GROUP

DRAWING TITLE

YARD PIPING AND
ELECTRICAL SITE PLAN

DRAWN
R. OSBORNE

CHECKED
G. BELCHER

DATE
MARCH 1989

SCALE
1" = 10.00'

PROJECT NUMBER
87016

DRAWING NUMBER

2-1