



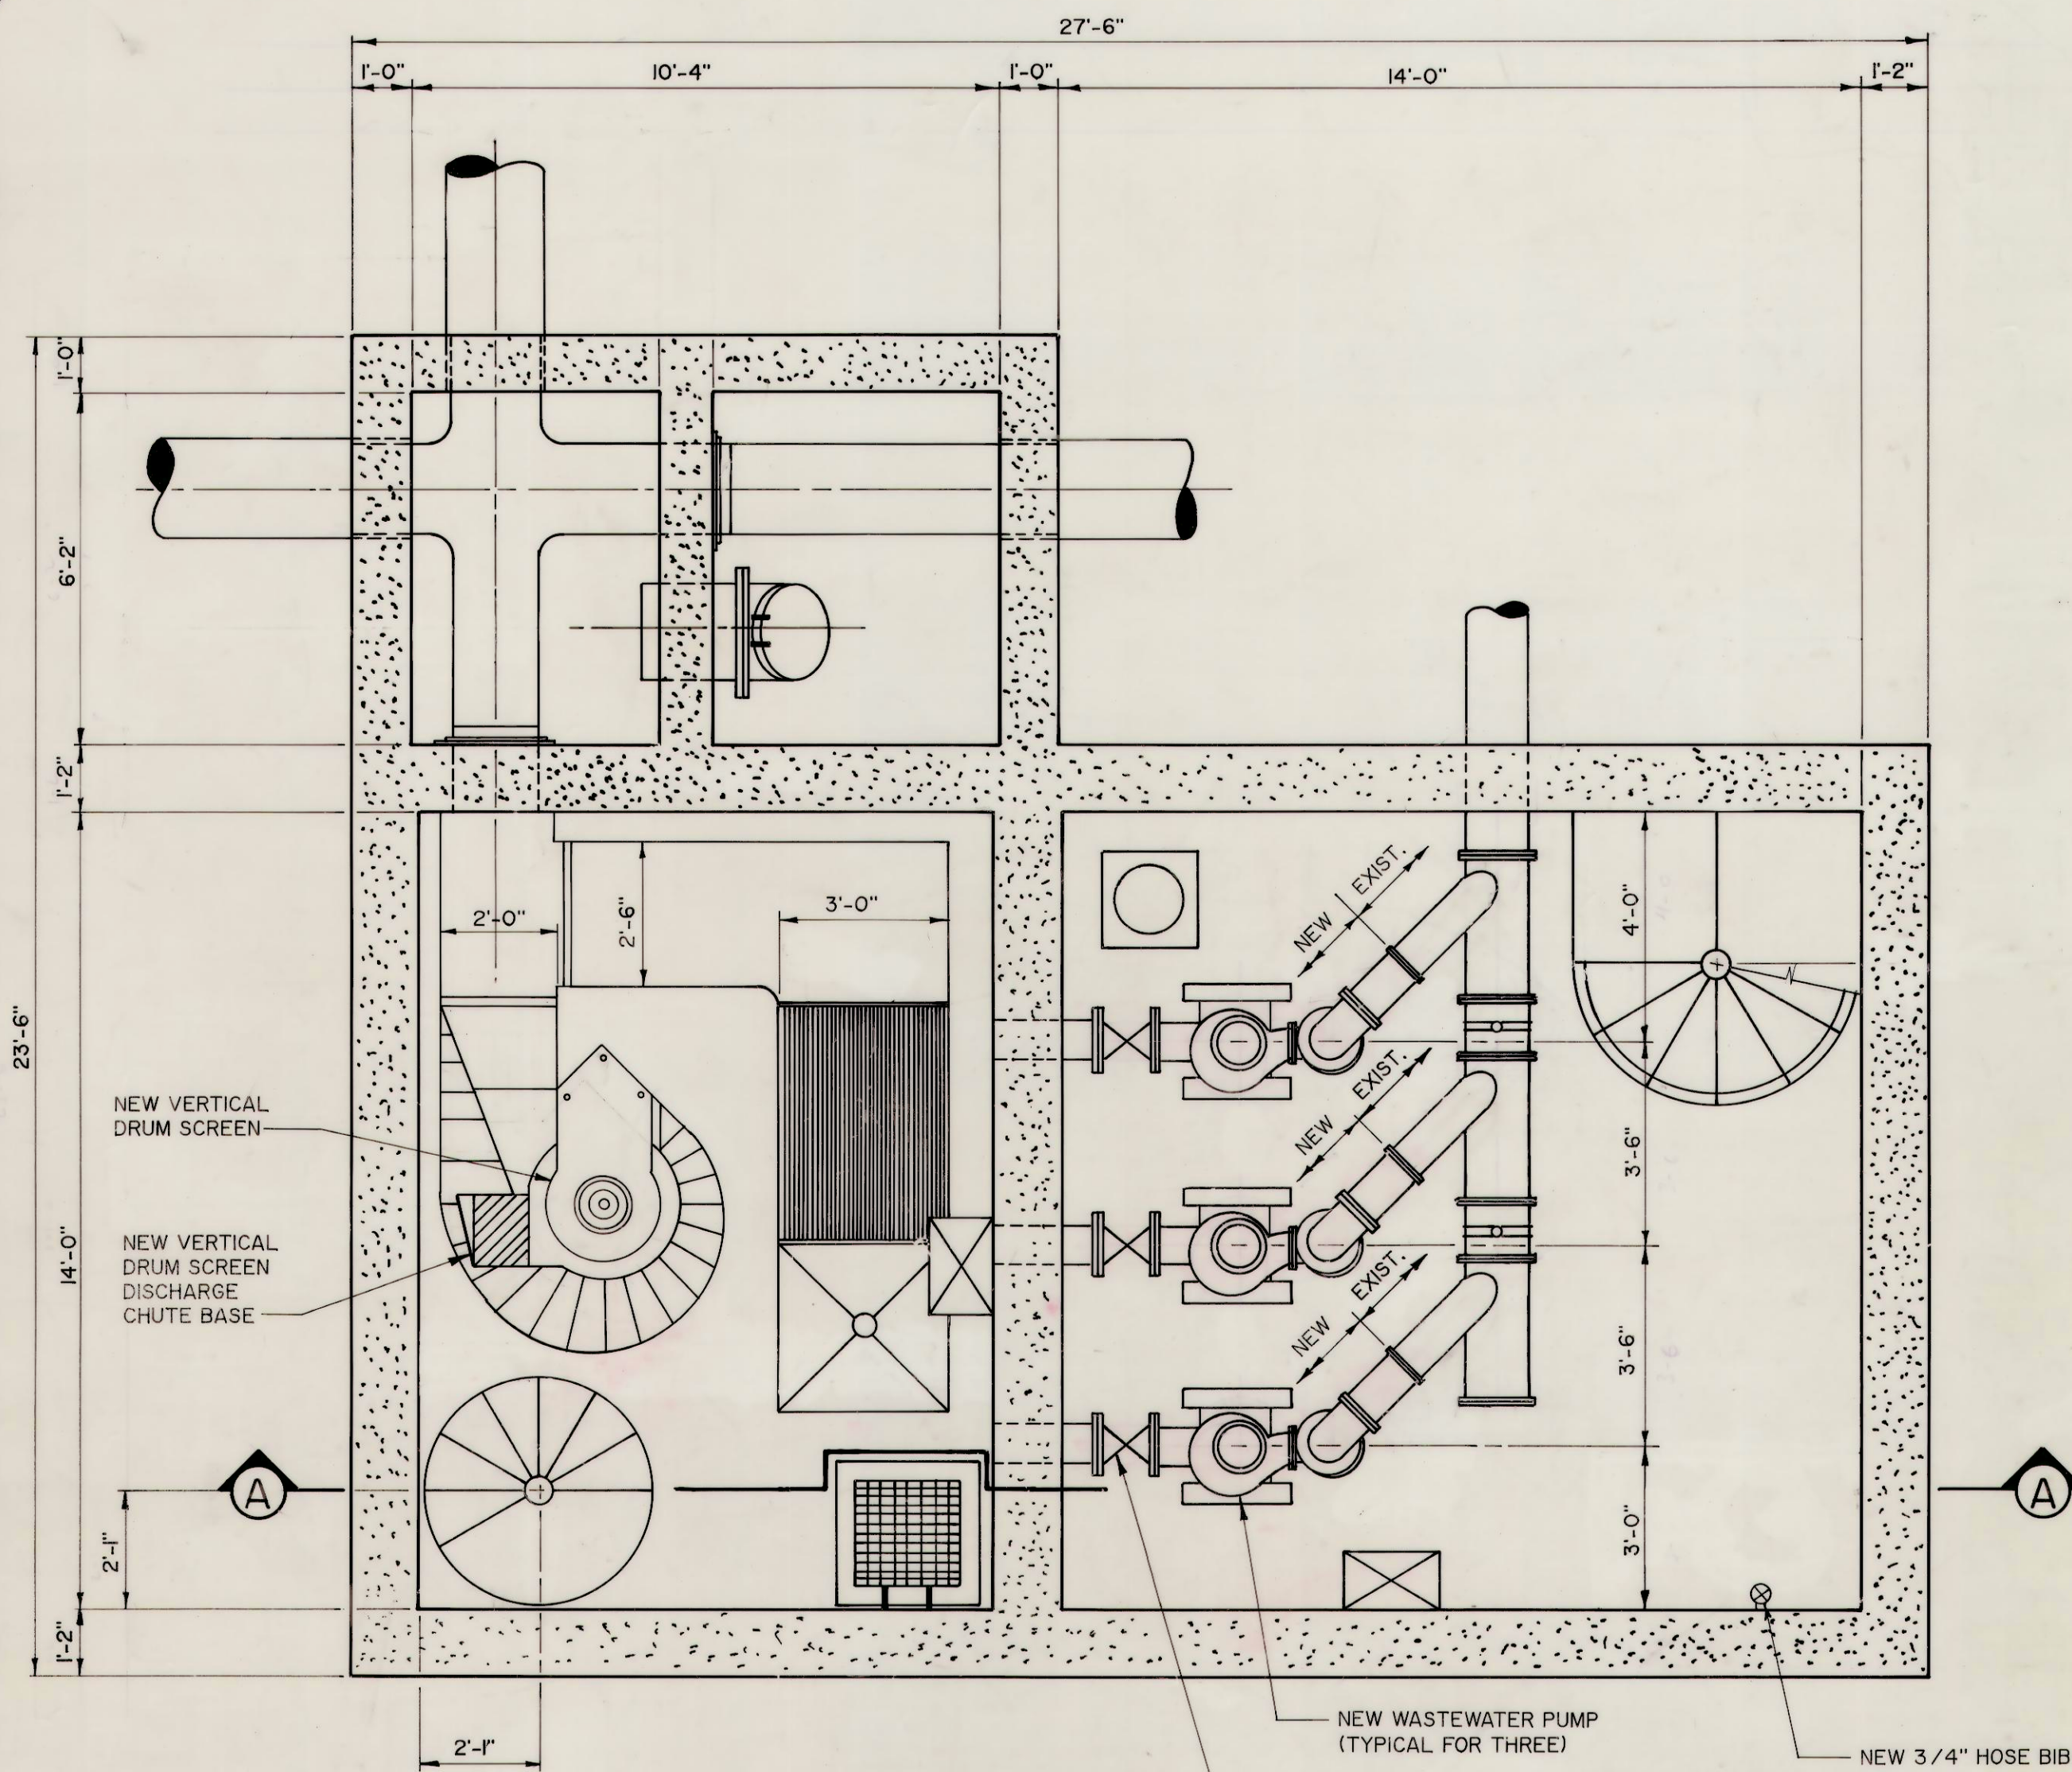


PROPOSED PLAN - LOWER LEVEL
EL. 574.56'

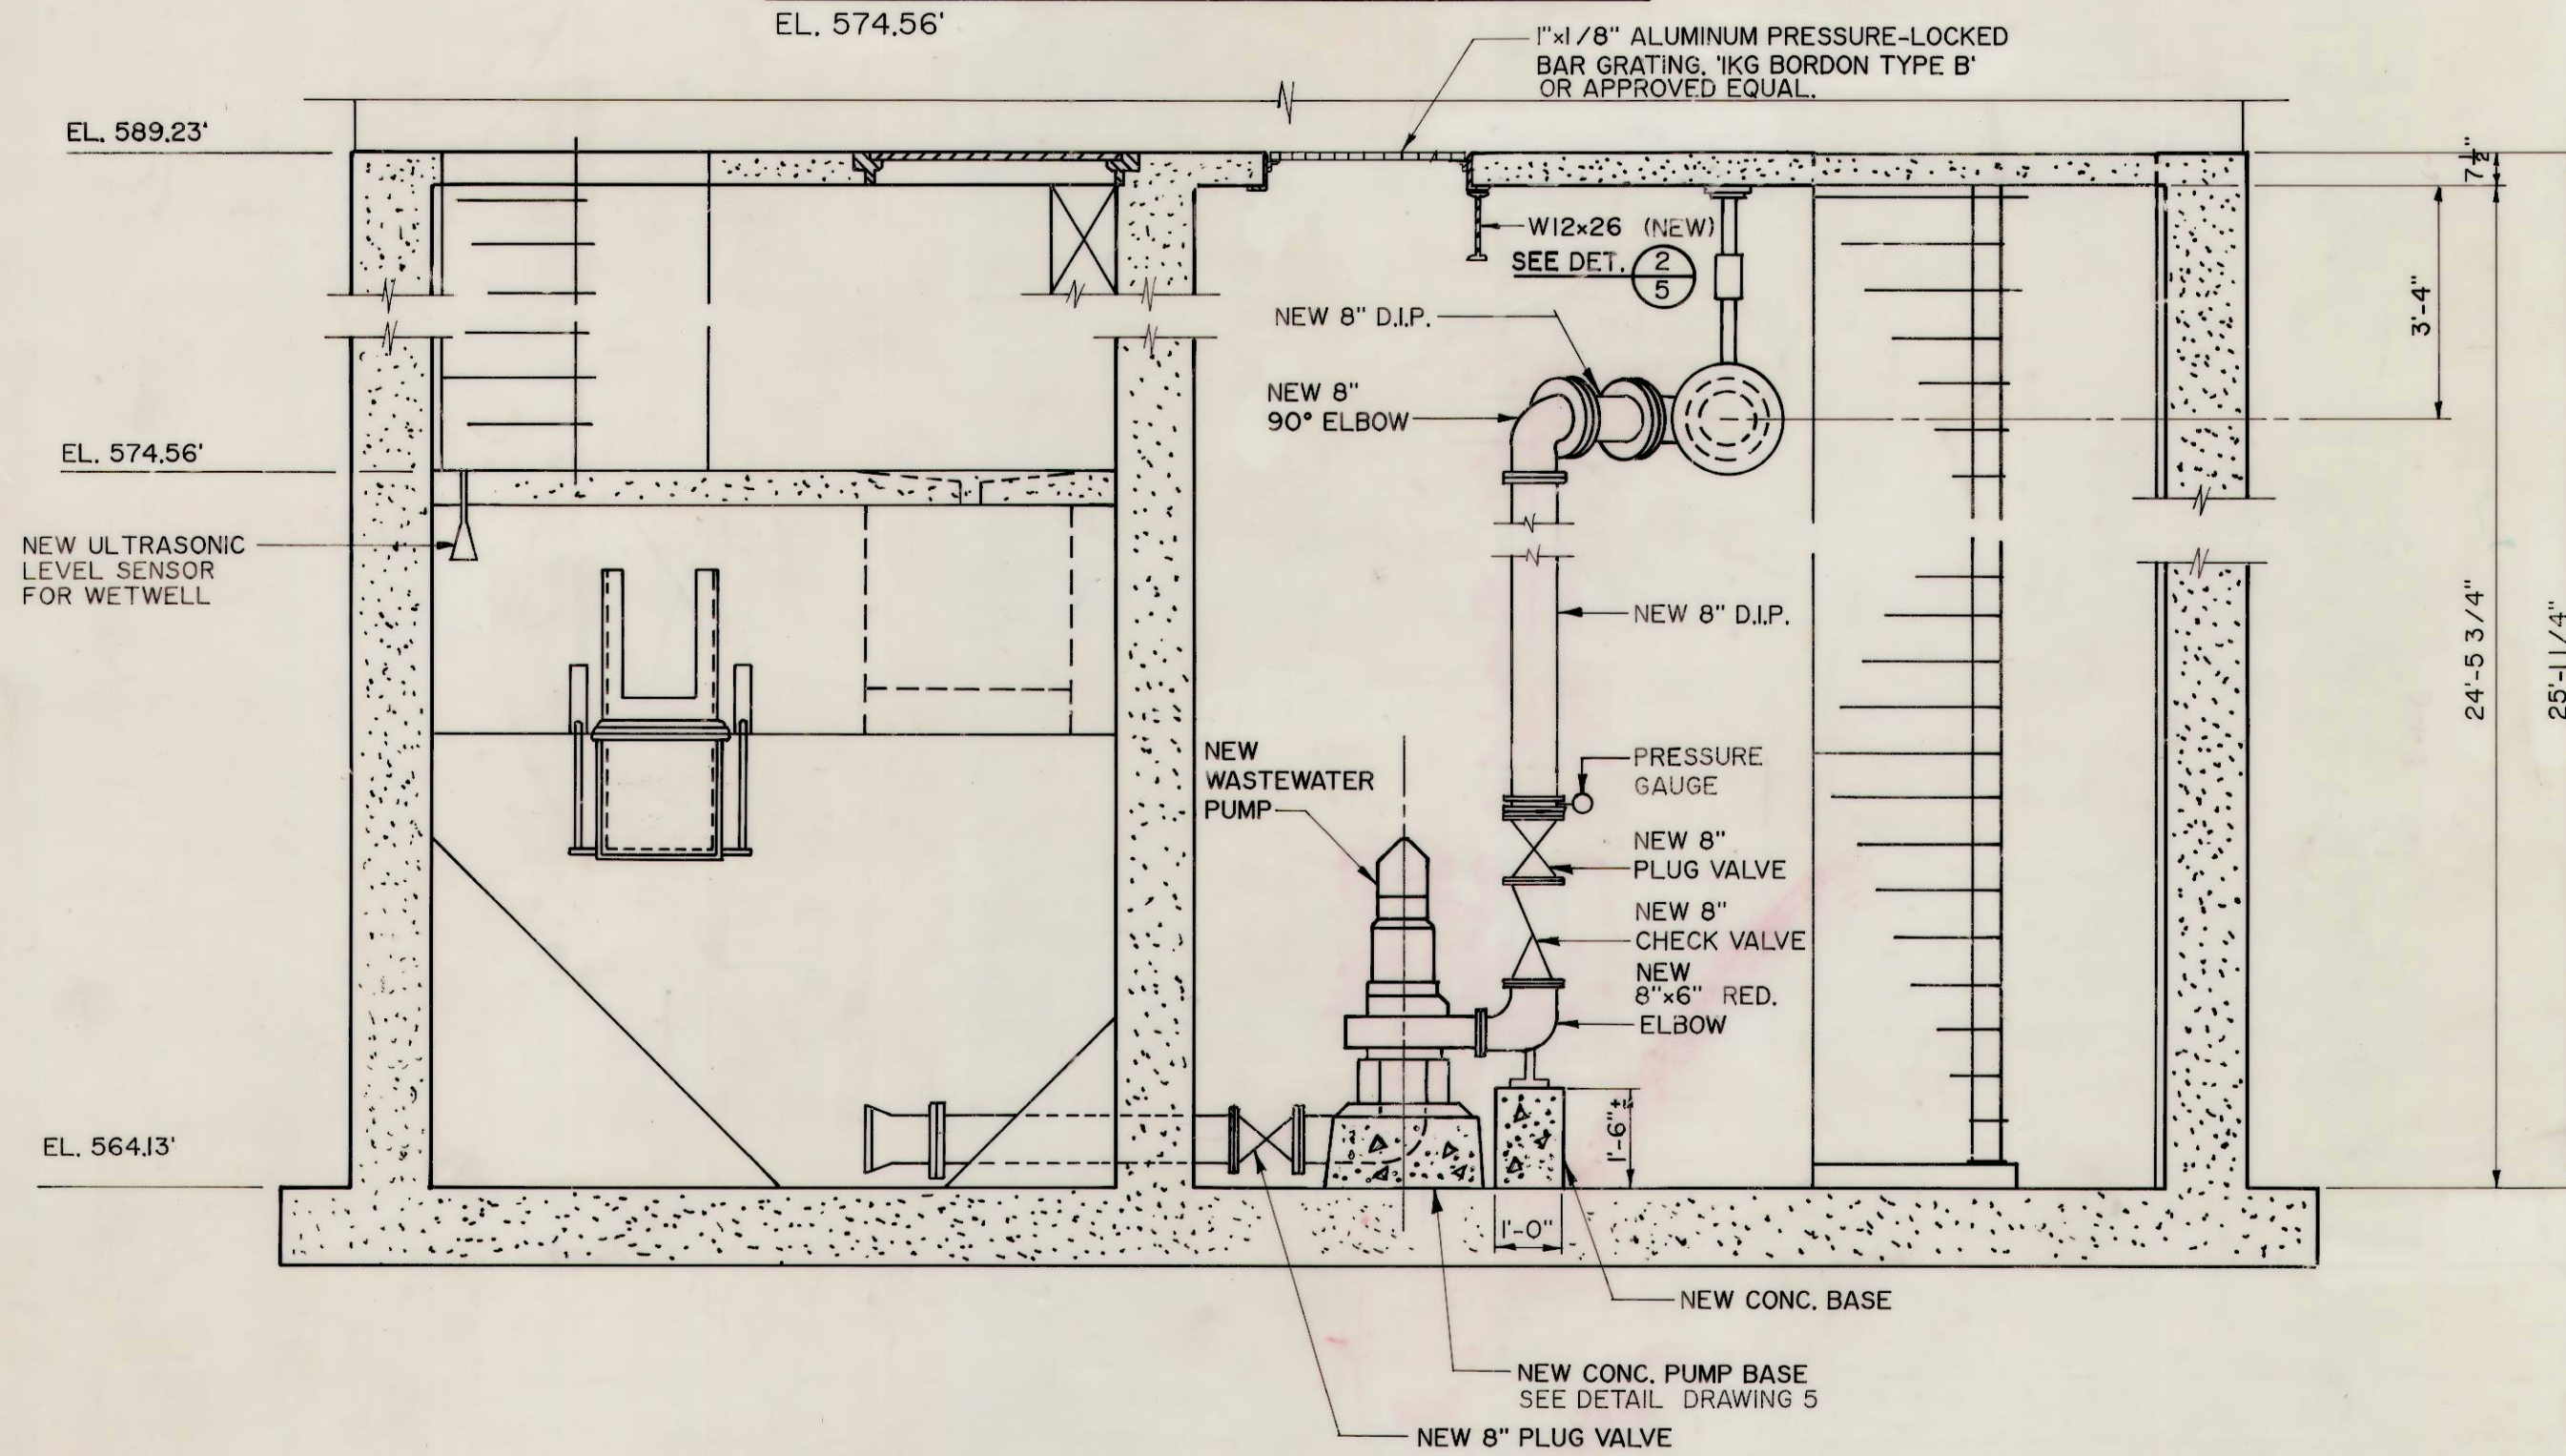


A SECTION

- NOTES:
1. [LS-1] DOOR HARDWARE REFERENCE (SEE SPECIFICATIONS).
 2. SEE DRAWING No. 15 FOR ELECTRICAL AND MECHANICAL PLANS.
 3. [LS-2] DOOR & FRAME MUST PROVIDE AIRTIGHT SEAL WHEN CLOSED.

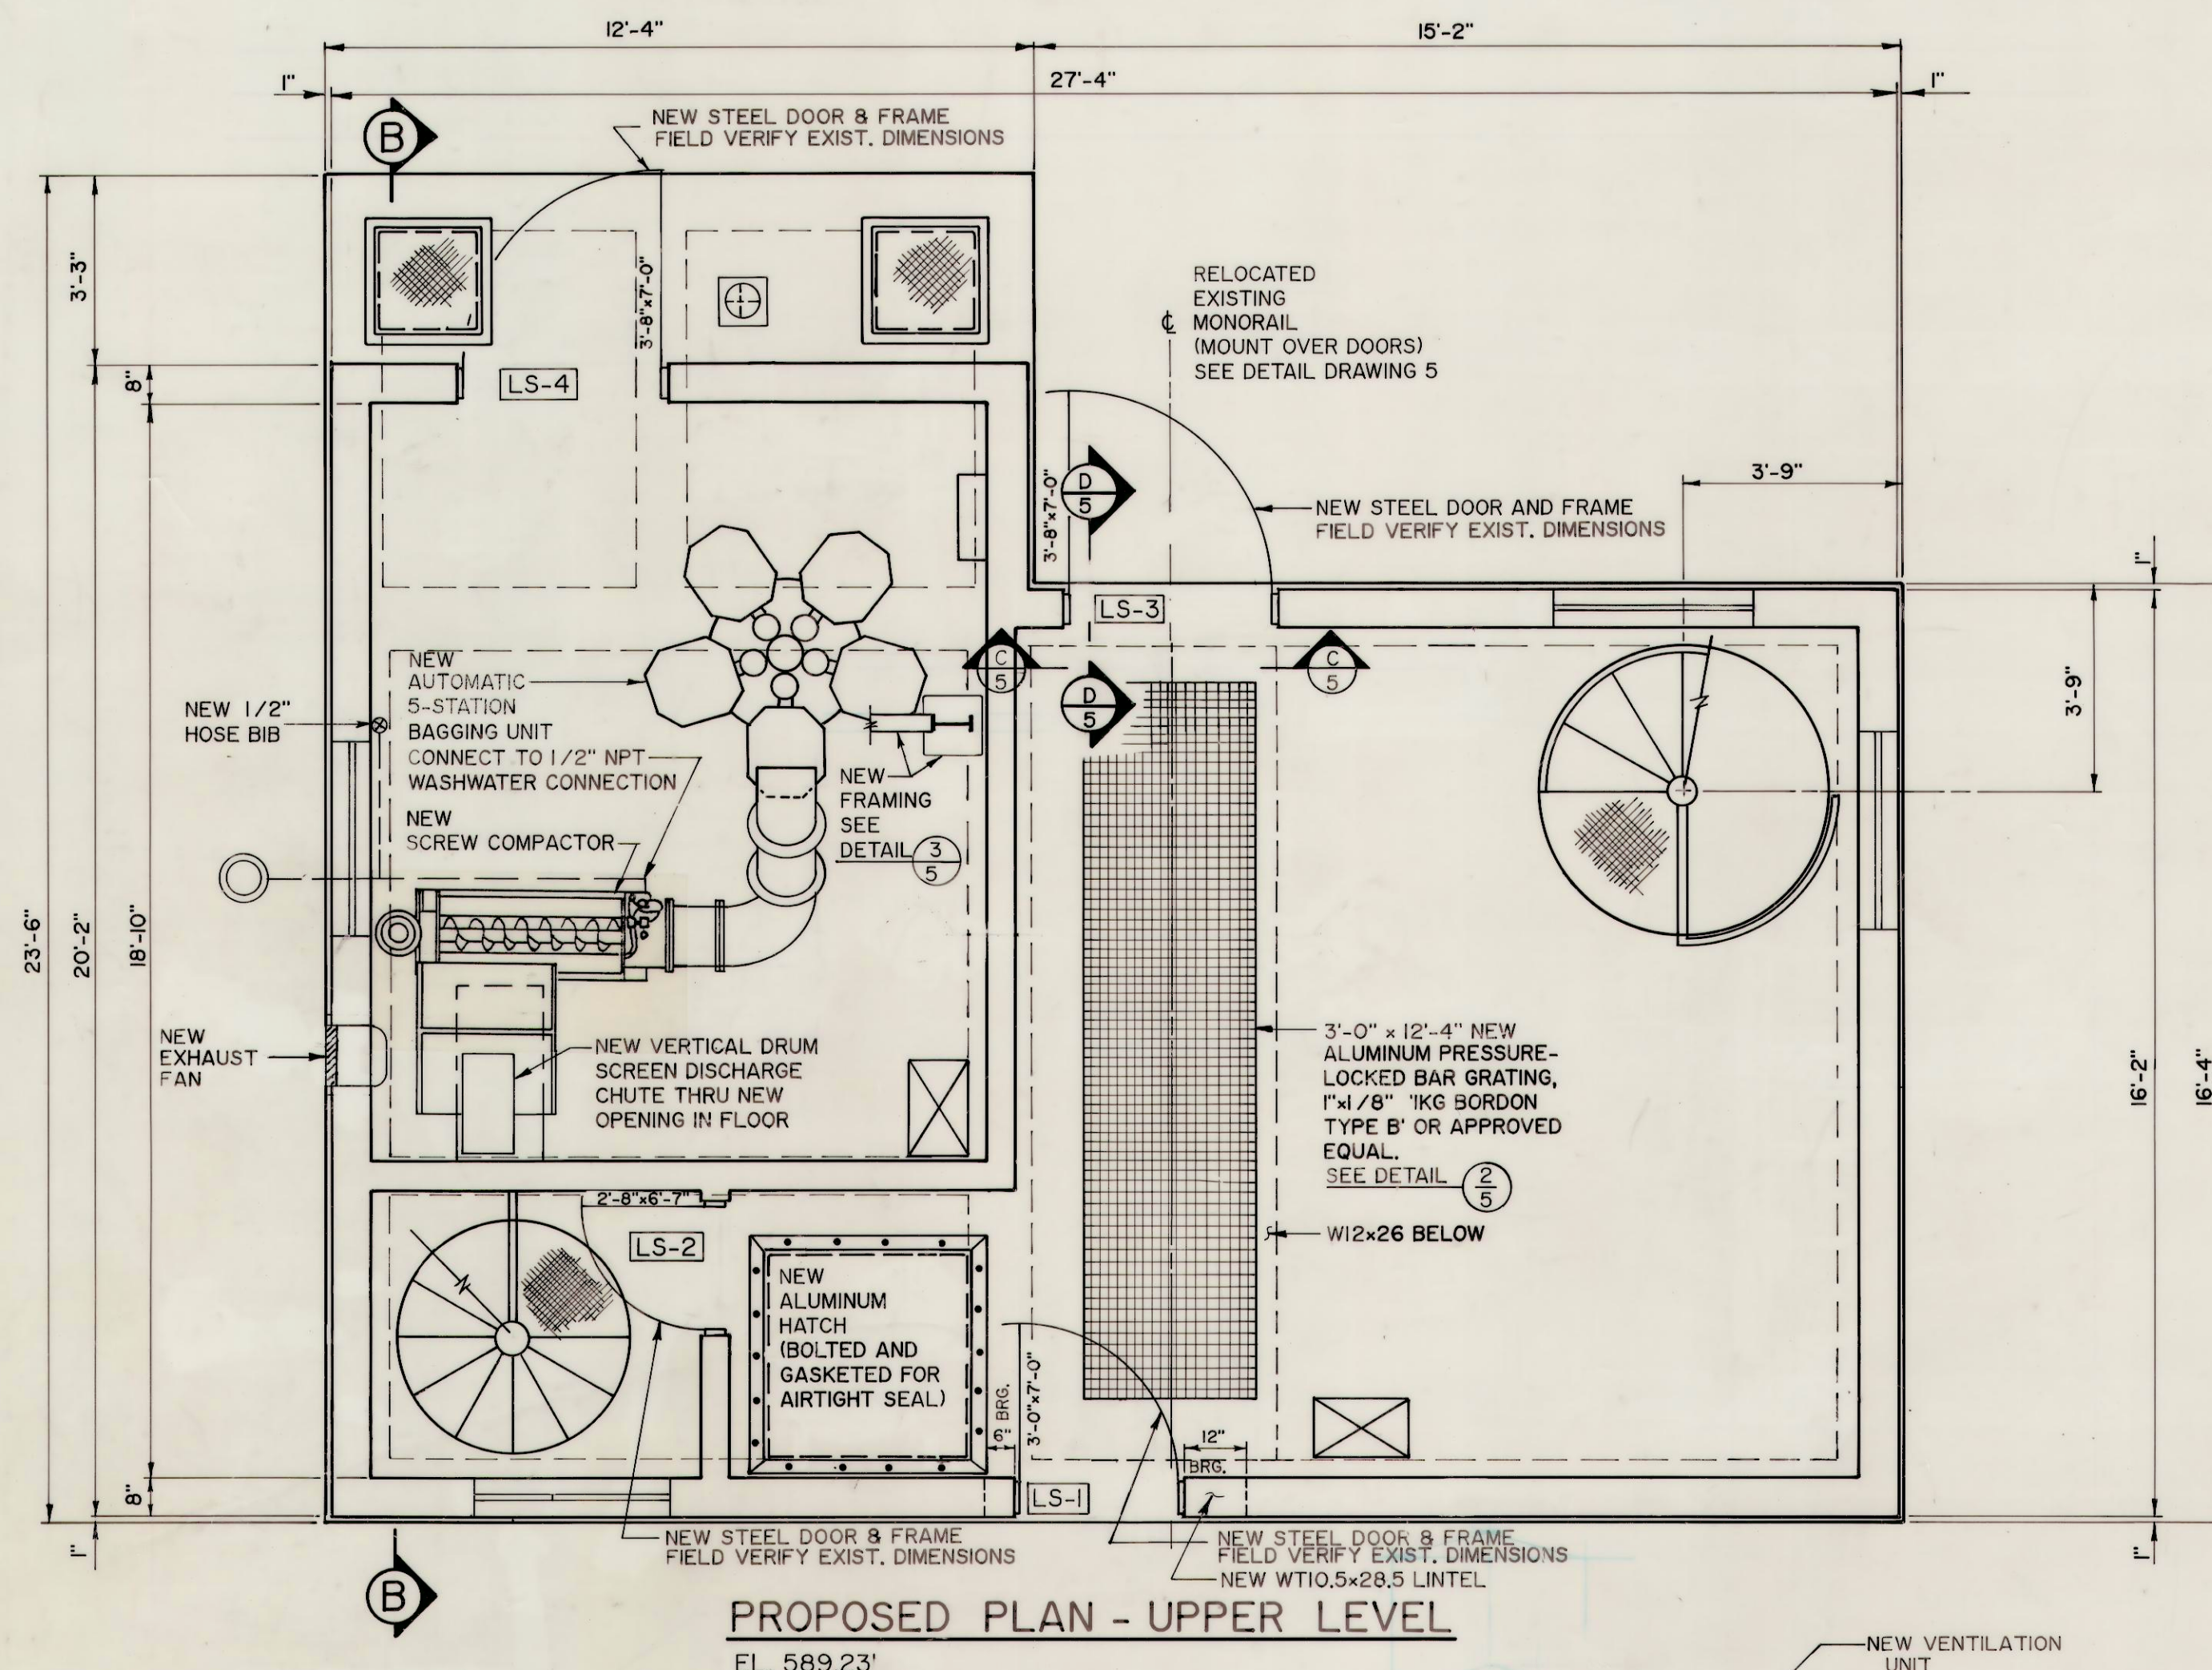

PROPOSED PLAN - UPPER LEVEL
EL. 589.23'

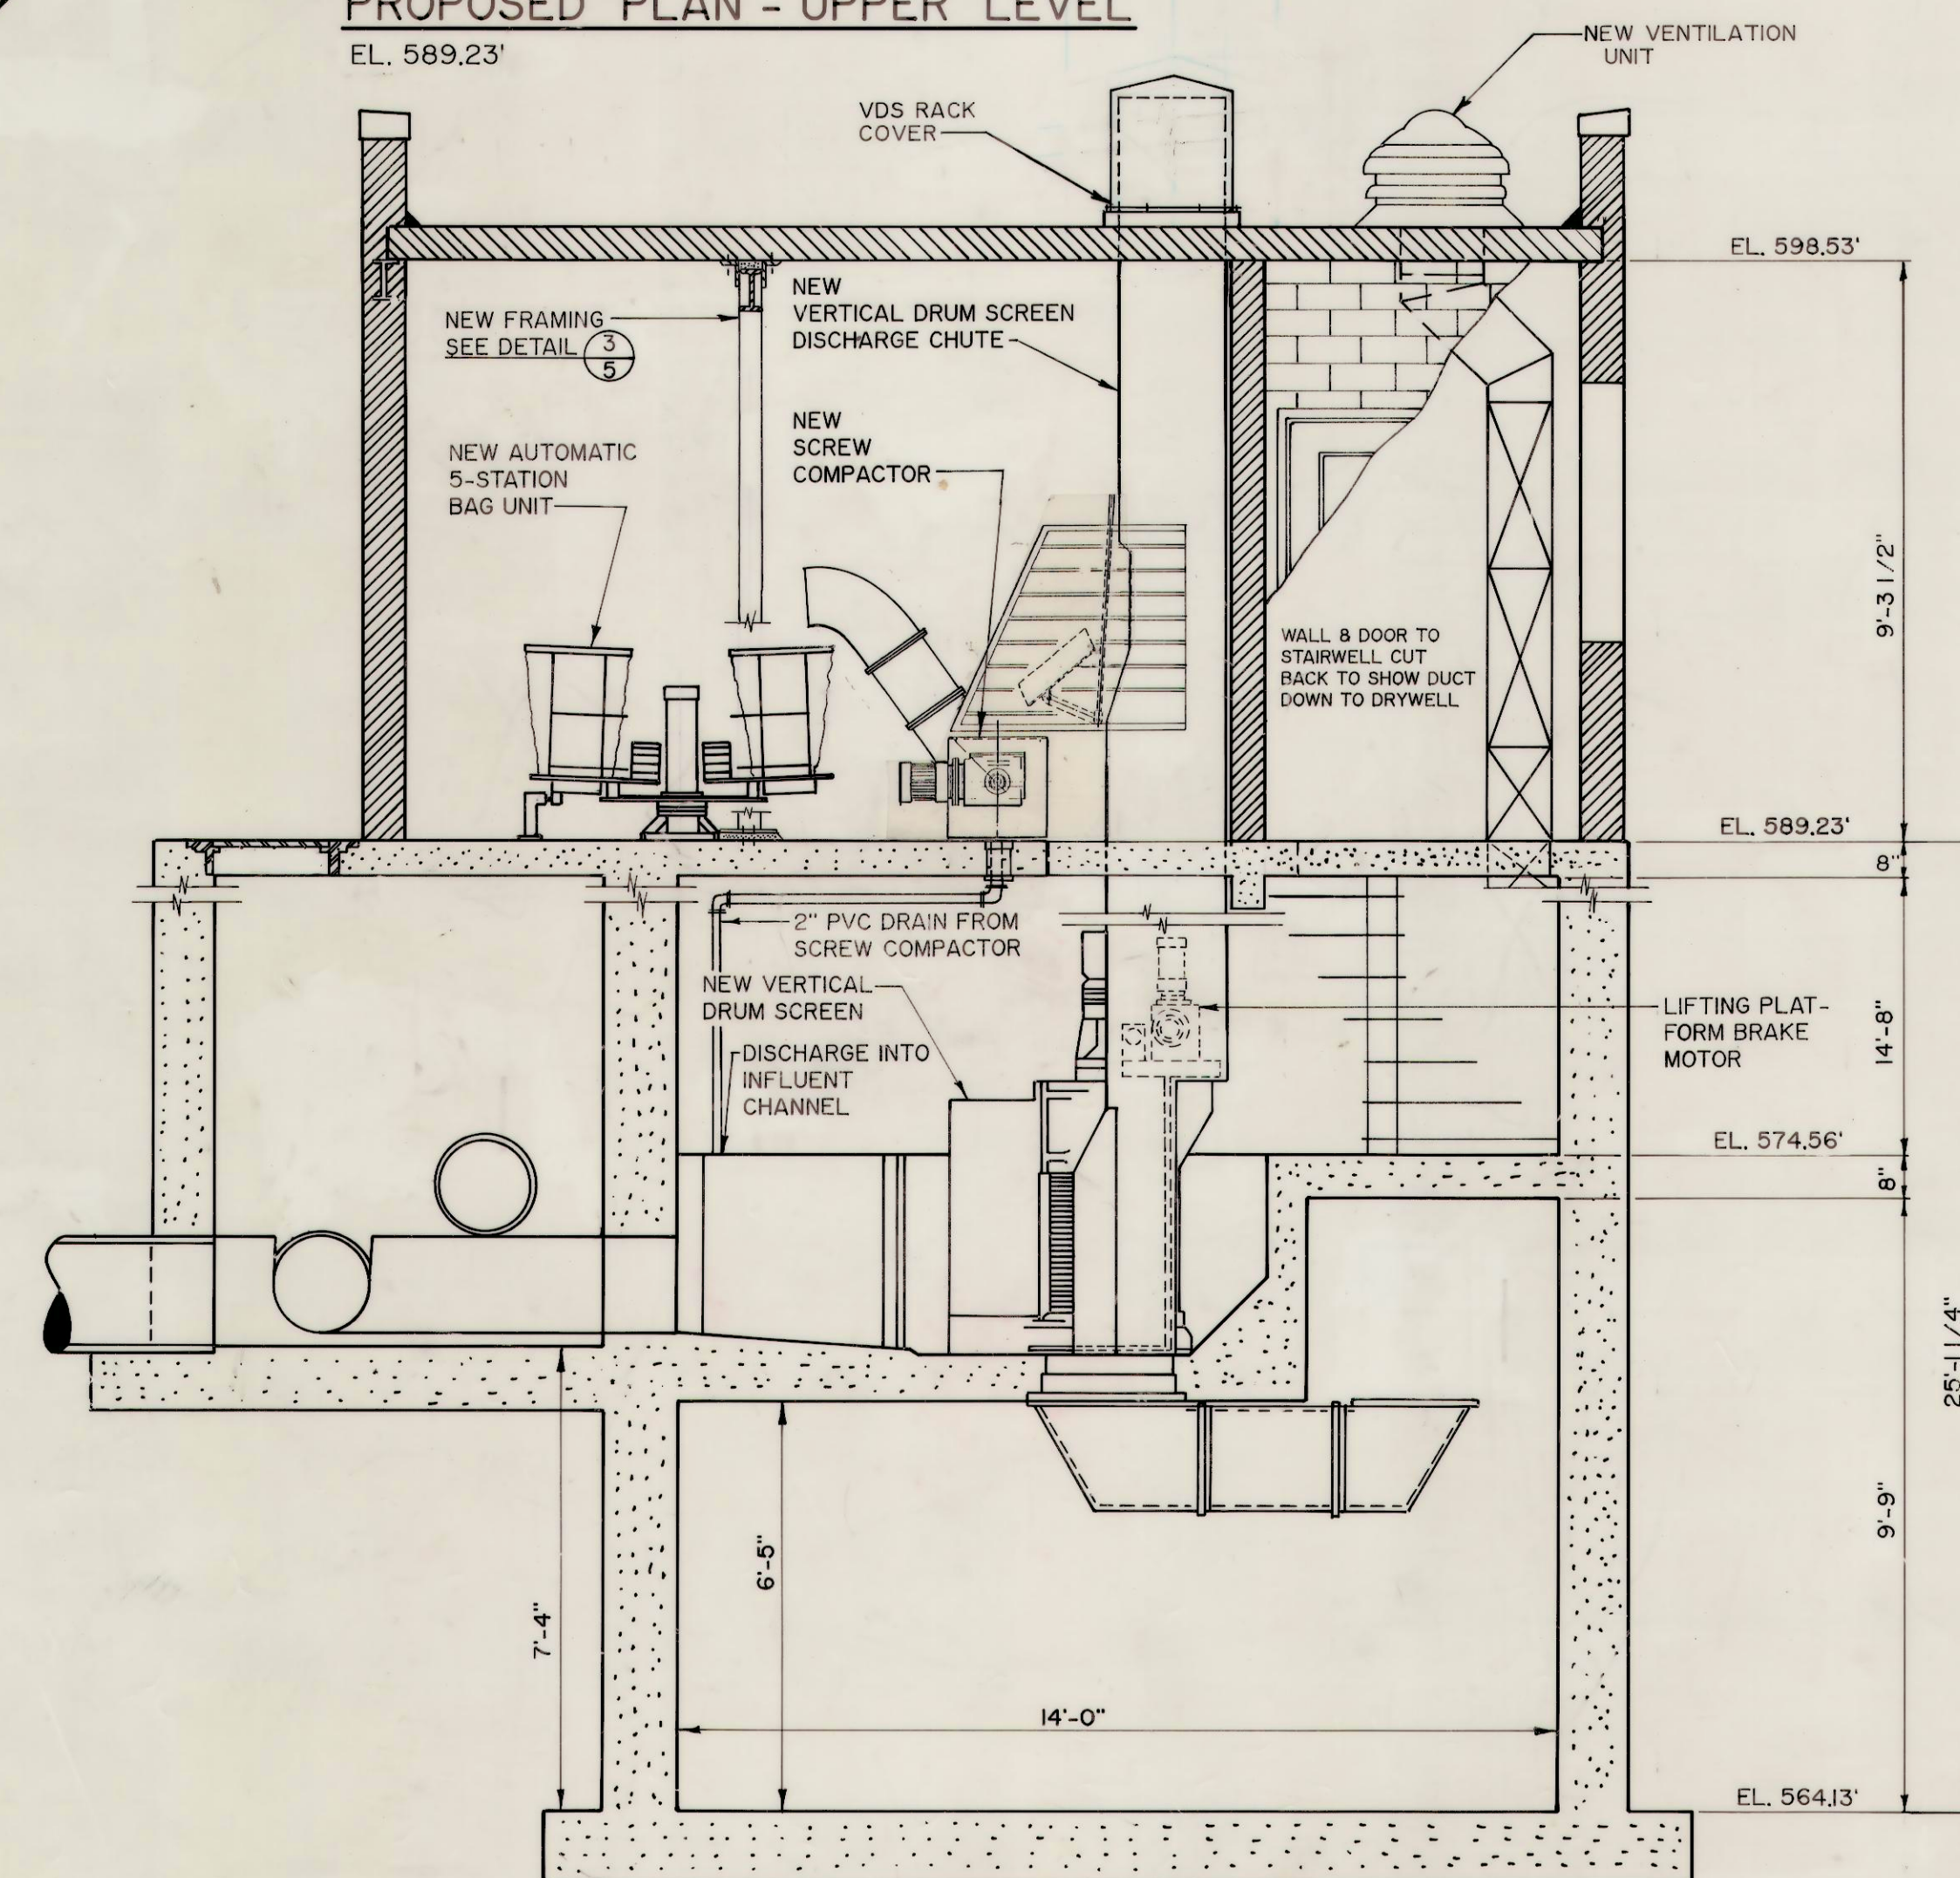

B SECTION

PROJECT INFORMATION

CITY OF ST. ALBANS
MUNICIPAL UTILITY COMMISSION
KANAWHA COUNTY, WEST VIRGINIA
WASTEWATER SYSTEM IMPROVEMENTS
EPA PROJECT NO. C-5406B-01
CONTRACT NO. 1

Chapman Technical Group

DRAWING TITLE

**PLANT LIFT STATION
PROPOSED PLANS
AND SECTIONS**

DRAWN
R. OSBORNE

CHECKED
G. BELCHER

DATE
APRIL, 1989

SCALE
3/8" = 1'-0"

PROJECT NUMBER
87016

DRAWING NUMBER
4