




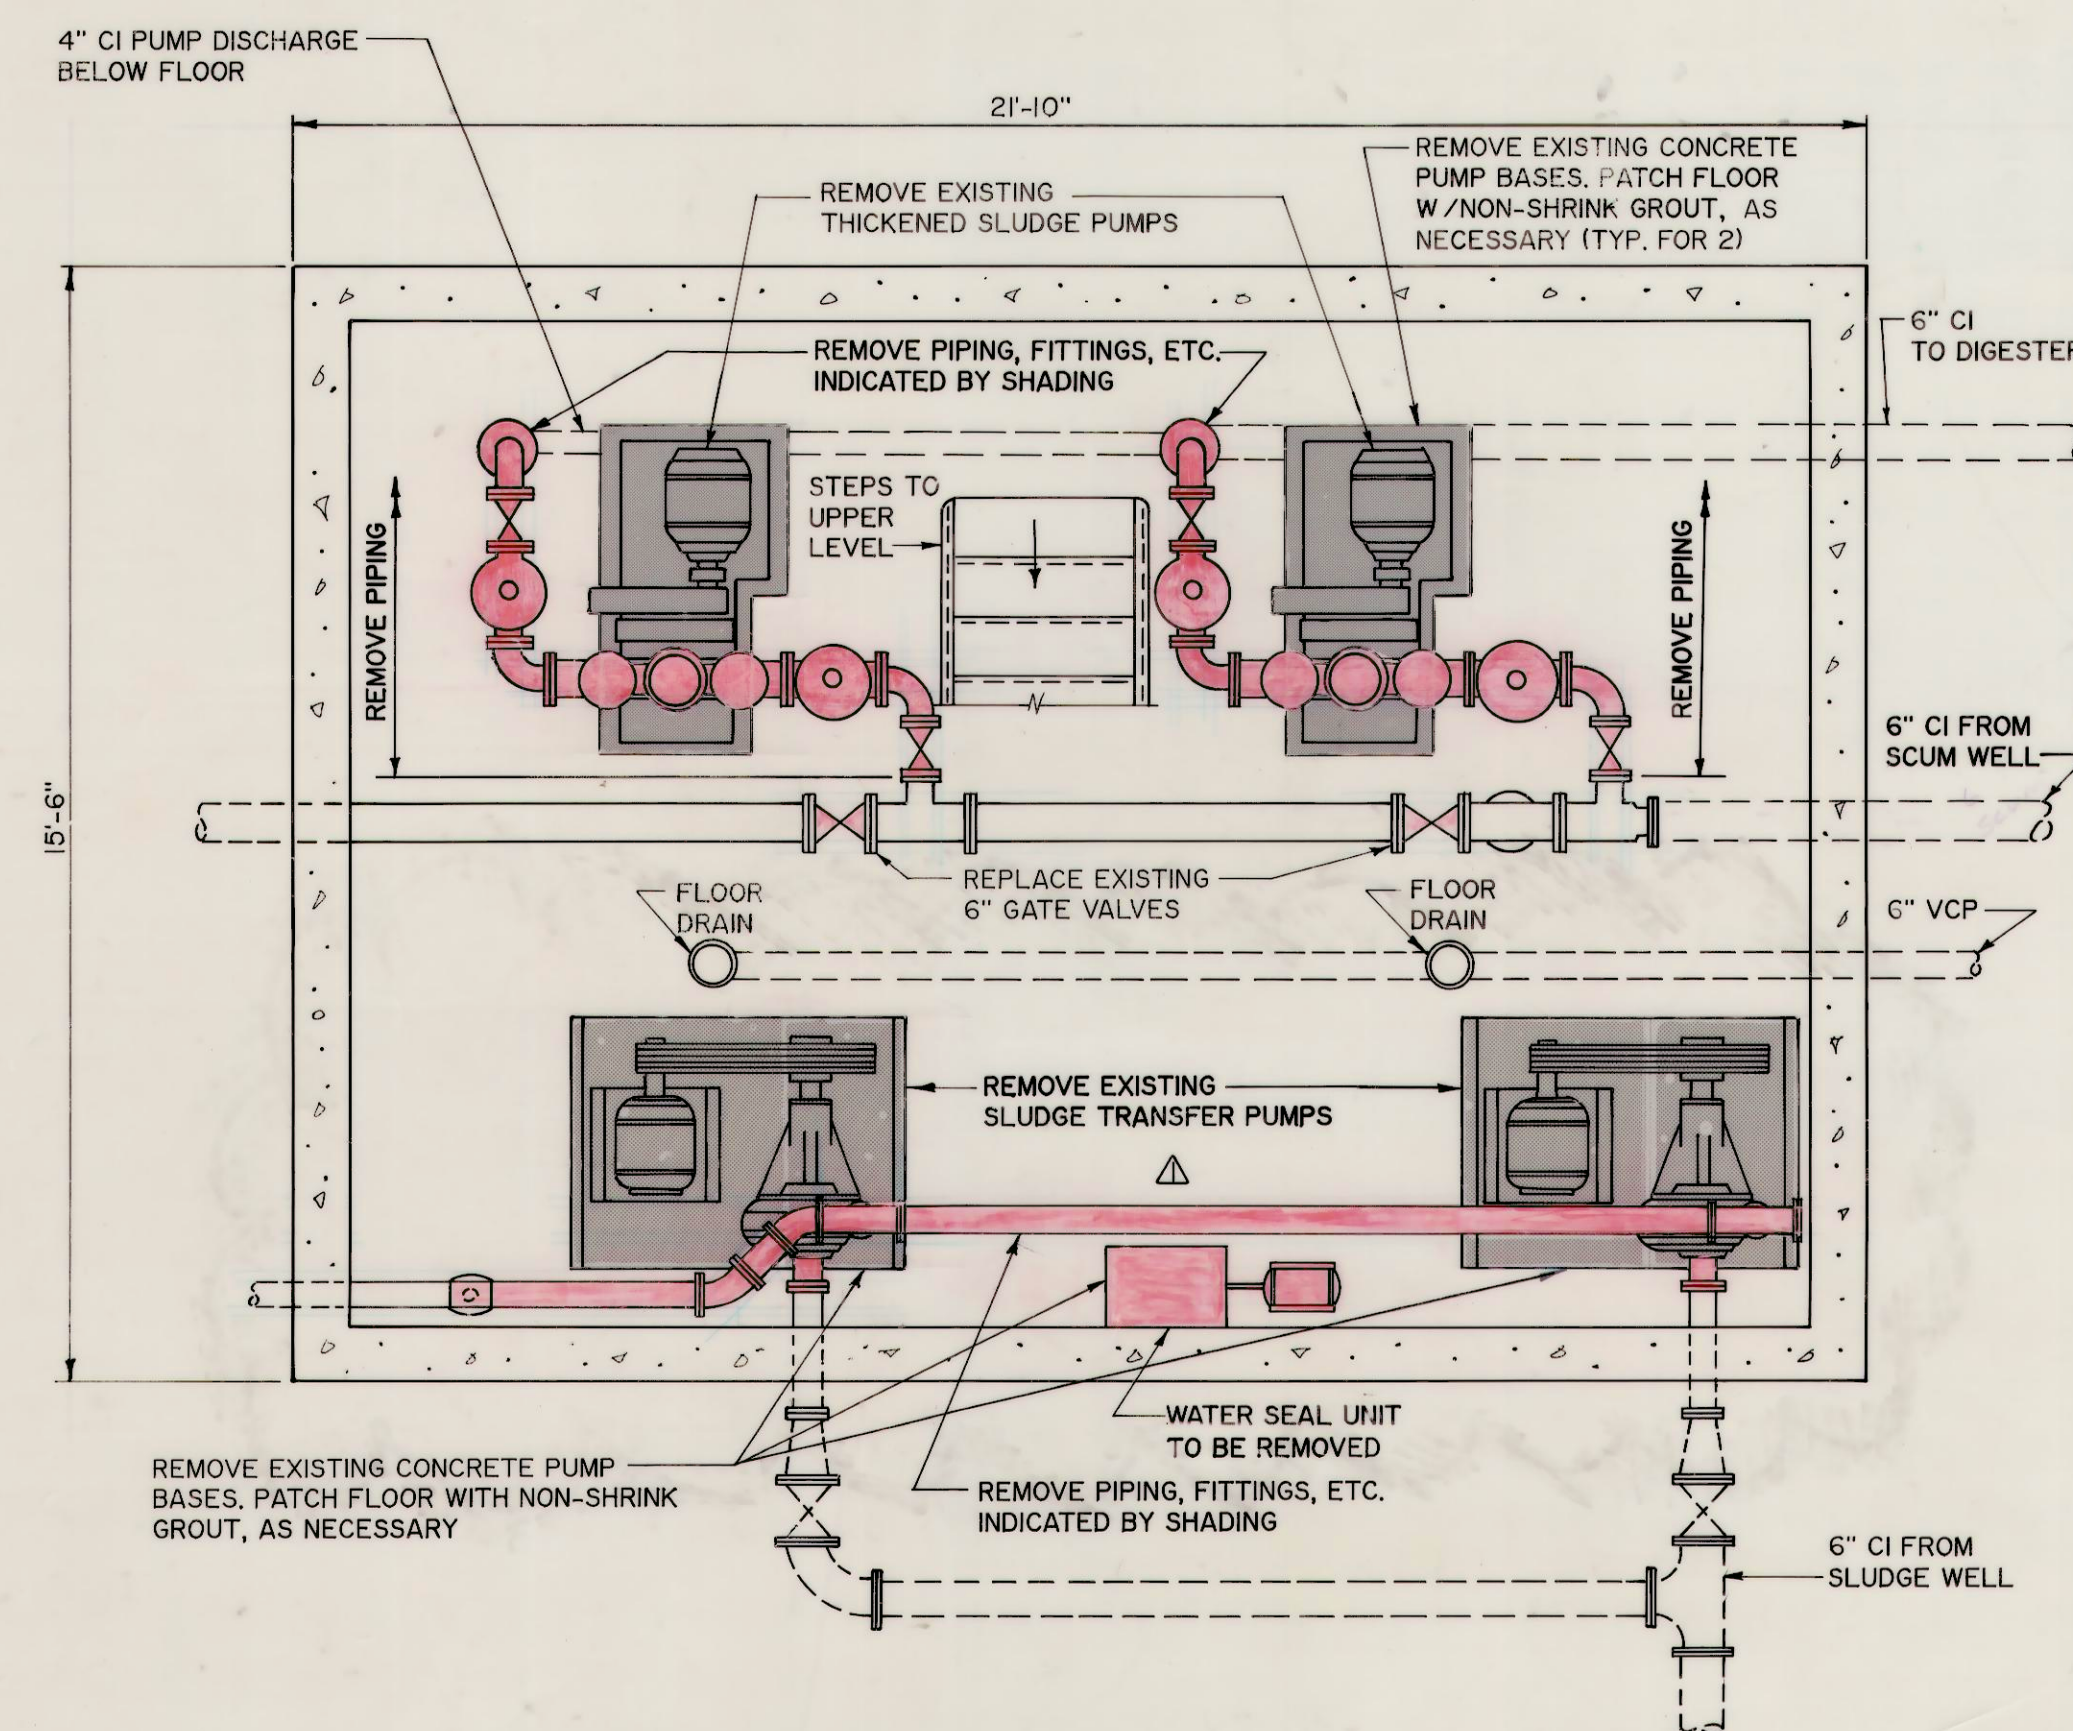


EXISTING PLAN - LOWER LEVEL
 SCALE: 3/8" = 1'-0"

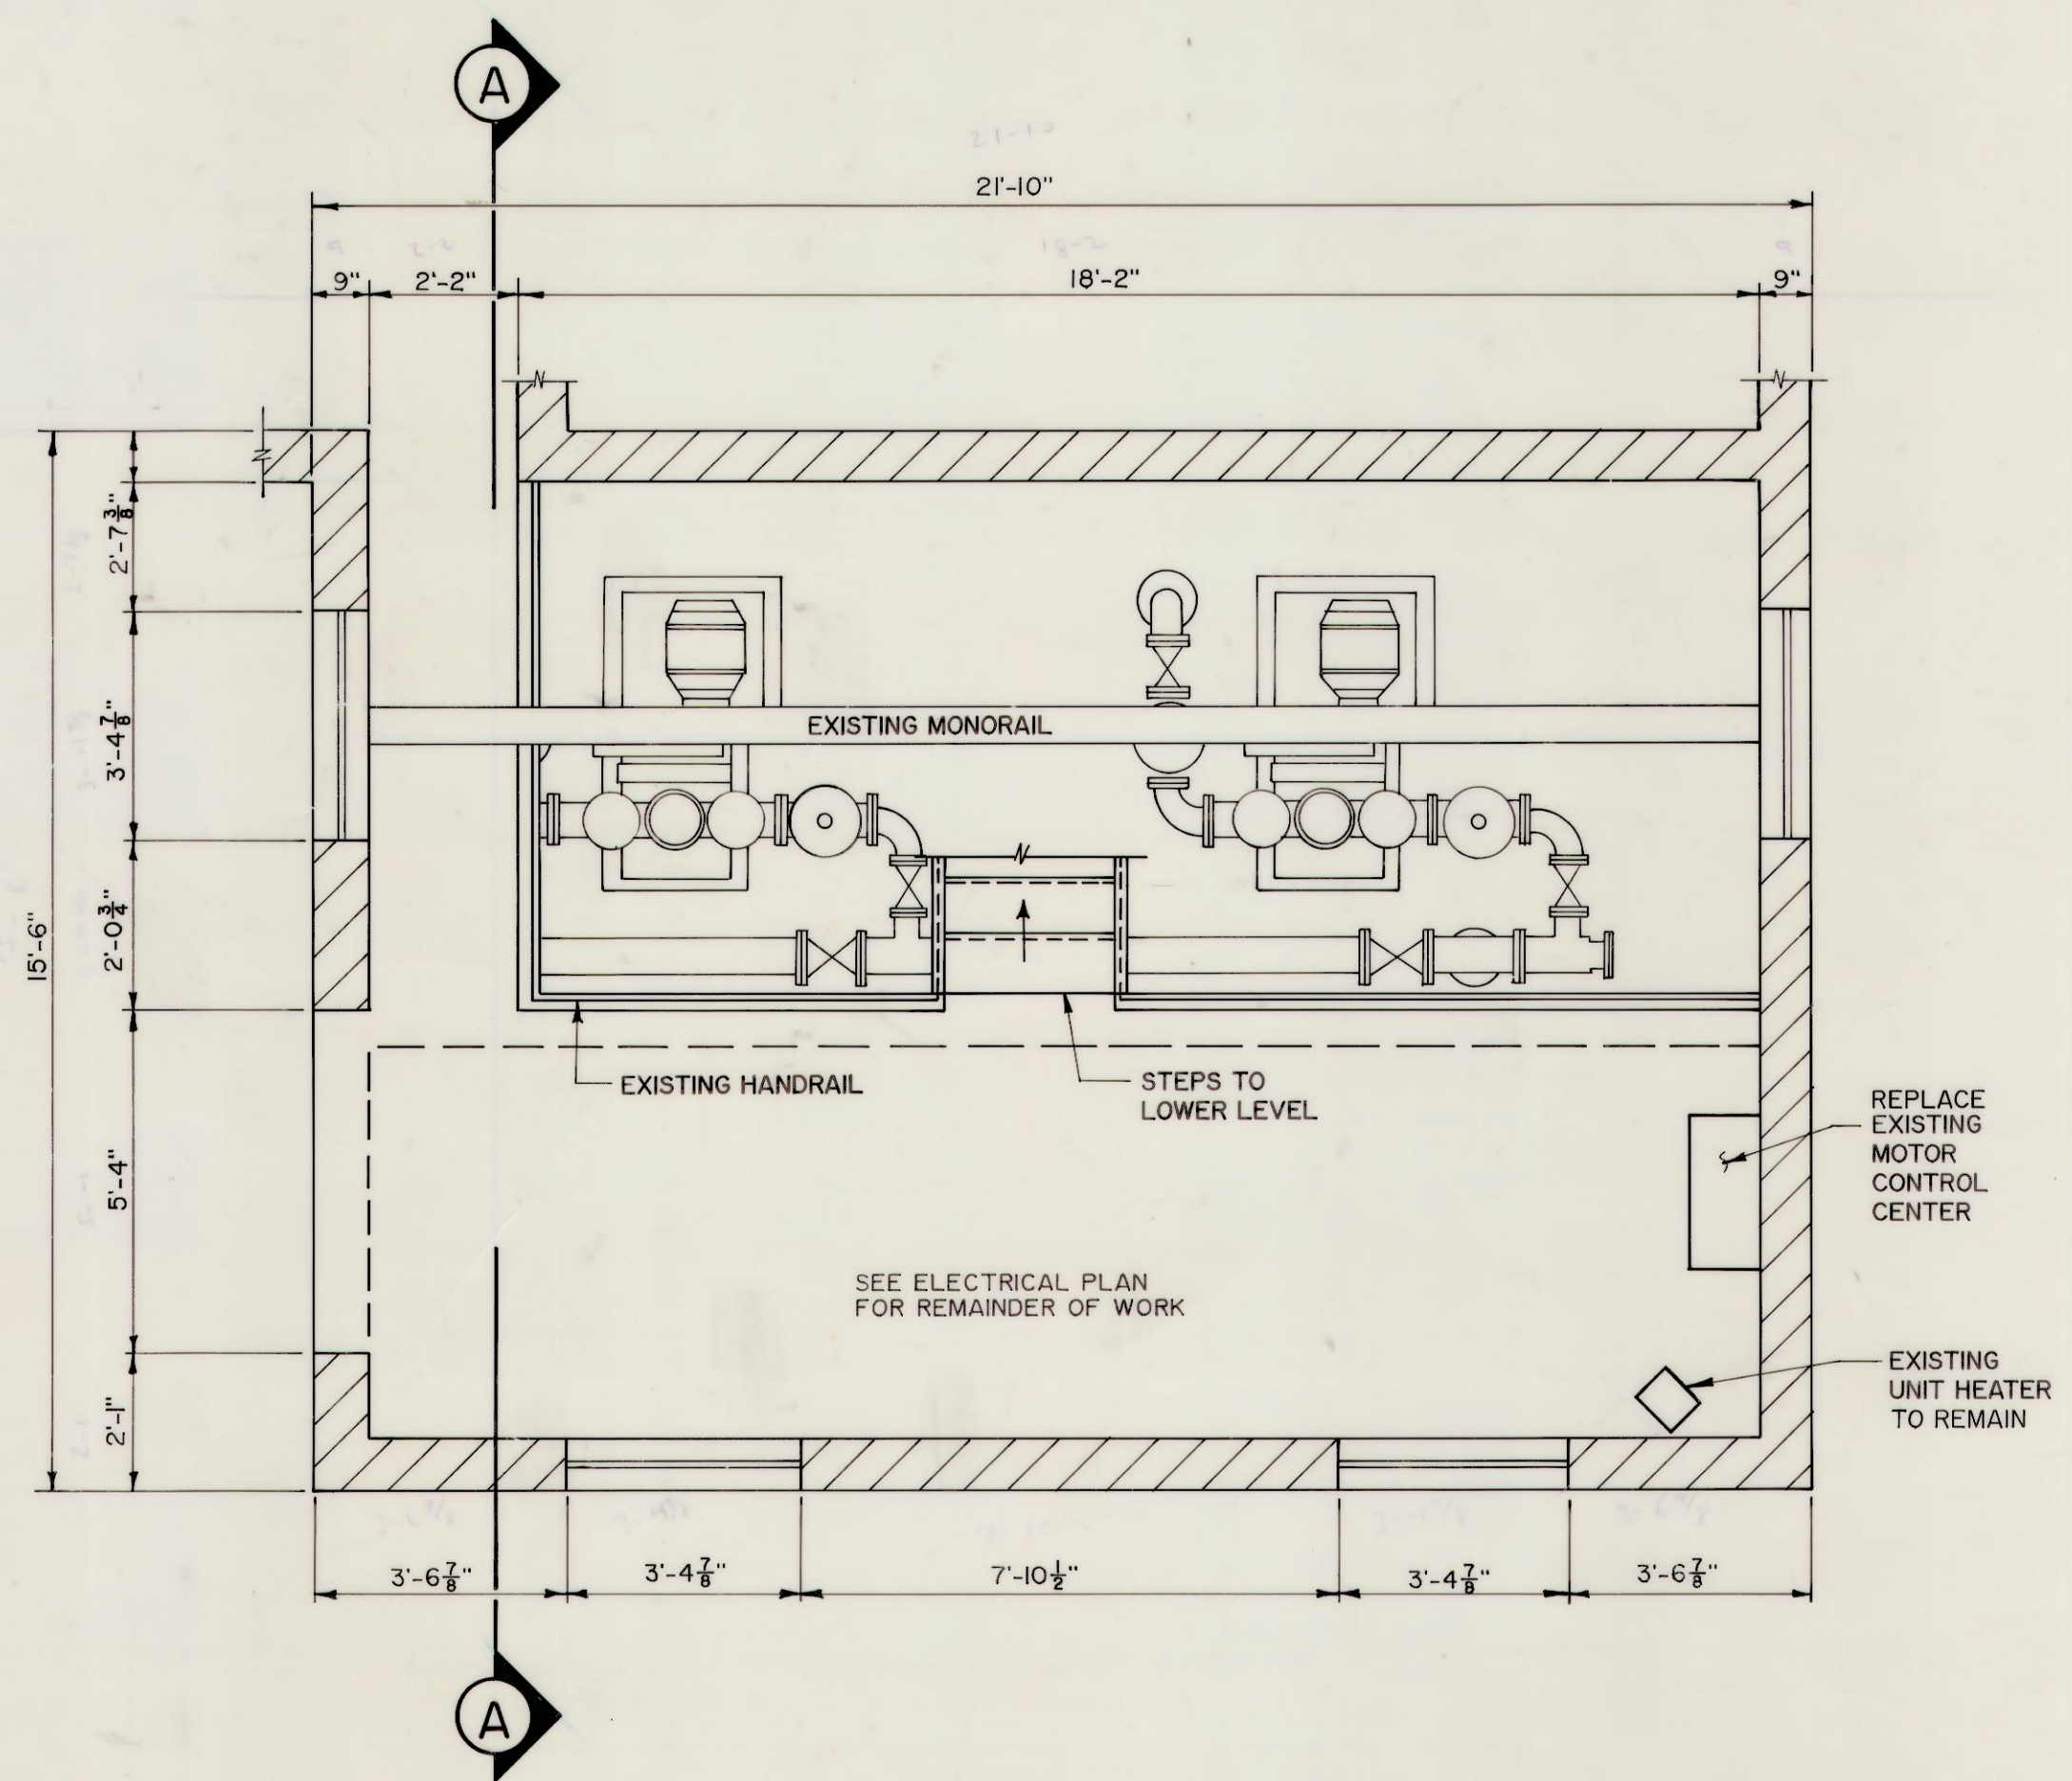


EXISTING PLAN - UPPER LEVEL
 (SHOWN FOR INFORMATION ONLY)

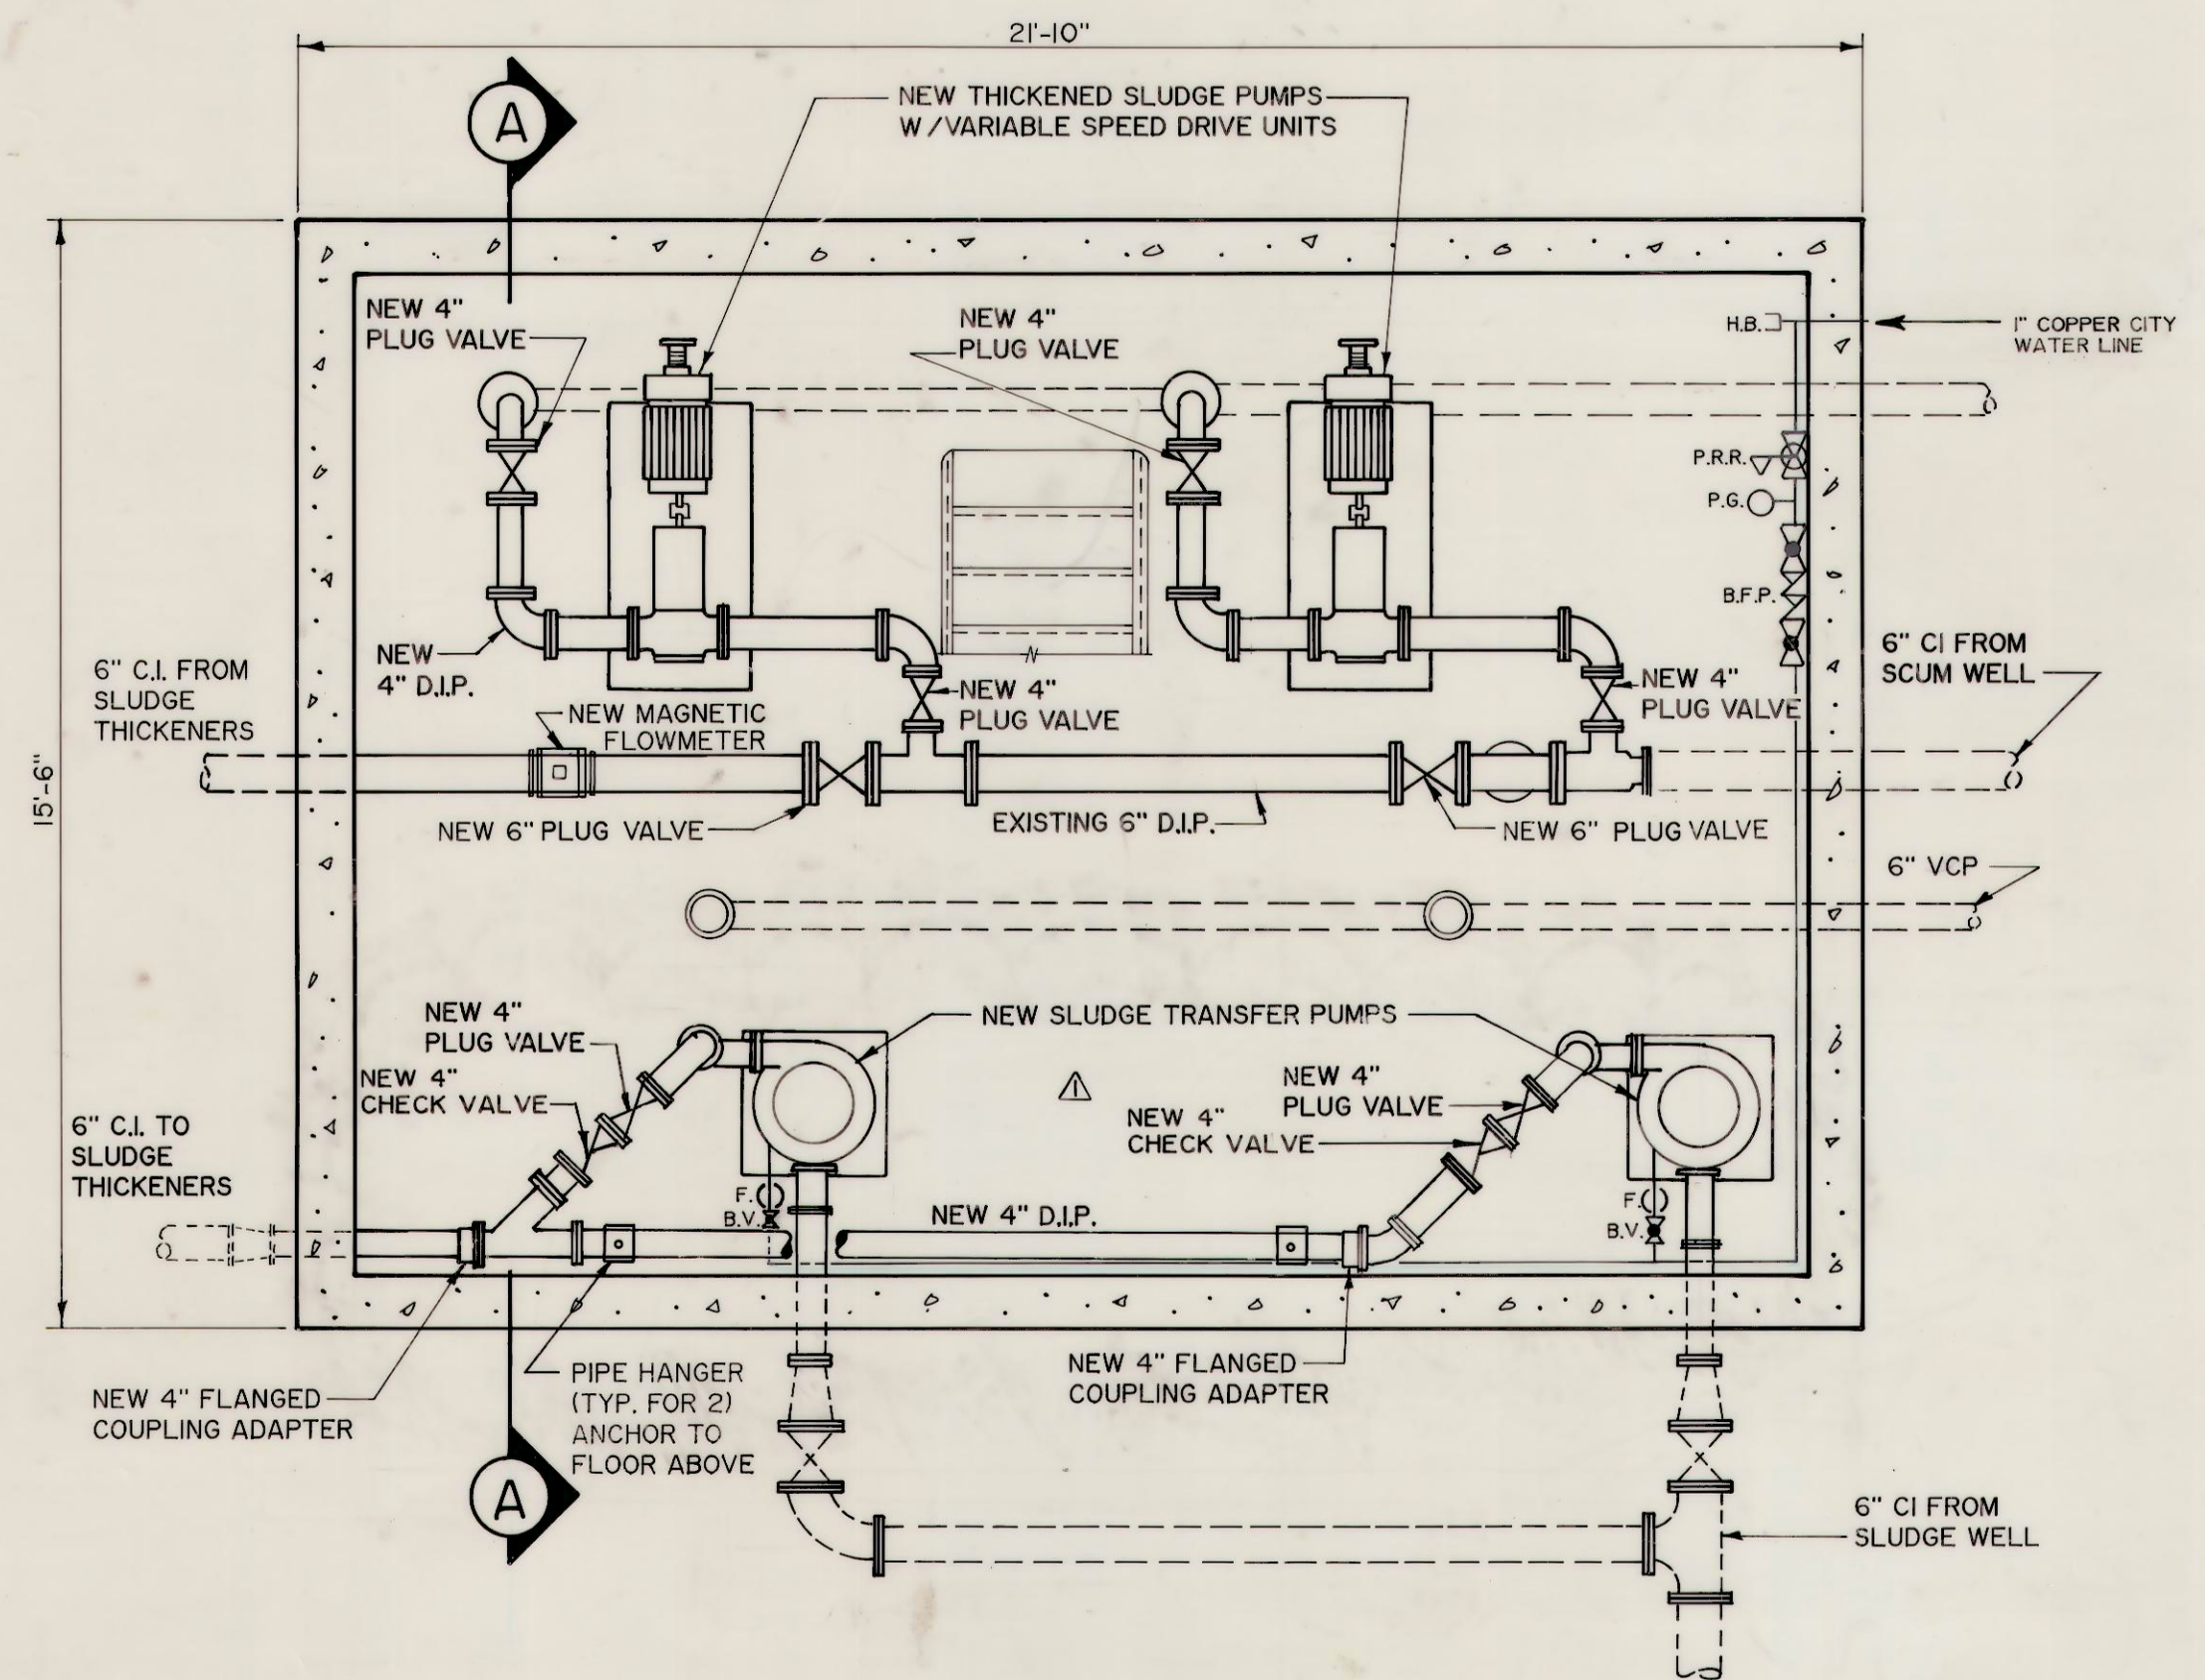


PROPOSED PLAN - LOWER LEVEL
 SCALE: 3/8" = 1'-0"
 NOTE: SEE DRAWING 16 FOR ELECTRICAL PLAN.

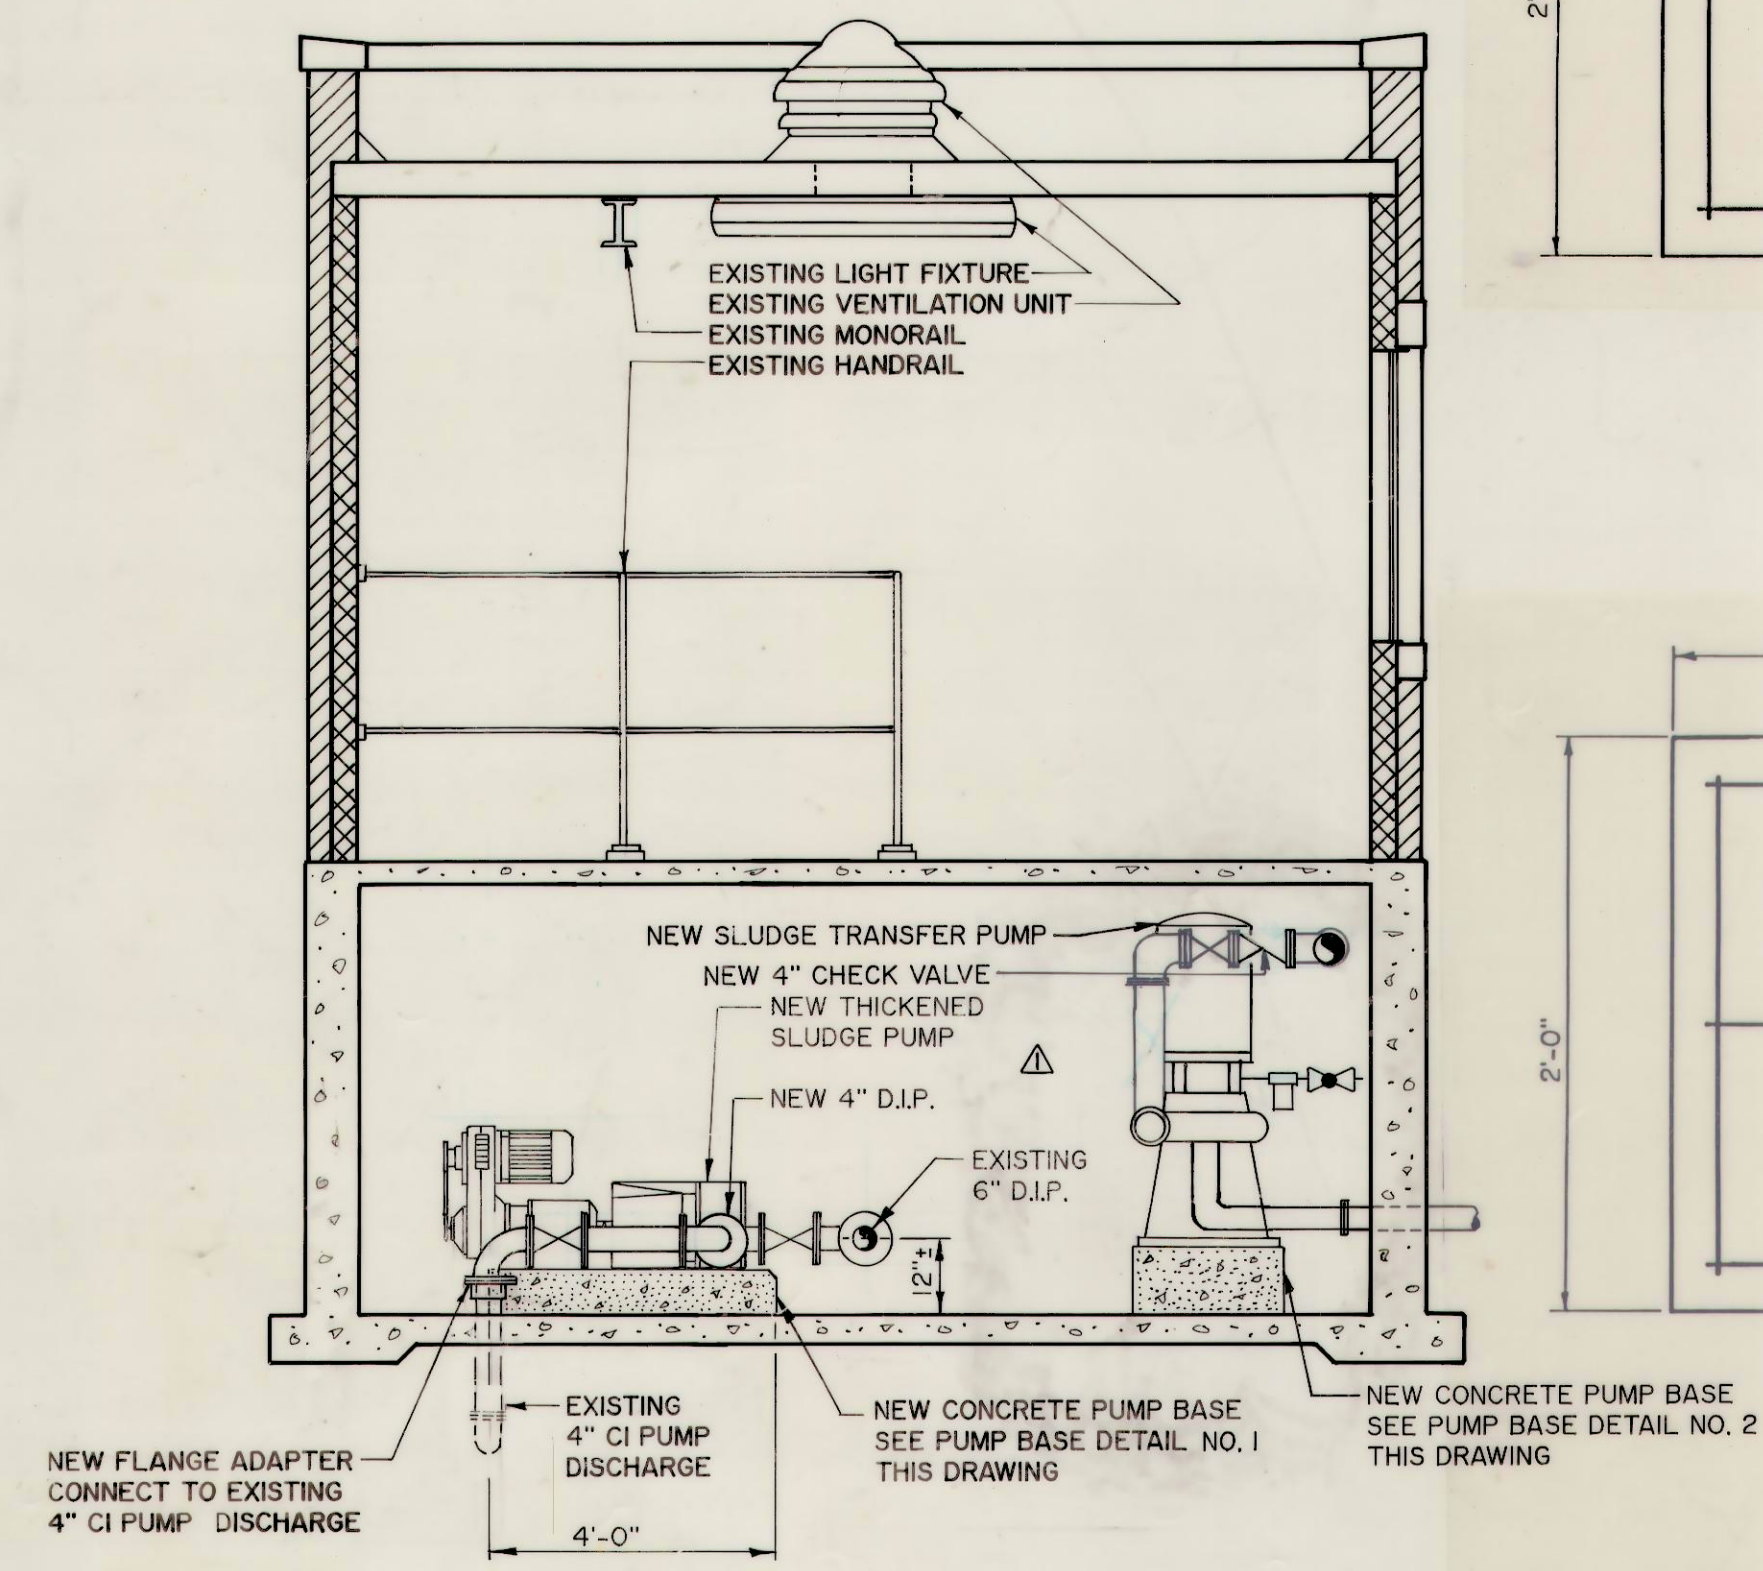

SECTION A
 SCALE: 3/8" = 1'-0"

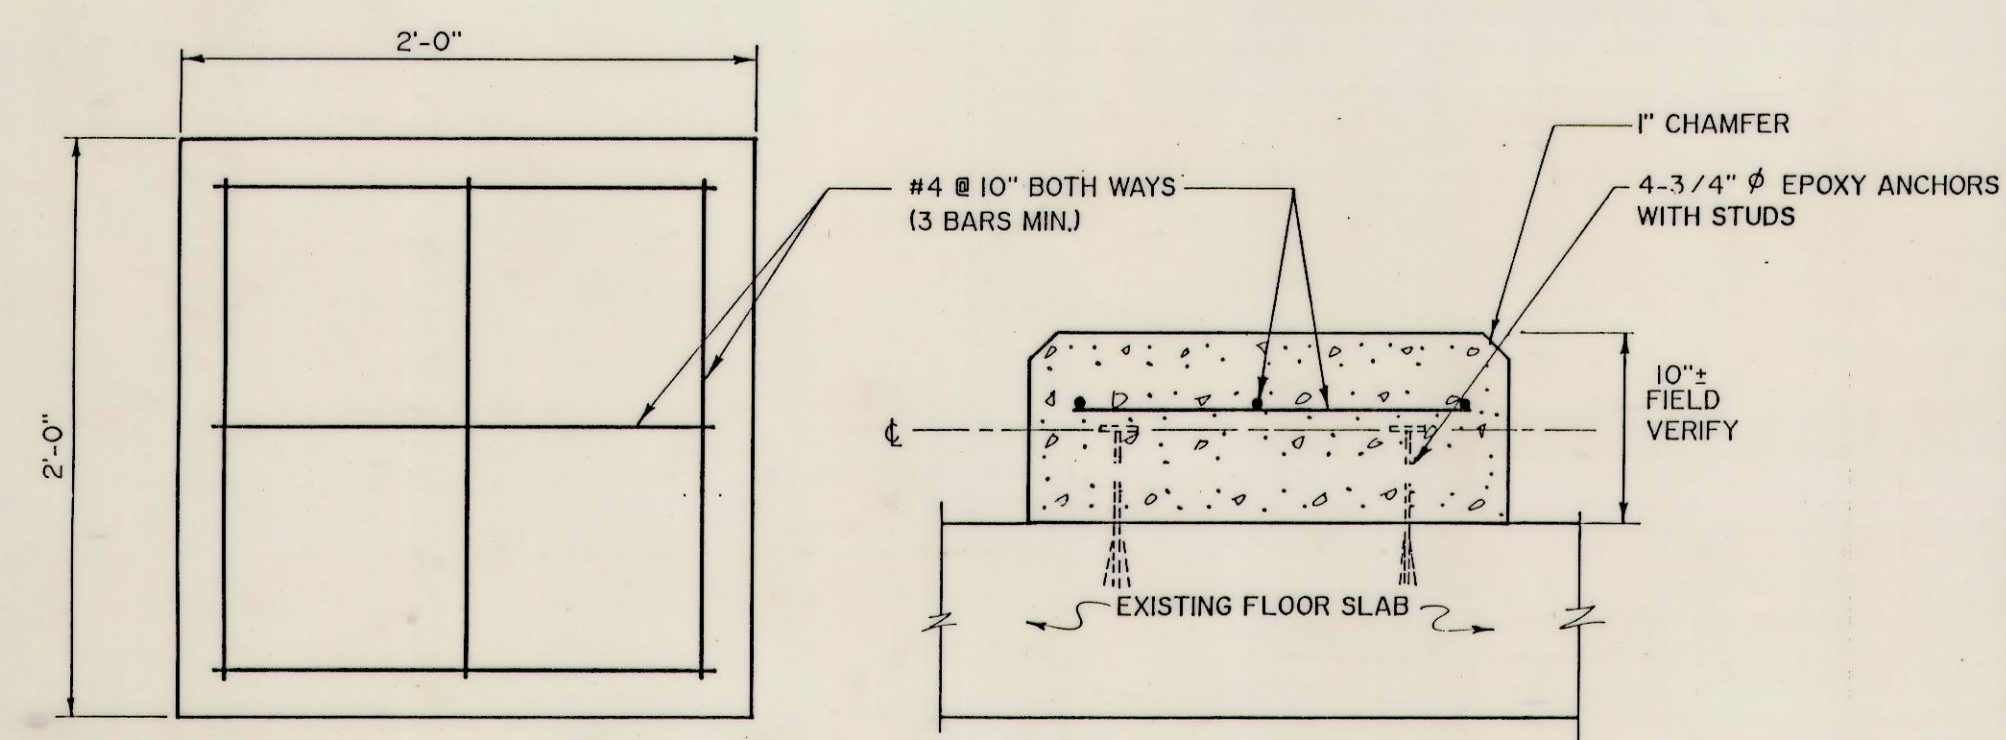

PUMP BASE DETAIL NO. 2
 SCALE: NONE

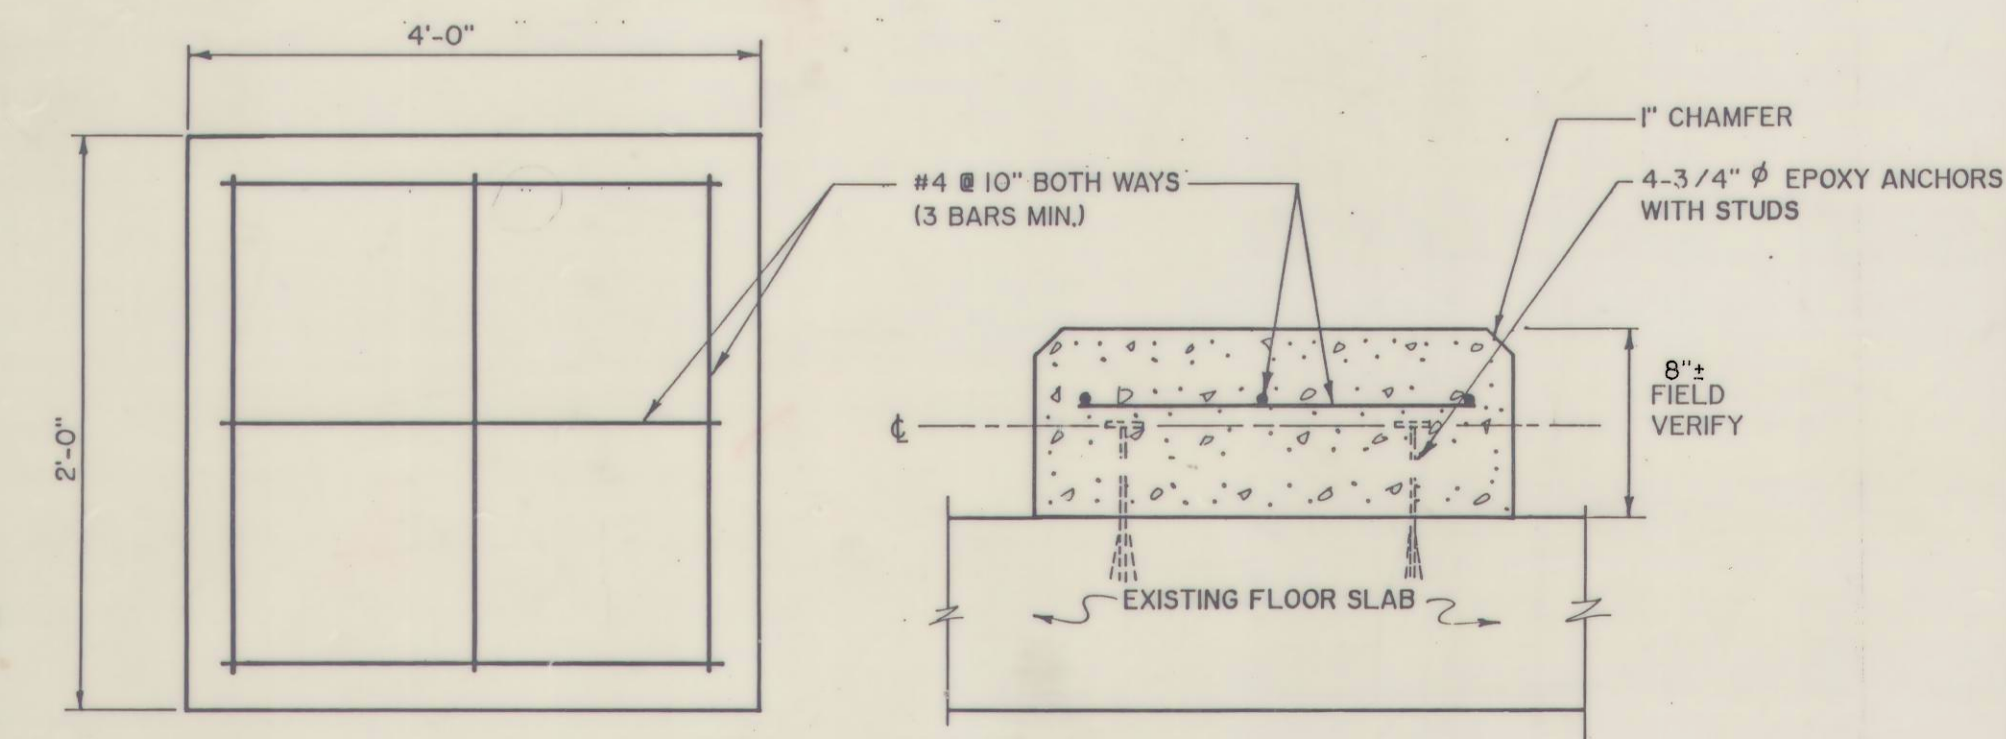

PUMP BASE DETAIL NO. 1
 SCALE: NONE

	REMOVE EXIST. WATERSEAL UNIT	
	INSTALL NEW SLUDGE TRANSFER PUMPS	
	REMOVE EXIST. SLUDGE TRANSFER PUMPS	4/23/90
REVISION	DESCRIPTION	DATE