



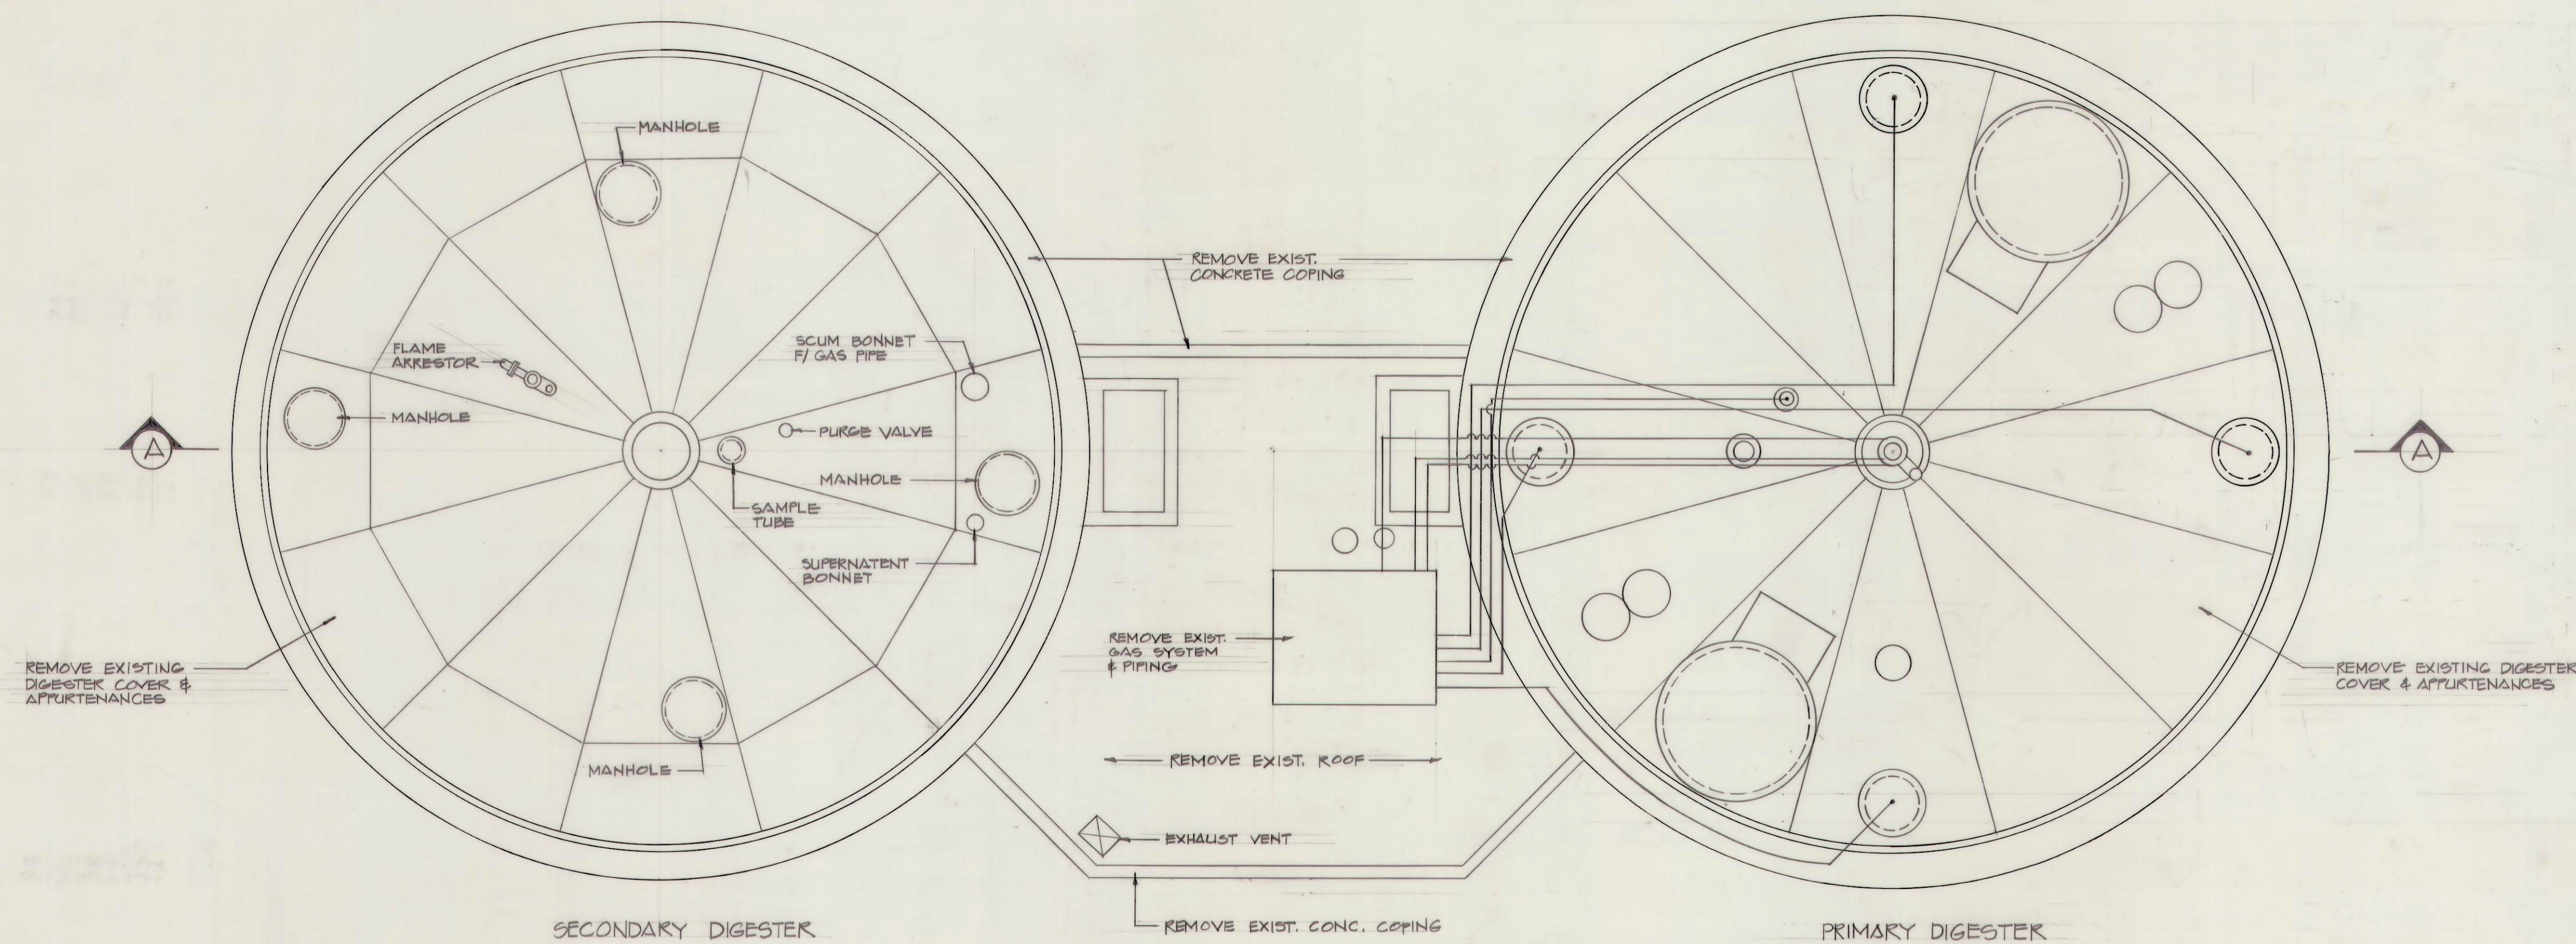

PRIMARY & SECONDARY DIGESTERS- EXISTING ROOF PLAN
SCALE: 1/4" = 1'-0"

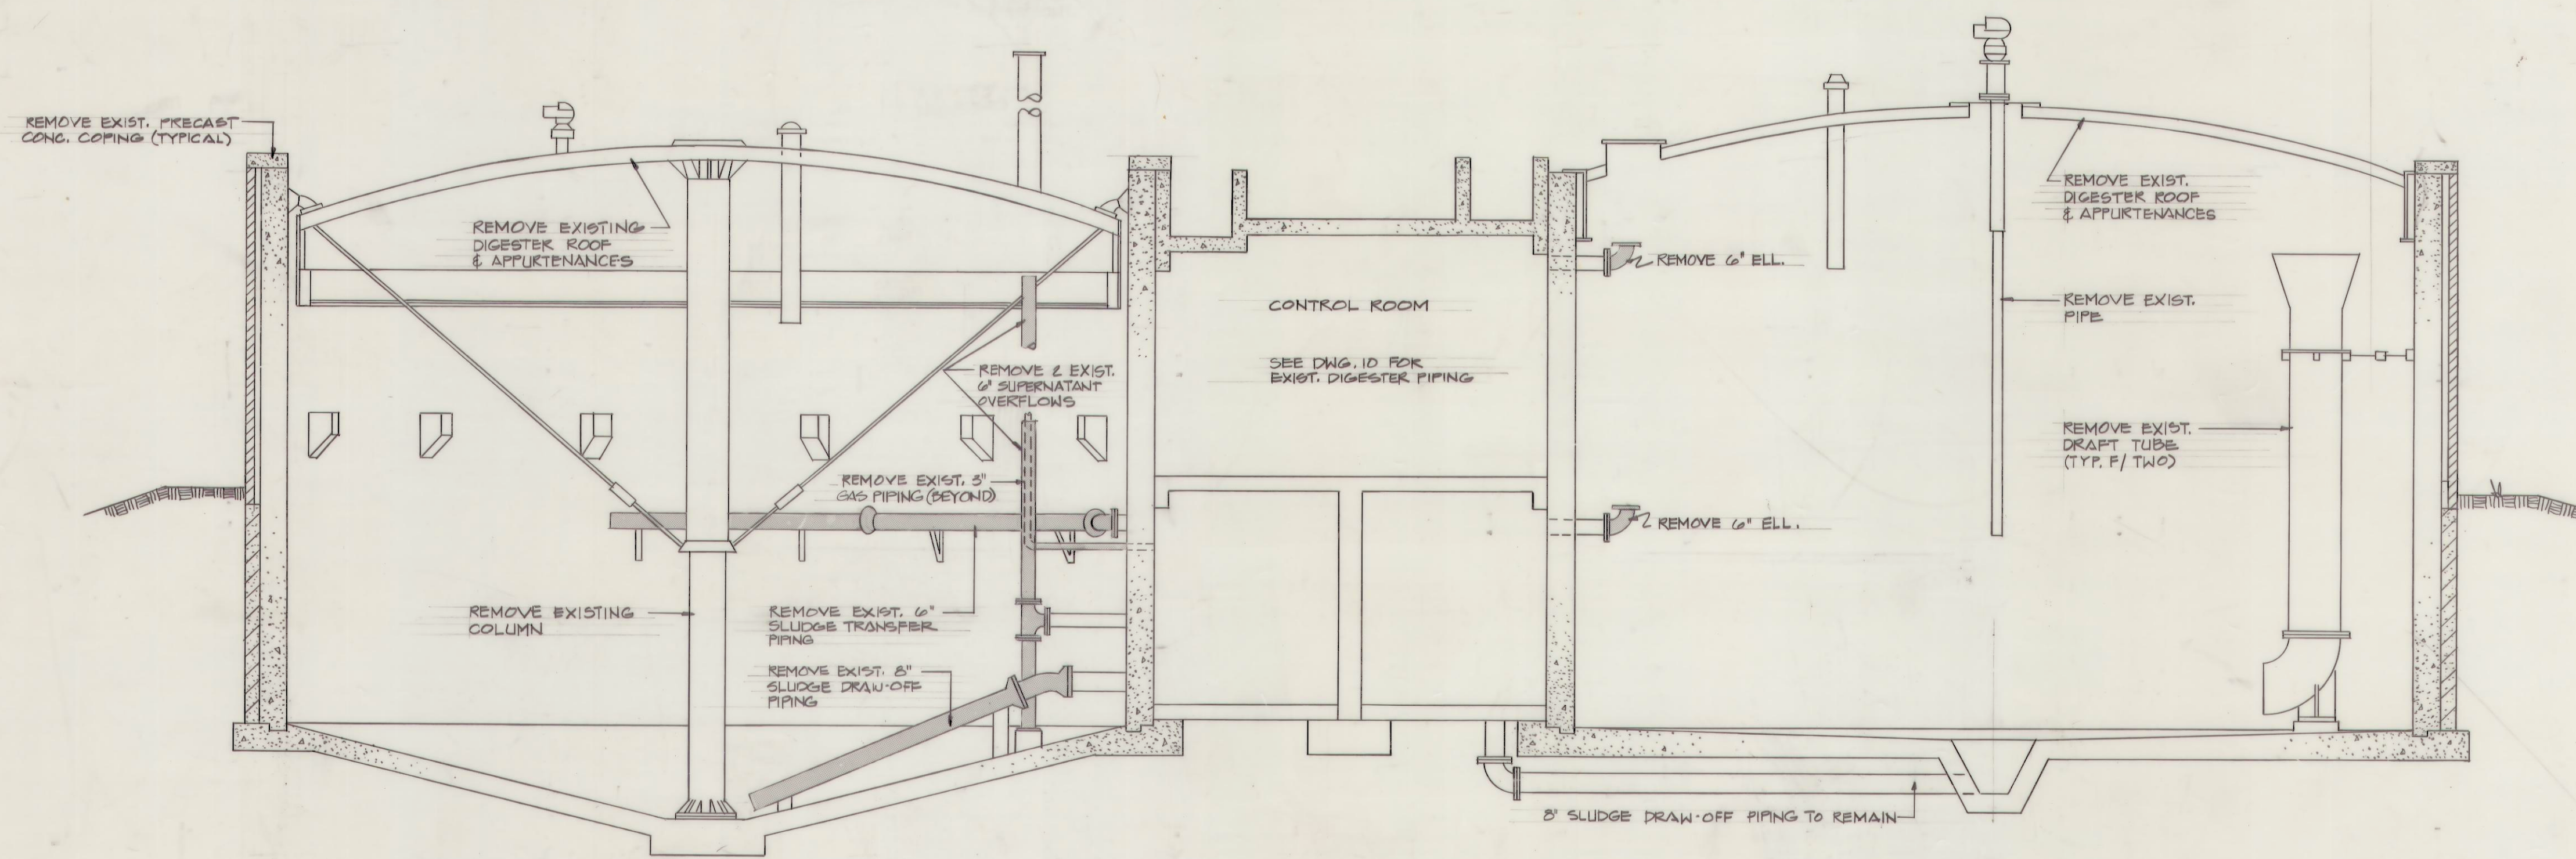

A PRIMARY & SECONDARY DIGESTERS- SECTION
SCALE: 1/4" = 1'-0"

PROJECT INFORMATION

CITY OF ST. ALBANS
MUNICIPAL UTILITY COMMISSION
KANAWHA COUNTY, WEST VIRGINIA
WASTEWATER SYSTEM IMPROVEMENTS
EPA PROJECT No. C-540618-01
CONTRACT No. 1

Chapman Technical Group

DRAWING TITLE

PRIMARY & SECONDARY DIGESTERS
EXISTING ROOF PLAN & SECTIONS

DRAWN
J. BRD
CHECKED
H. CHAPMAN
DATE
JANUARY 1989
SCALE
AS NOTED
PROJECT NUMBER
27016
DRAWING NUMBER