



PROJECT INFORMATION
CITY OF ST. ALBANS
MUNICIPAL UTILITY COMMISSION
KANAWHA COUNTY, WEST VIRGINIA
WASTEWATER SYSTEM IMPROVEMENTS
EPA PROJECT NO. C-540618-01

CONTRACT NO. 1




Chapman Technical Group


DRAWING TITLE
PRIMARY & SECONDARY DIGESTERS
PROPOSED ROOF PLAN & SECTIONS

DRAWN
J. BIRD
CHECKED
H. CHAPMAN
DATE
JANUARY 1989
SCALE
AS NOTED
PROJECT NUMBER
51010
DRAWING NUMBER


9

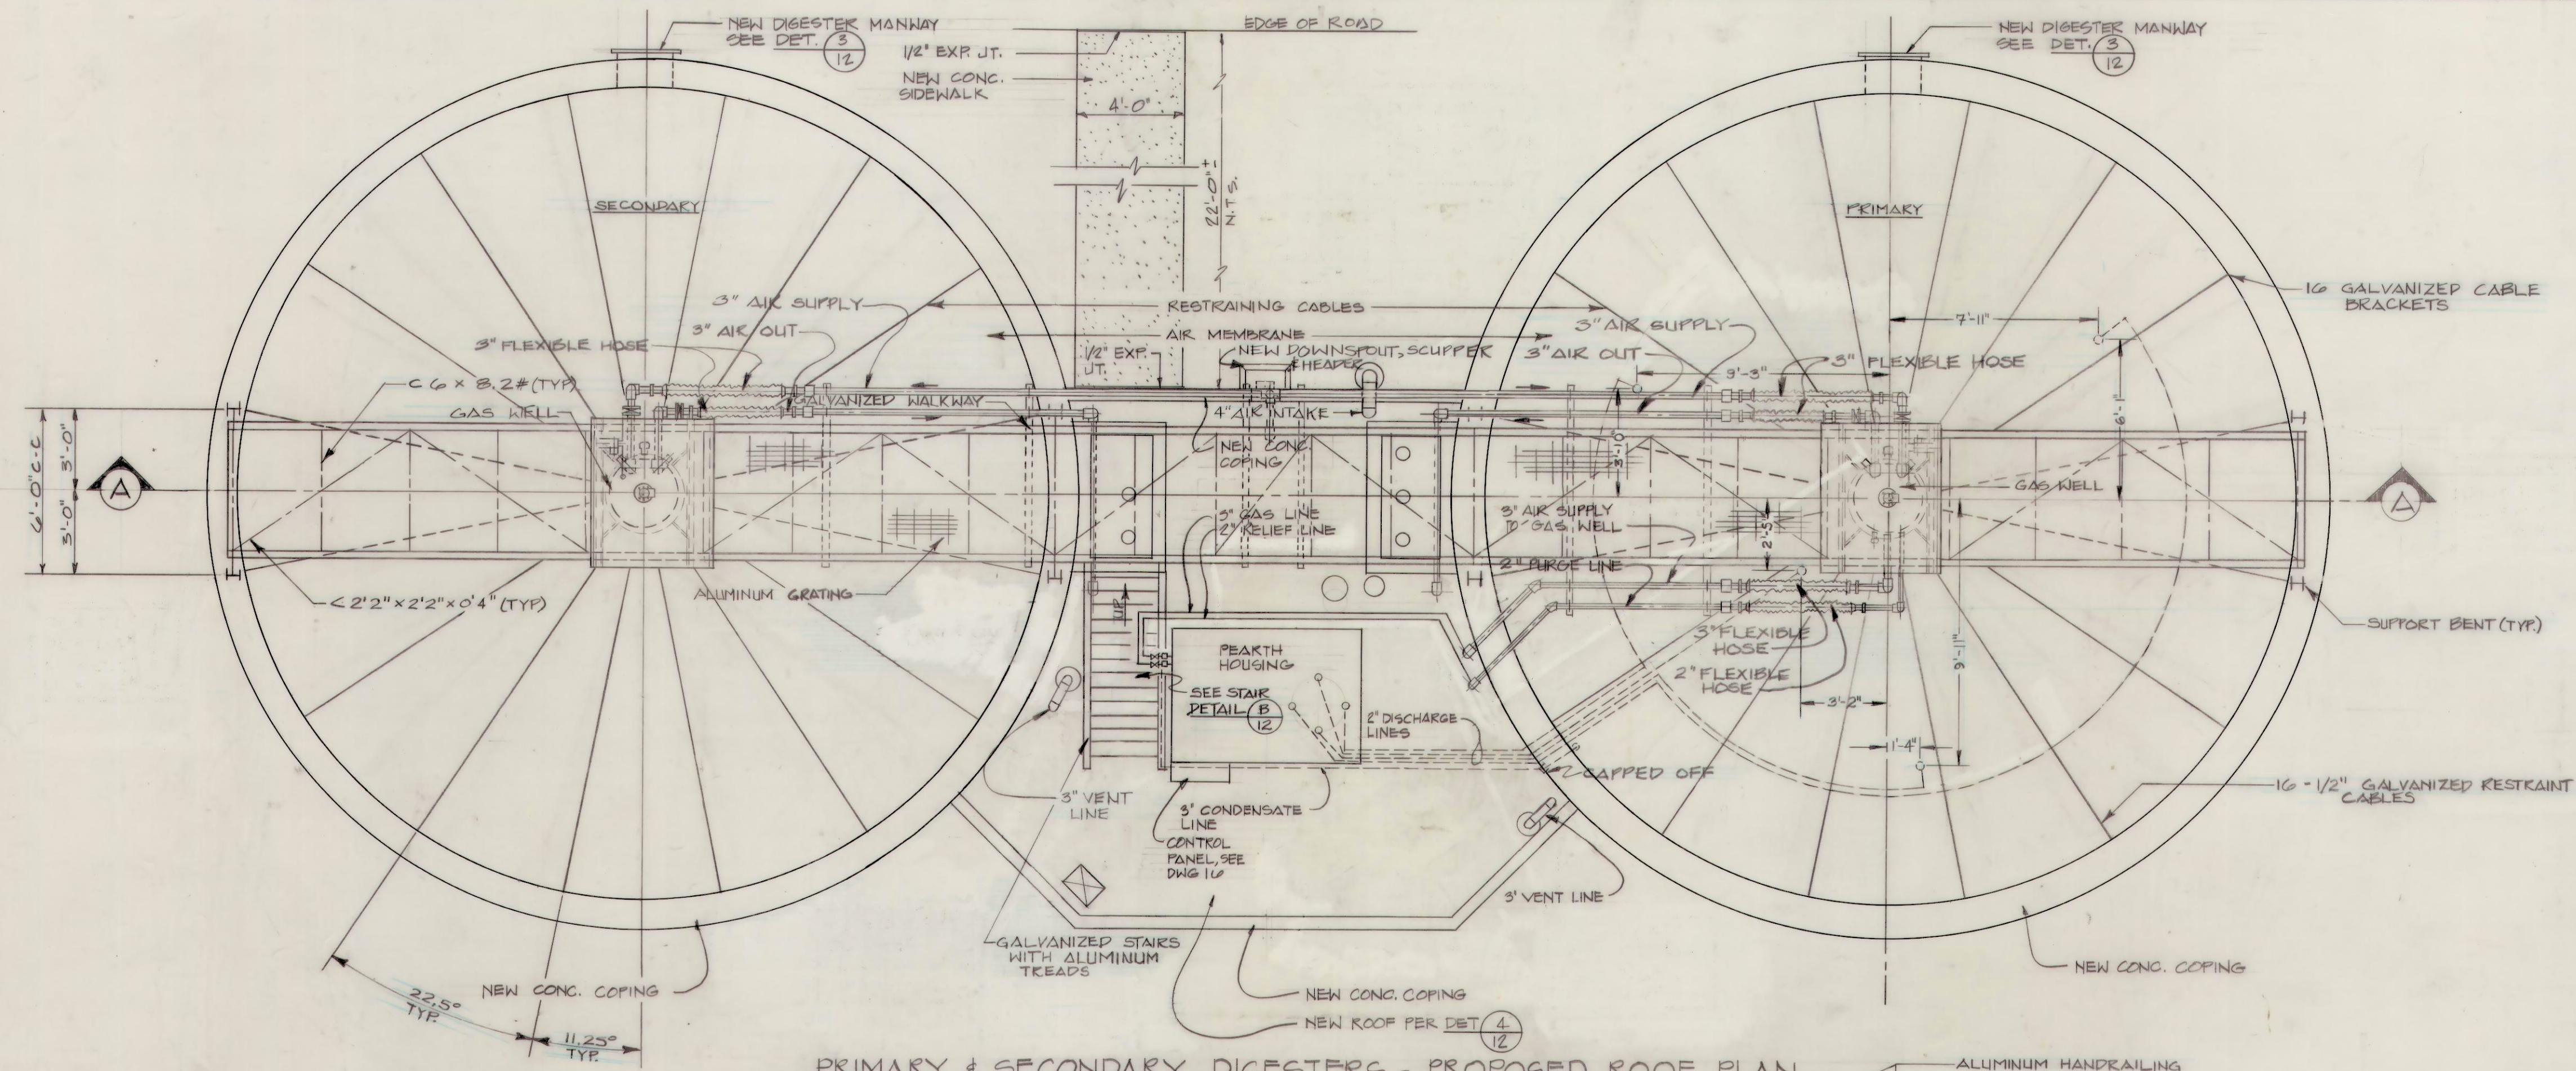

1 SEALING RING DETAIL
SCALE: 3/4\"/>

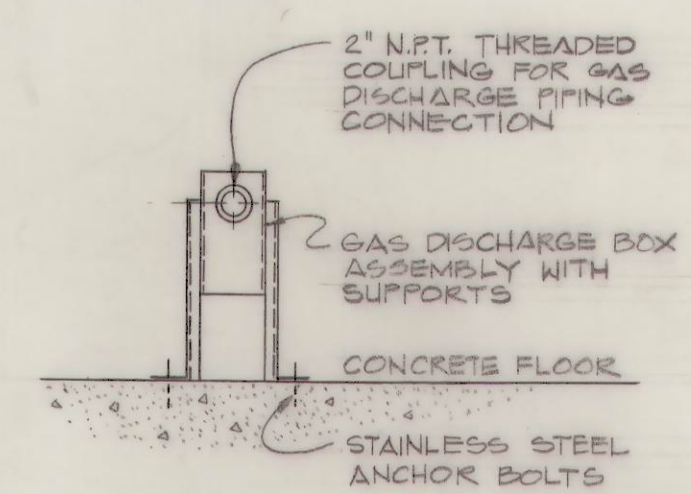

2 GAS DISCHARGE BOX DETAIL
SCALE: NONE

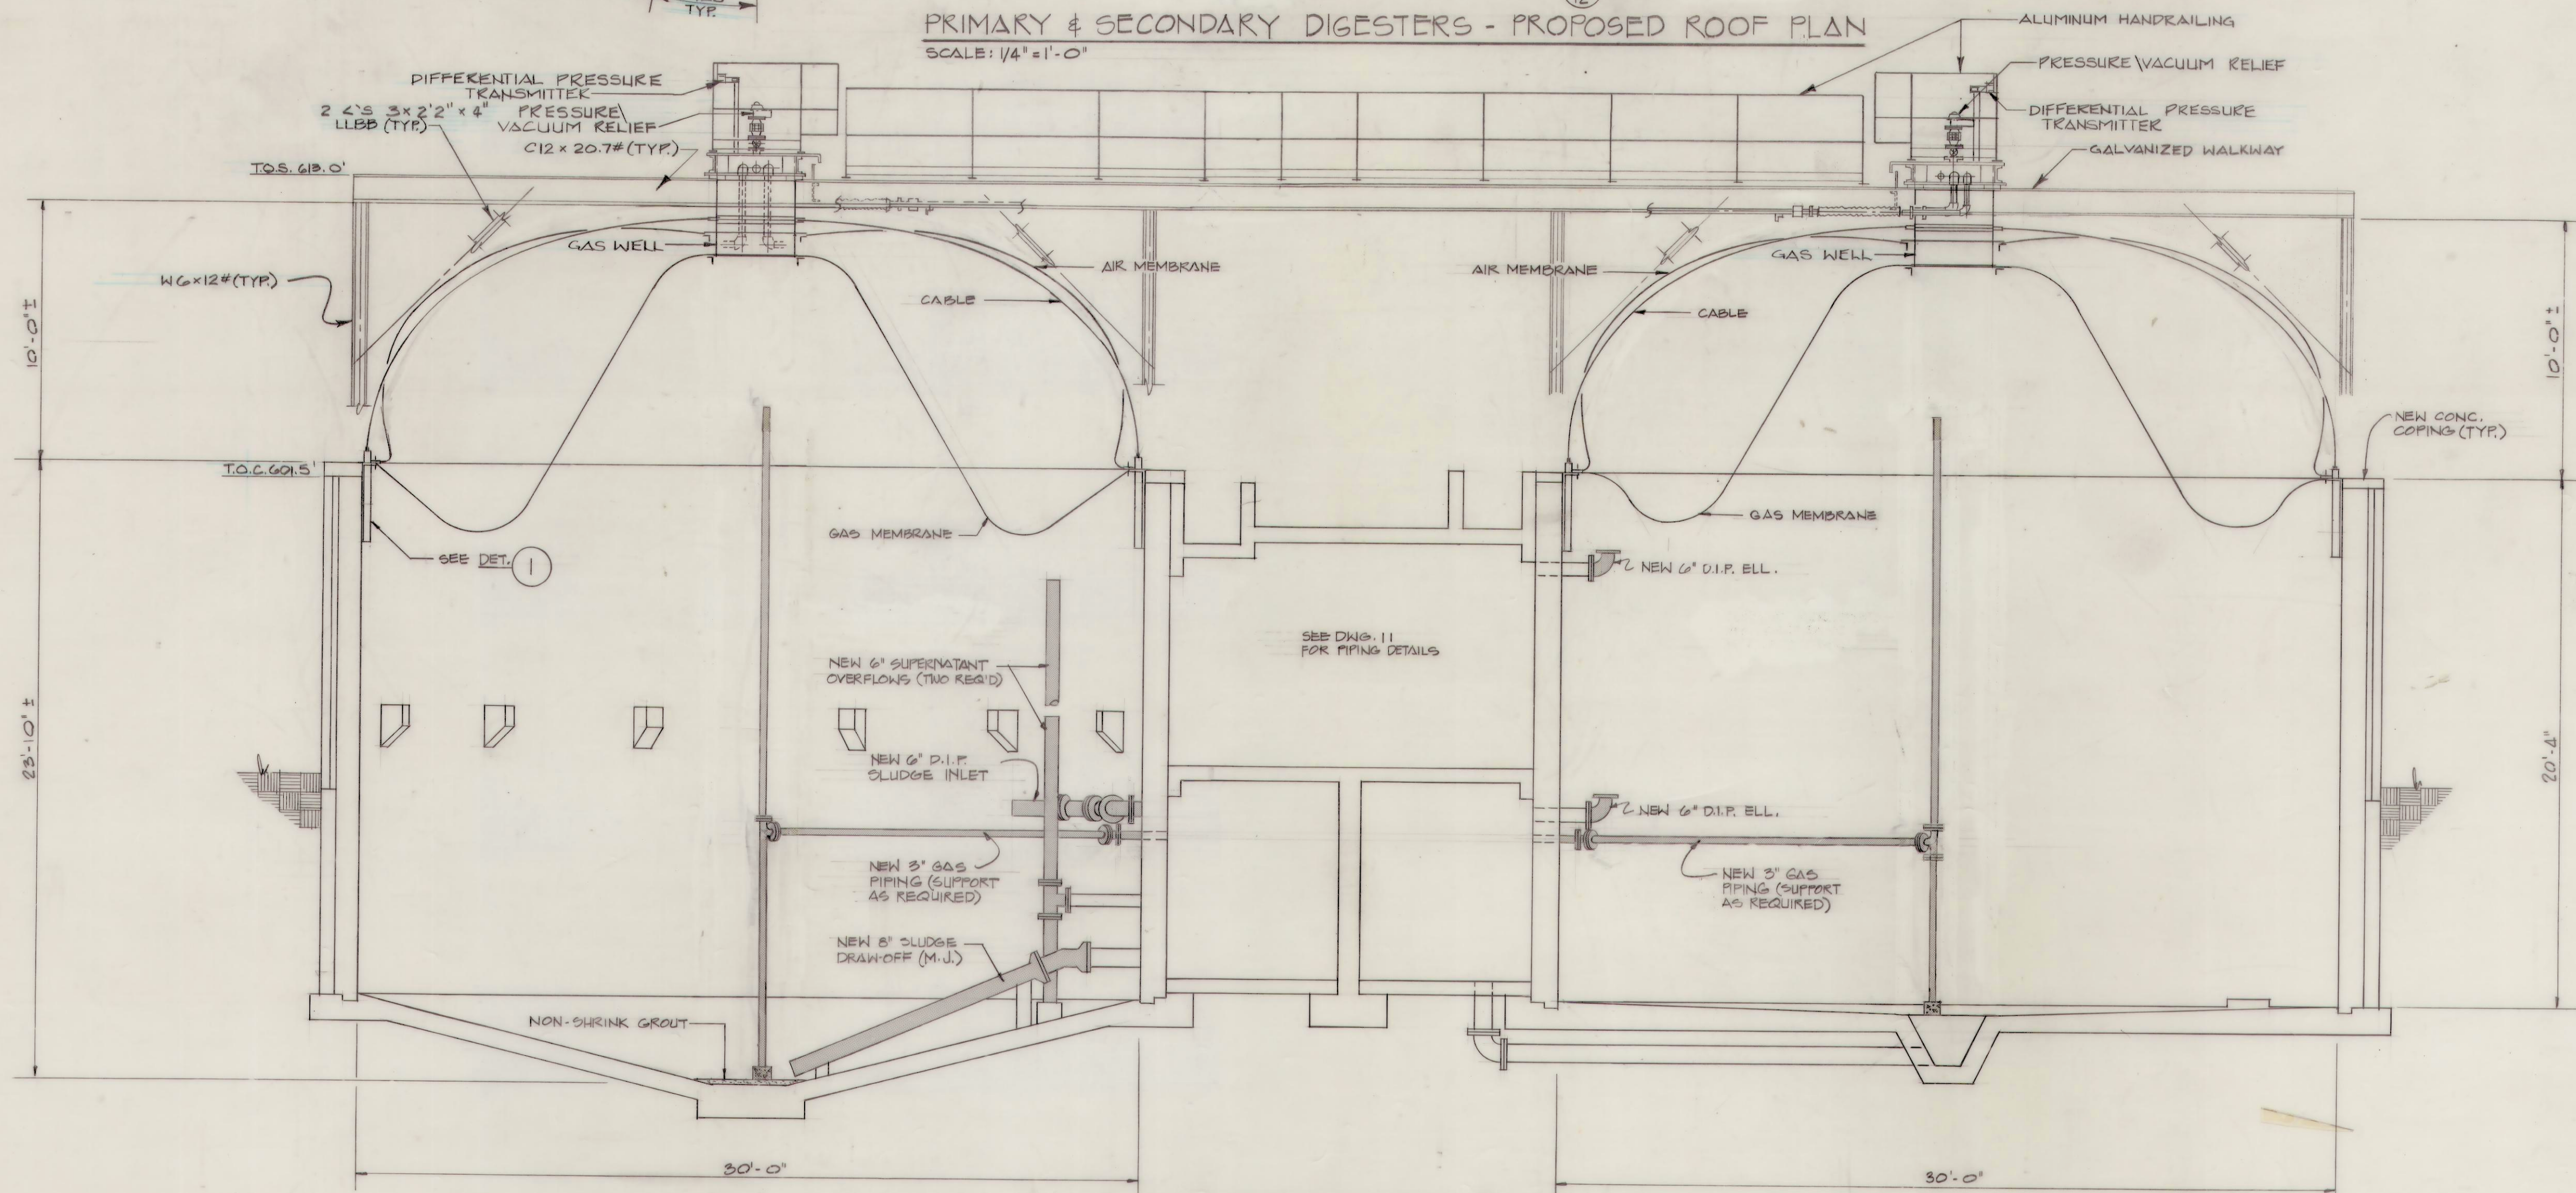

A PRIMARY & SECONDARY DIGESTERS - SECTION
SCALE: 1/4\"/>

NOTE: SEE DWG. 16 FOR ELECTRICAL & MECHANICAL PLANS.